
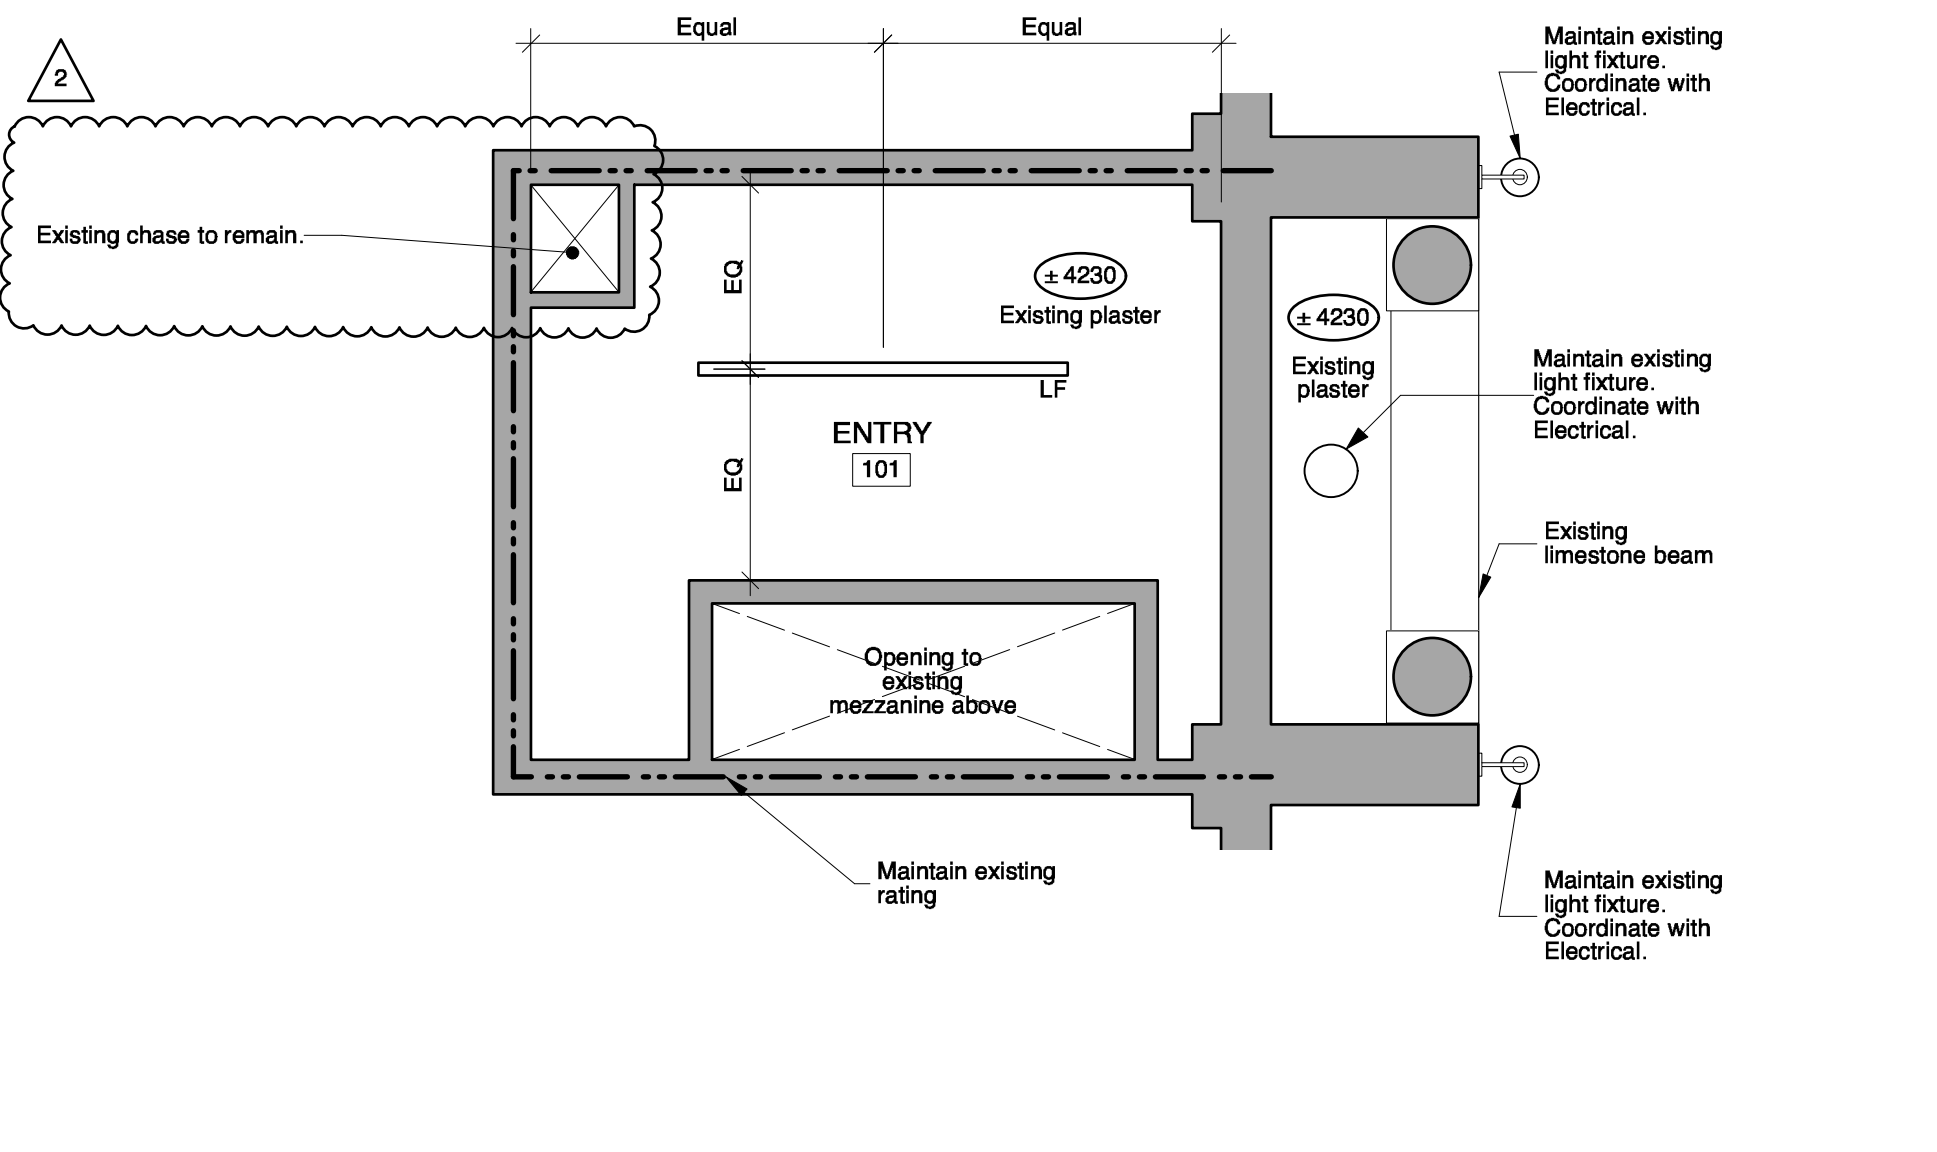


Owner
City of Winnipeg
185 King Street
Winnipeg, Manitoba, R3B 1J1
(204) 794-4418 (204) 986-4354

Rev. No.	Date	Revision Notes
1.	2017.11.28	Issued for Construction
2.	2018.01.30	Issued for Addendum 3

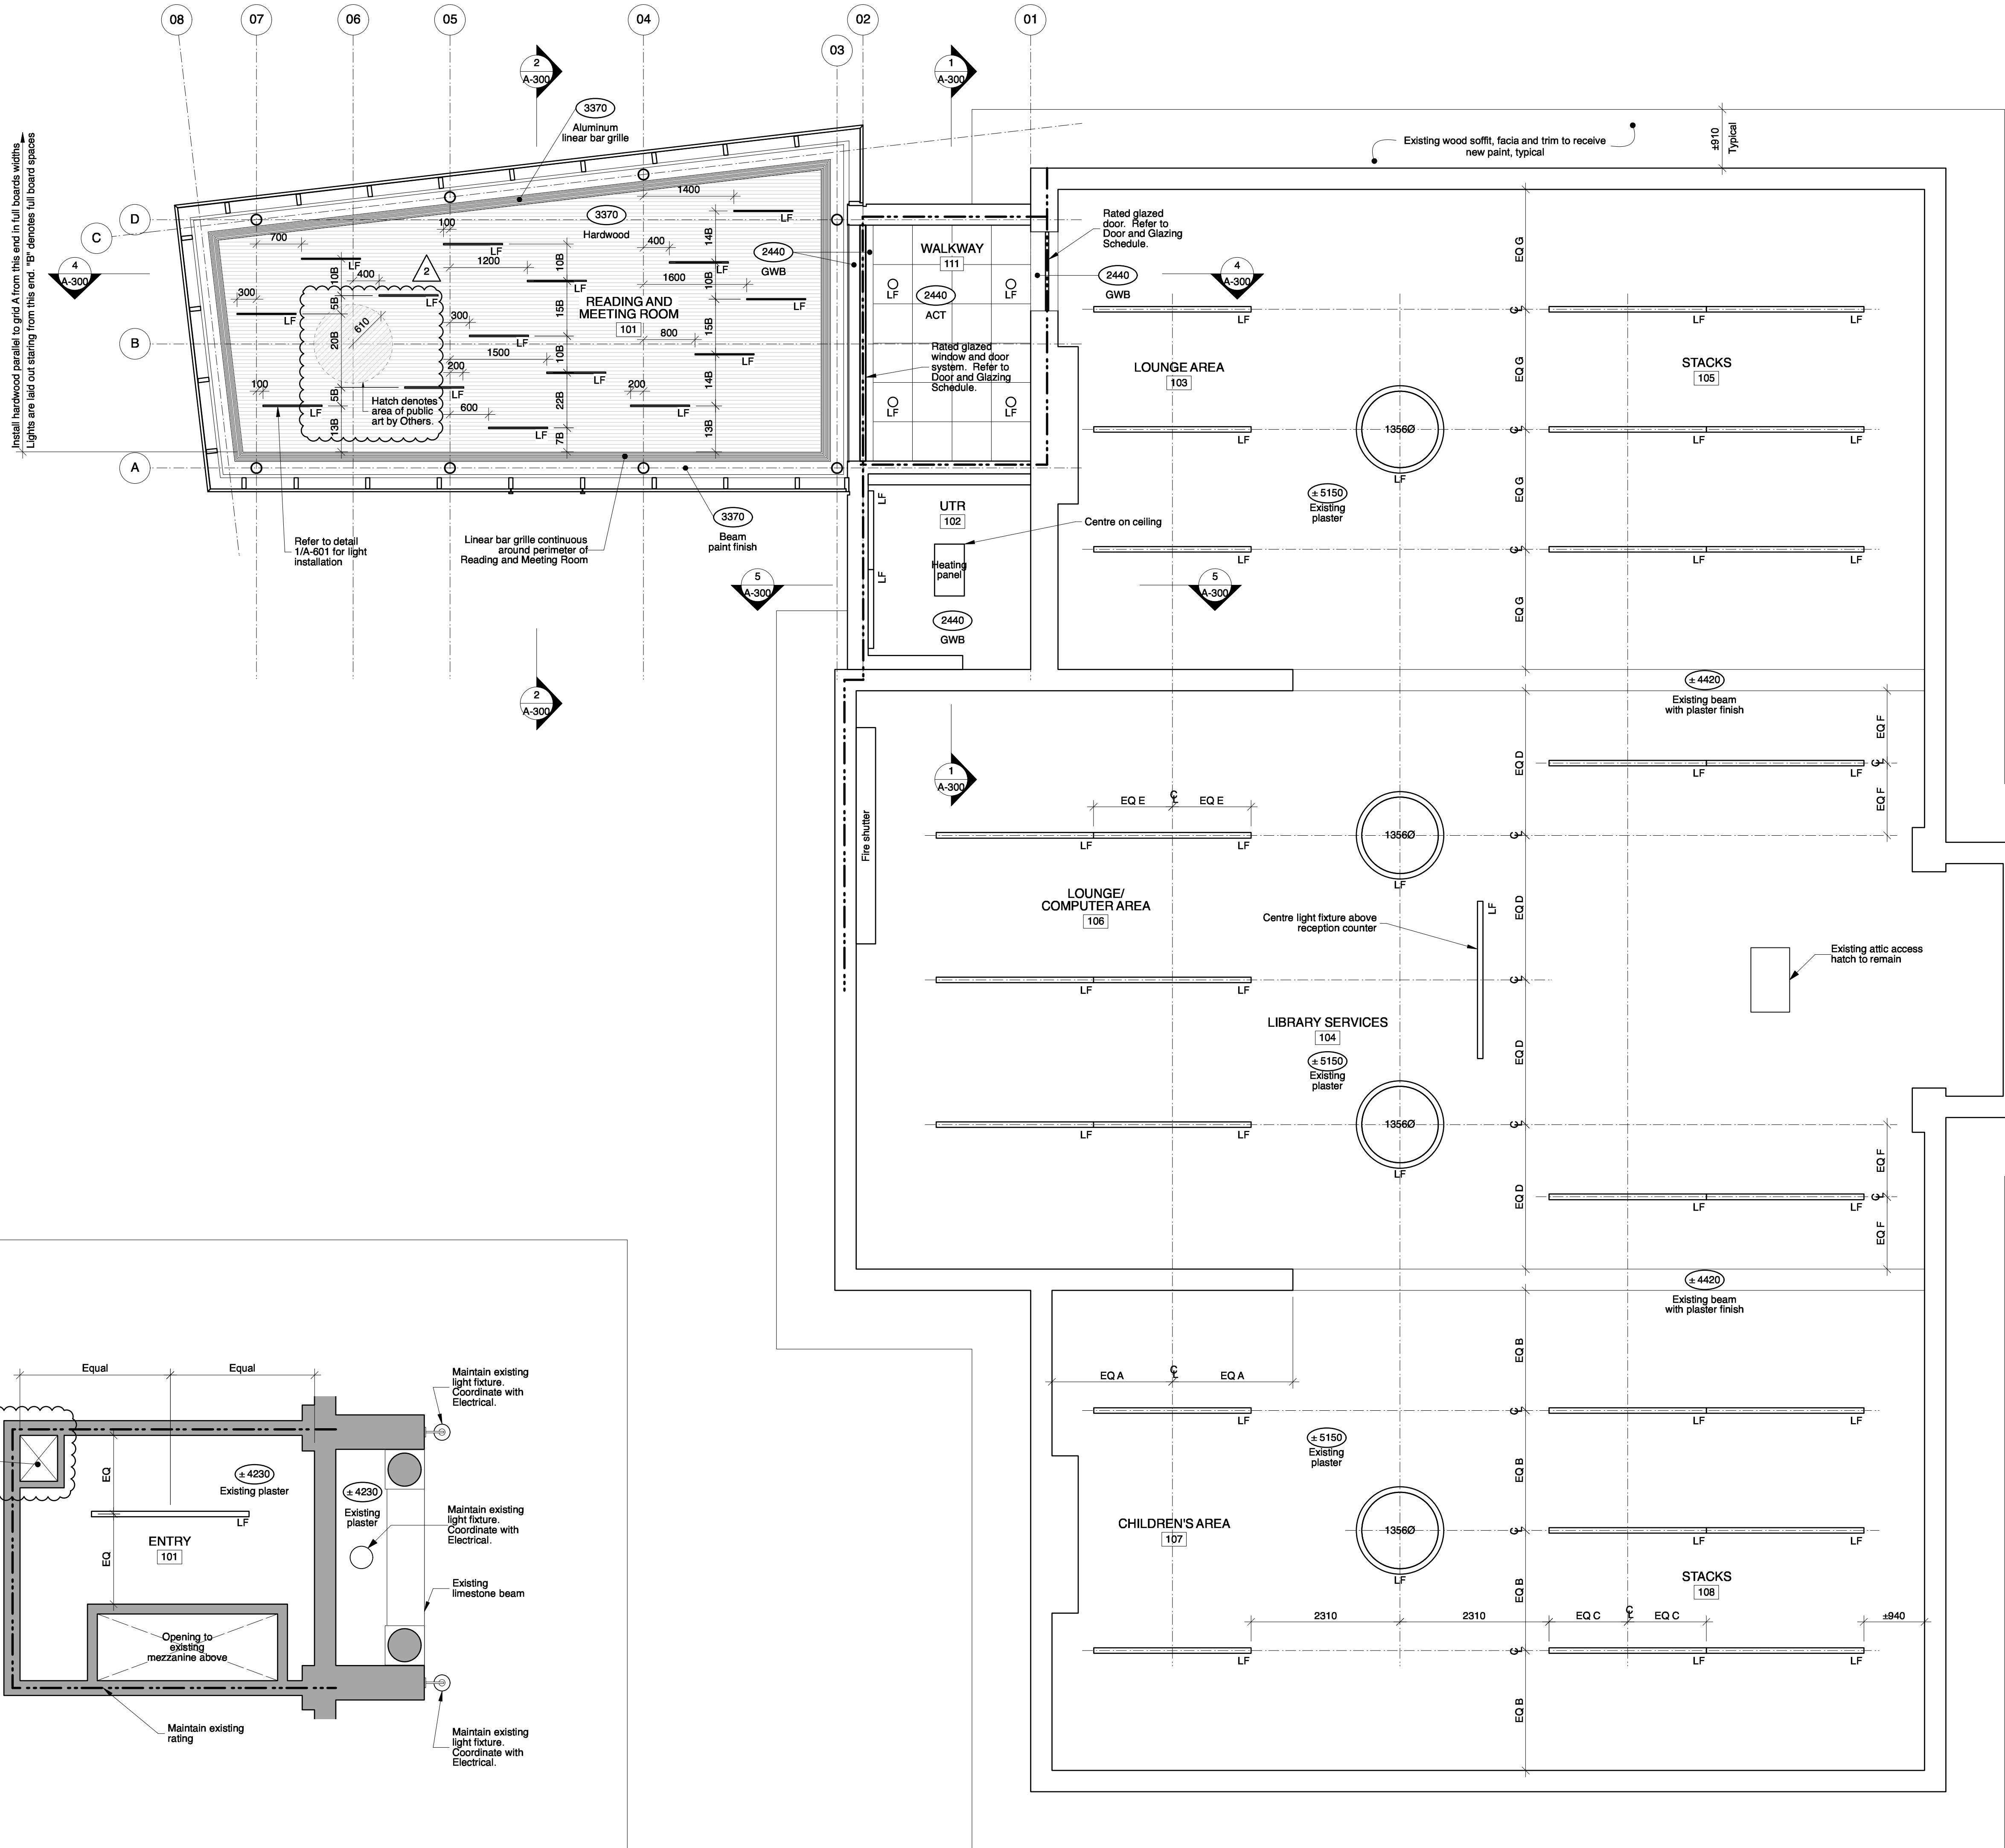

Note: All light fixture locations to be confirmed on site in anticipation of stack layouts

- Reflected Ceiling Plan Legend:**
- Circular light (LED, size as noted, Coordinate with Electrical)
 - Pot light (LED, Coordinate with Electrical)
 - Suspended/surface mounted strip light (LED, Coordinate with Electrical)
 - ACT mounted light (LED, Coordinate with Electrical)
 - Supply air grille (Coordinate with Mechanical)
 - Return air grille (Coordinate with Mechanical)
 - Acoustic ceiling tile (610x610)
 - 45 minute fire resistance rating



This drawing must not be scaled. The contractor shall verify all dimensions and other data on site prior to commencement of work. Discrepancies, errors, and omissions are to be reported to Public City Architecture Inc. prior to proceeding with the Work.
Drawings and specifications as instruments of service are the property of Public City Architecture Inc. No reproduction or revision to these drawings may be made without the permission of Public City Architecture Inc. and when made, must bear their name. All prints to be returned to Public City Architecture Inc. upon request.

Project
Cornish Library Renovation
Drawing
Reflected Ceiling Plan
Drawn By
TH, MP
Scale
As noted
Reviewed By
PS
Drawing No.
A-203

2 Entry Landing Reflected Ceiling Plan
1:50
A-203

1 Main Floor Reflected Ceiling Plan
1:50
A-203