



**CONSTRUCTION NOTES:**  
 1. CONTRACTOR SHALL ARRANGE AND PAY FOR ALL COSTS FOR NEW ELECTRICAL SERVICE BY MANITOBA HYDRO.



CHEVRIER BOULEVARD

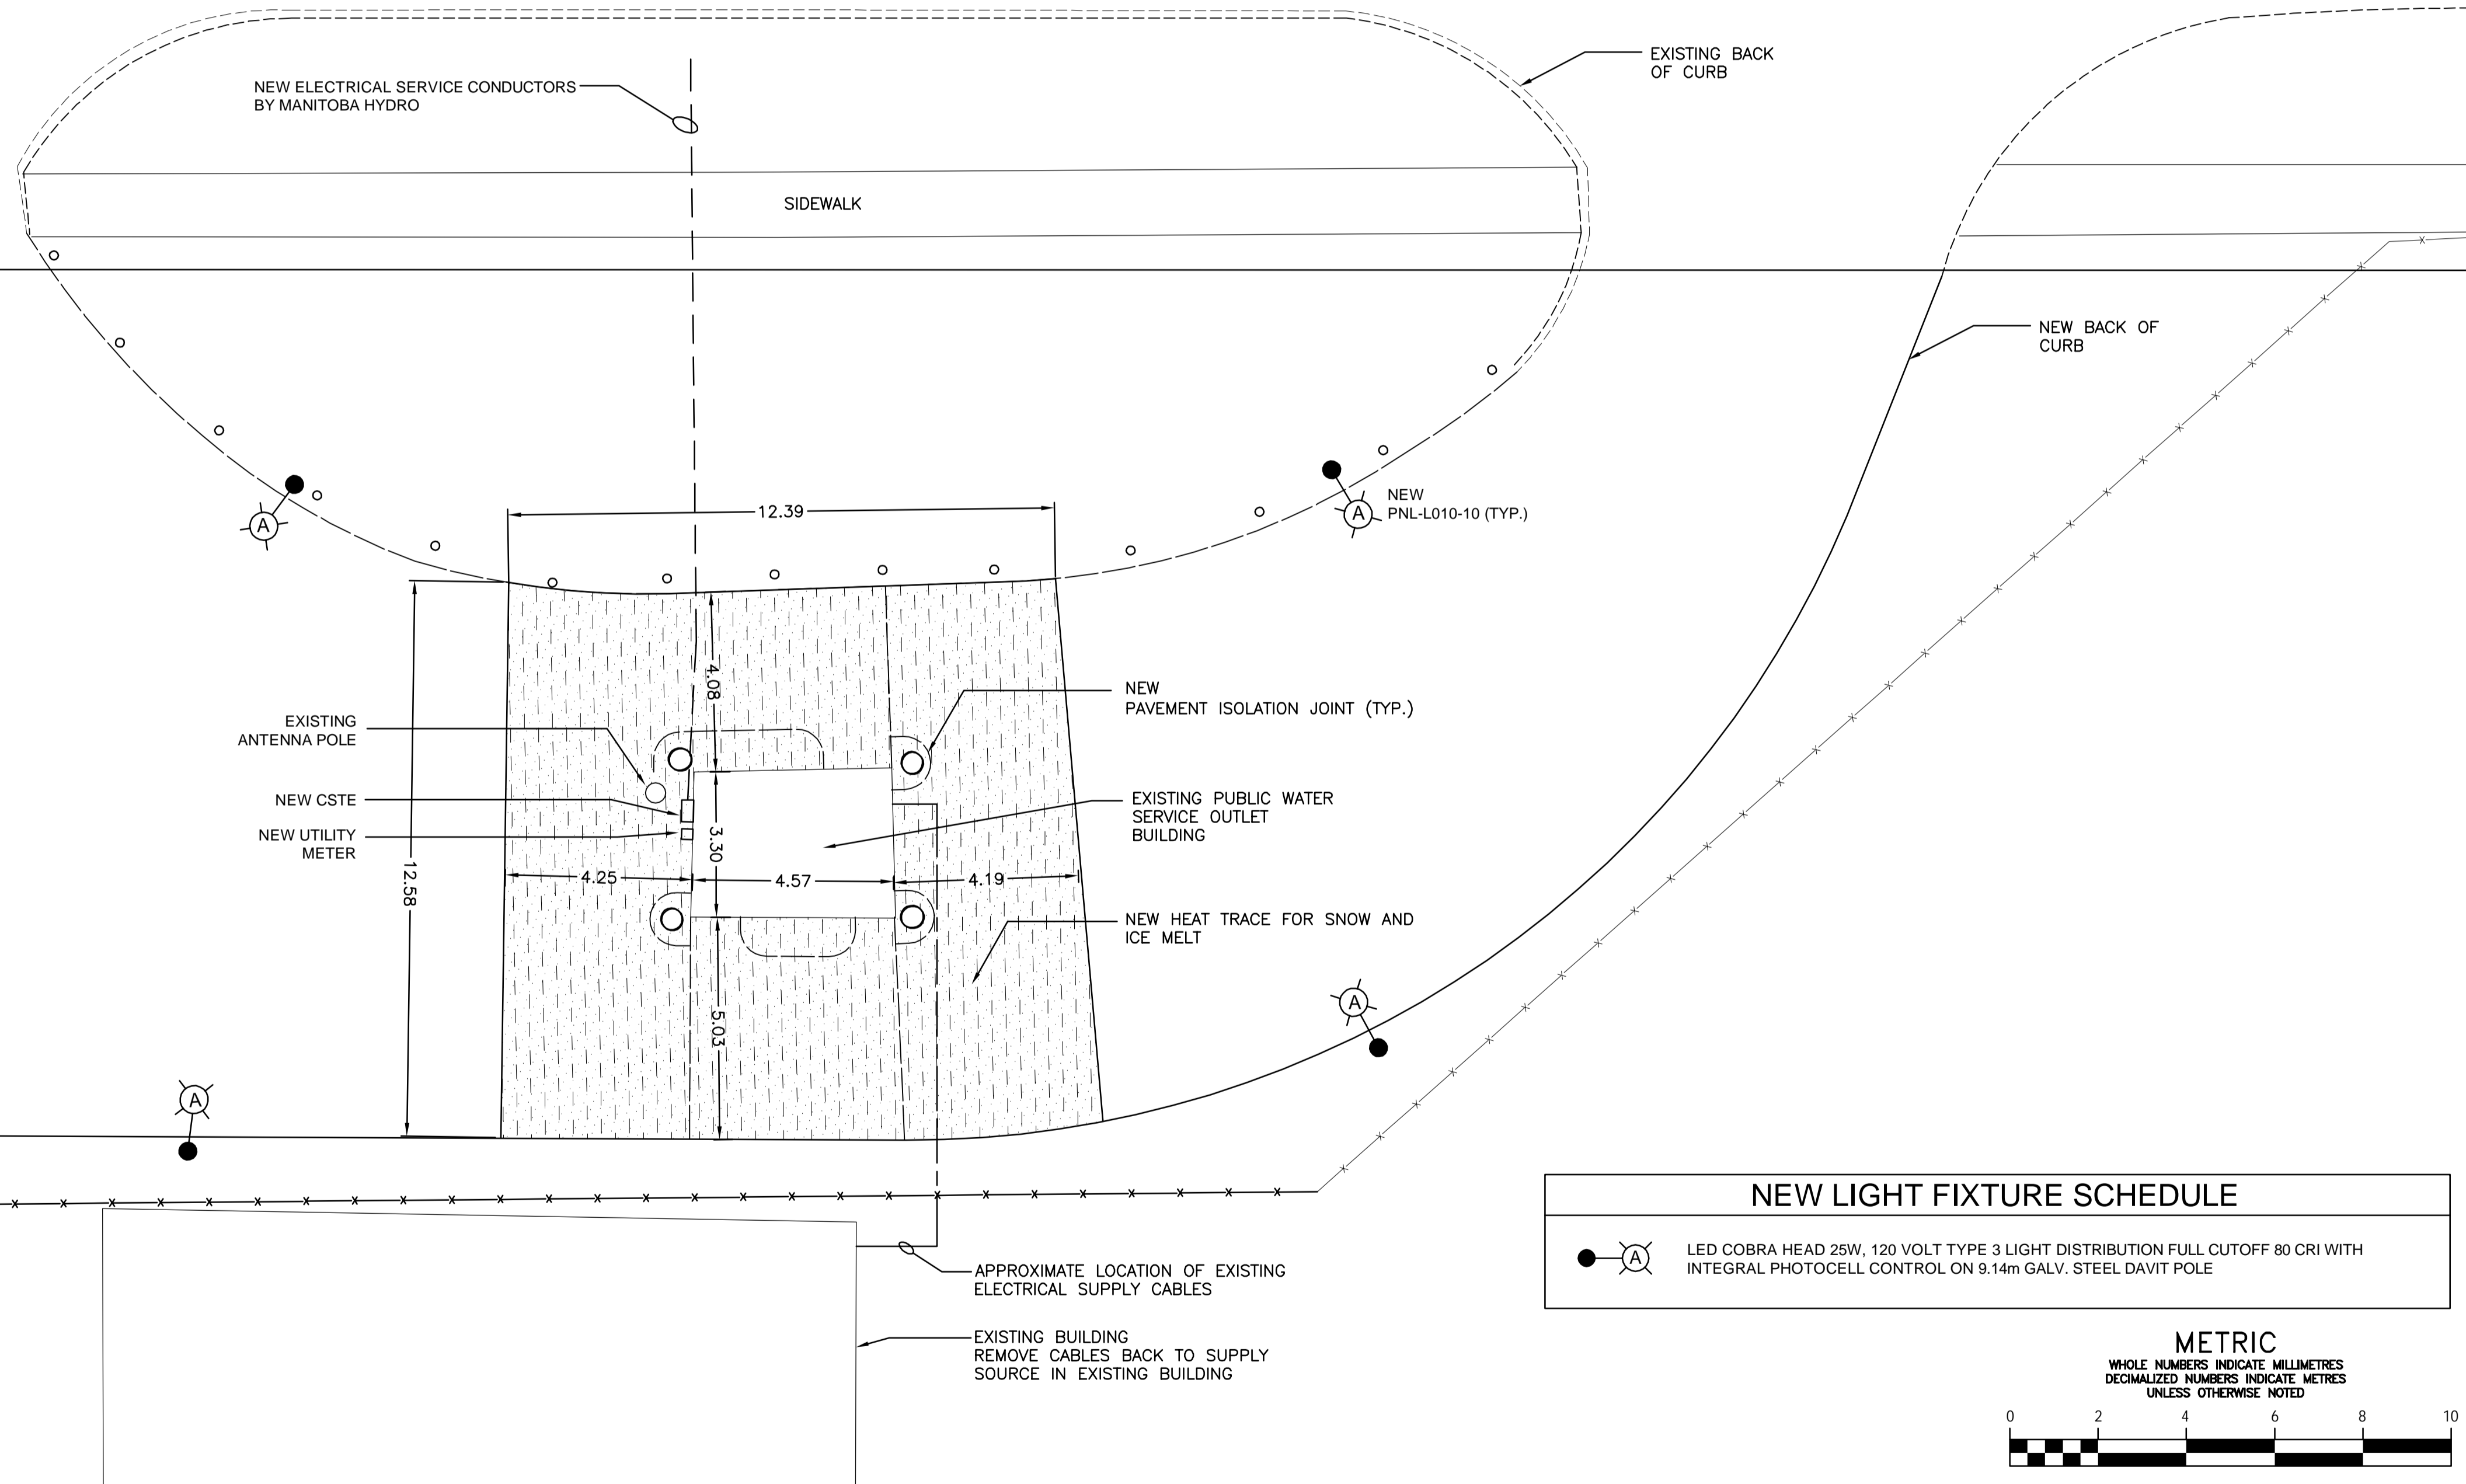

NEW LIGHT FIXTURE SCHEDULE	
	LED COBRA HEAD 25W, 120 VOLT TYPE 3 LIGHT DISTRIBUTION FULL CUTOFF 80 CRI WITH INTEGRAL PHOTOCELL CONTROL ON 9.14m GALV. STEEL DAVIT POLE

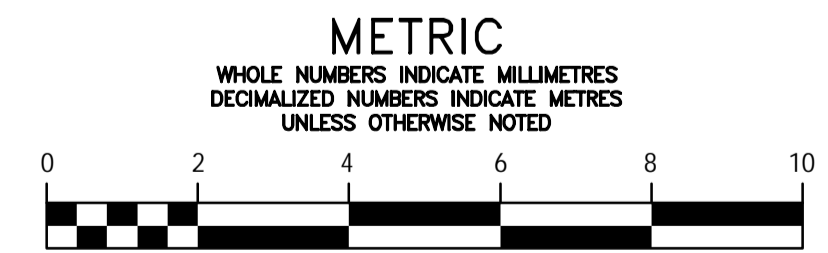

**LOCATION APPROVED UNDERGROUND STRUCTURES**

SUPV. U/G STRUCTURES COMMITTEE \_\_\_\_\_ DATE \_\_\_\_\_

NOTE:  
 LOCATION OF UNDERGROUND STRUCTURES AS SHOWN ARE BASED ON THE BEST INFORMATION AVAILABLE BUT NO GUARANTEE IS GIVEN THAT ALL EXISTING UTILITIES ARE SHOWN OR THAT THE GIVEN LOCATIONS ARE EXACT. CONFIRMATION OF EXISTENCE AND EXACT LOCATION OF ALL SERVICES MUST BE OBTAINED FROM THE INDIVIDUAL UTILITIES BEFORE PROCEEDING WITH CONSTRUCTION.

B.M. ELEV.	
CONSTRUCTION COMPLETION DATE: YYYY MM DD	
NO.	REVISIONS
1	ISSUED FOR BID OP 103-2019 04/15/19 B.L.M.
0	ISSUED FOR 90% REVIEW 03/07/19 C.A.L.

**DILLON CONSULTING**

DESIGNED BY: B.L.M. CHECKED BY: XX  
 DRAWN BY: S.C.K. APPROVED BY: XX

SCALE: HORIZONTAL AS SHOWN  
 VERTICAL \_\_\_\_\_

DATE: 2017 07 07  
 PLOT DATE: 2019 04 23

ENGINEER'S SEAL

CONSULTANT DRAWING NUMBER: E-01

**THE CITY OF WINNIPEG**  
 WATER AND WASTE DEPARTMENT  
 ENGINEERING DIVISION

2019 REHABILITATION OF PUBLIC WATER SERVICE OUTLET PAVEMENT WORKS, BUILDING REPAIRS, AND ELECTRICAL UPGRADES

**ELECTRICAL**  
 CHEVRIER BLVD - SITE PLAN

SHEET 5 OF 20  
 CITY DRAWING NUMBER  
 D-14911

FILENAME: C:\PROJECTS\WORKING DIRECTORY\ACTIVE\40CAL\0713849\175009-05-CHEVRIER-ELECT-SITE.DWG PLOTTED BY: LANGE, COLE  
 PLOT DATE: 2019-04-23 12:52:16 PM PLOT SCALE: 1:1 PLOT STYLE: FULL-COLOR.ctb