
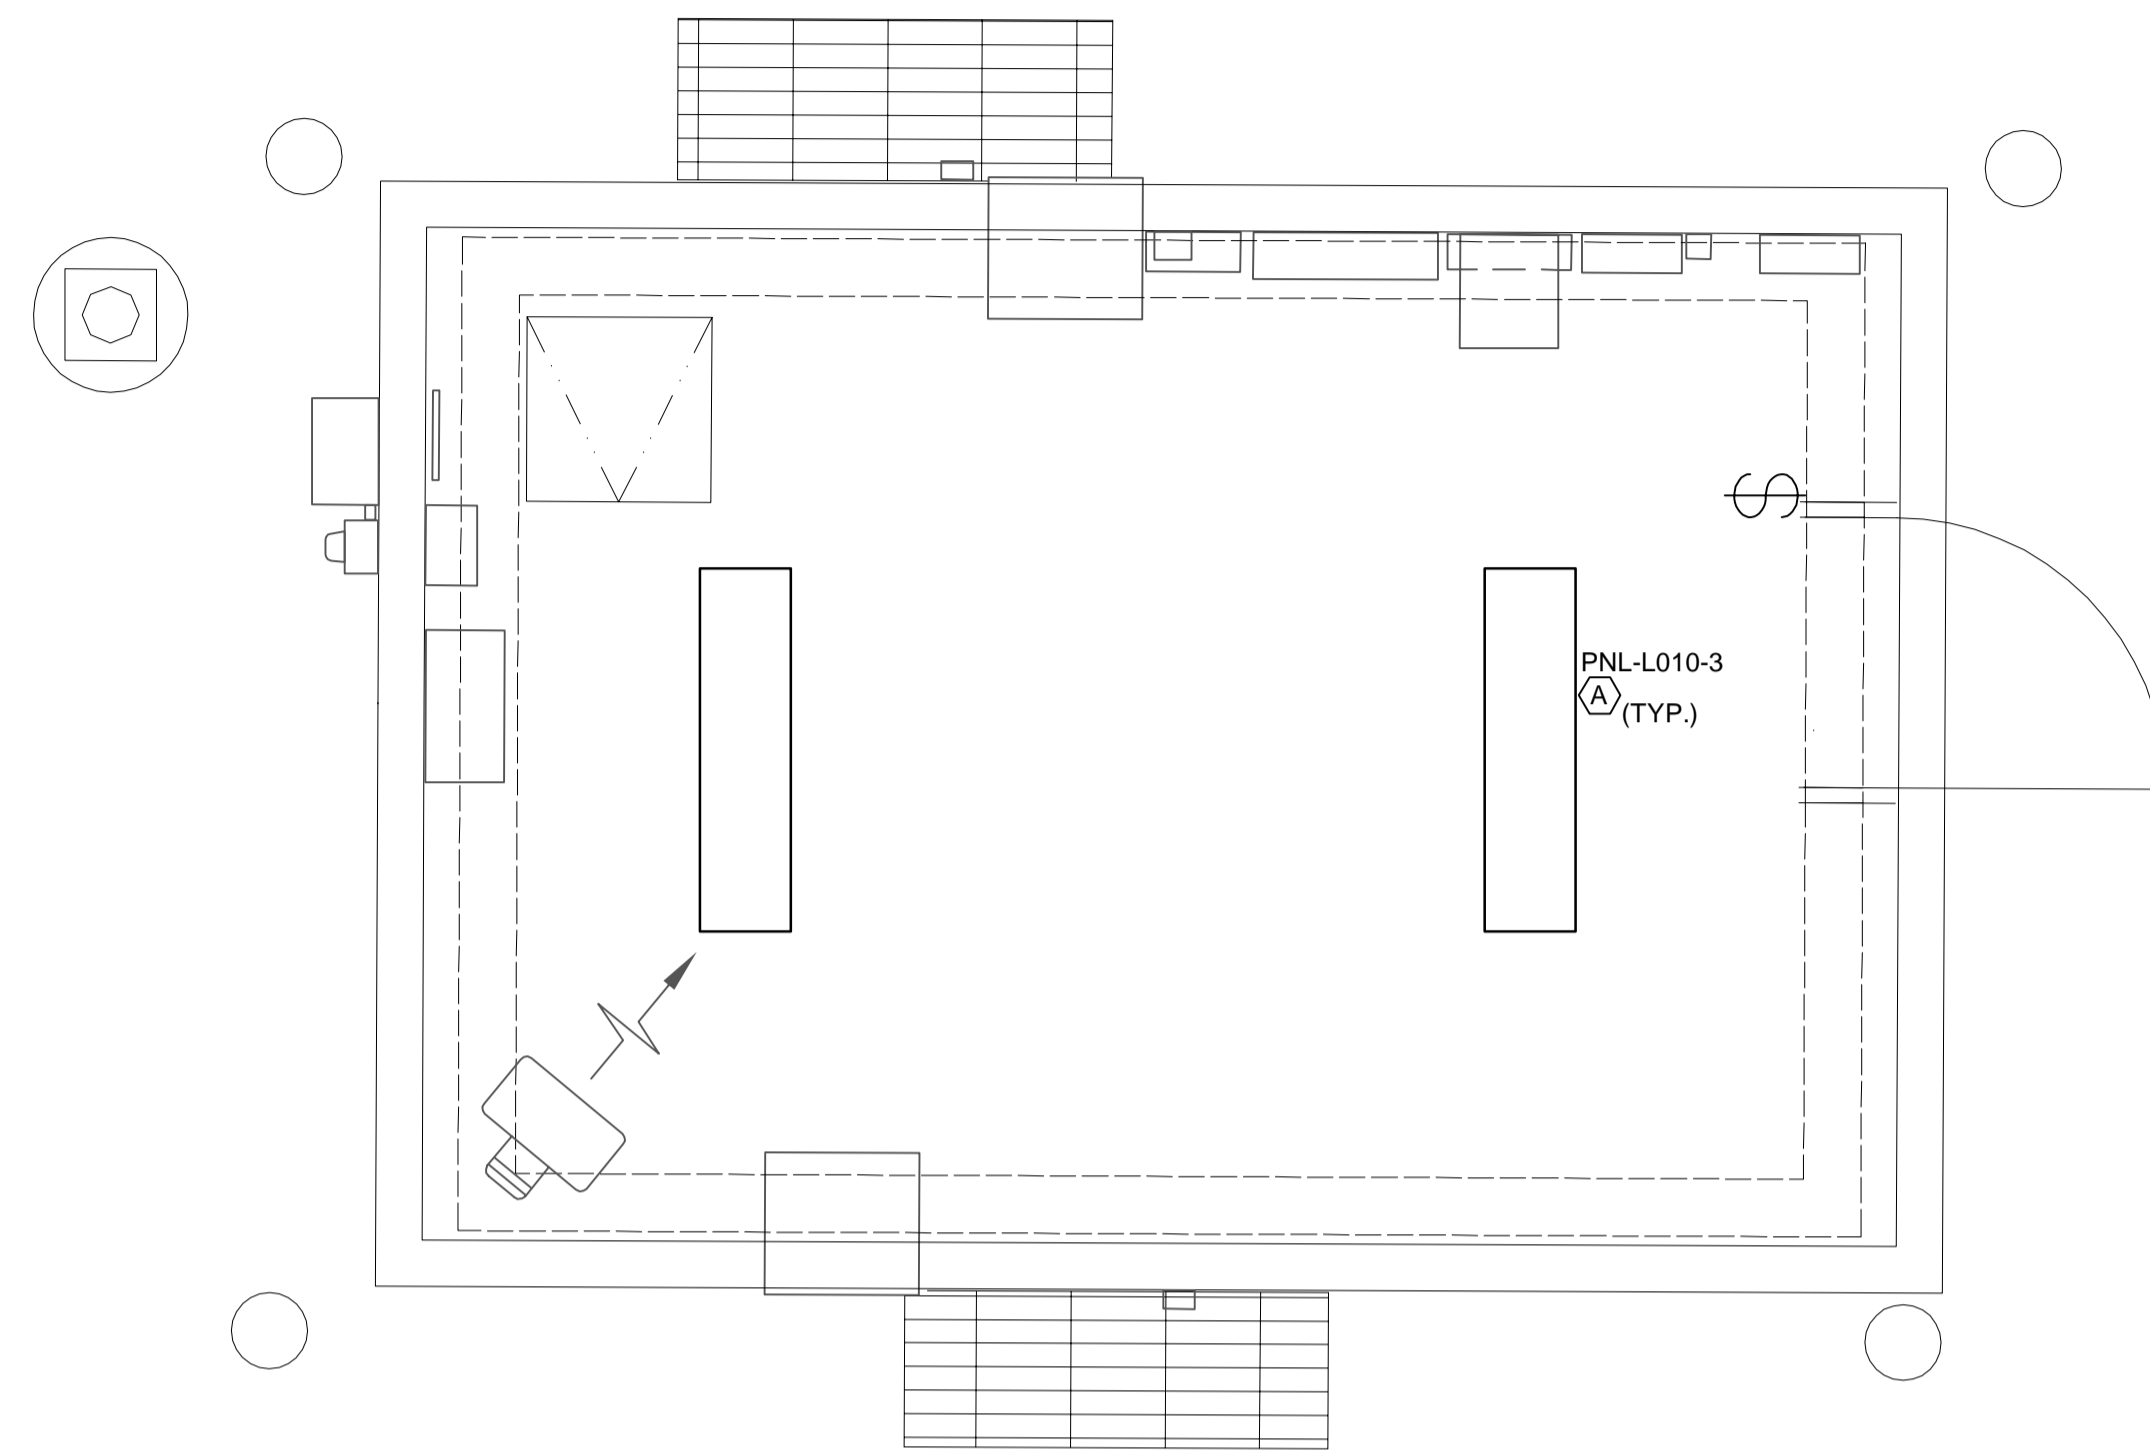


**NEW BUILDING INSTRUMENTATION PLAN**  
SCALE 1:25

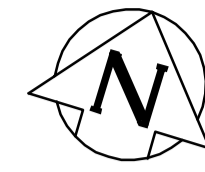

**NEW BUILDING LIGHTING FLOOR PLAN**  
SCALE 1:25

**LIGHT FIXTURE SCHEDULE**

TYPE	MODEL	MANUFACTURER	MANUFACTURER CAT. NO.	LAMP	WATTS	COLOR	REMARKS
A	COOPER-METALUX, VAPOUR TIGHT	COOPER LIGHTING	4VT2-LD4-4-DR-UNV-L835-WL-SSL	LED	38W	4000	CORROSION RESISTANT

FILENAME: C:\PROJECTS\WORKING DIRECTORY\ACTIVE\400A\0713845\175009-06B-SHT-CHEV-LTG.DWG PLOTTED BY: LANGE, COLE  
 PLOT DATE: 2019-04-23 @ 12:52:22 PM PLOT SCALE: 1:1 PLOT STYLE: FULL-COLOR.ctb



**LOCATION APPROVED UNDERGROUND STRUCTURES**

SUPV. U/G STRUCTURES COMMITTEE \_\_\_\_\_ DATE \_\_\_\_\_

NOTE:  
LOCATION OF UNDERGROUND STRUCTURES AS SHOWN ARE BASED ON THE BEST INFORMATION AVAILABLE BUT NO GUARANTEE IS GIVEN THAT ALL EXISTING UTILITIES ARE SHOWN OR THAT THE GIVEN LOCATIONS ARE EXACT. CONFIRMATION OF EXISTENCE AND EXACT LOCATION OF ALL SERVICES MUST BE OBTAINED FROM THE INDIVIDUAL UTILITIES BEFORE PROCEEDING WITH CONSTRUCTION.

NO.	REVISIONS	DATE	BY
1	ISSUED FOR BID OP 103-2019	04/15/19	B.L.M.
0	ISSUED FOR 90% REVIEW	03/07/19	C.A.L.

**DILLON CONSULTING**

DESIGNED BY: B.L.M. CHECKED BY: XX  
 DRAWN BY: S.C.K. APPROVED BY: XX

SCALE: AS SHOWN  
 HORIZONTAL: \_\_\_\_\_  
 VERTICAL: \_\_\_\_\_

DATE: 2017 07 07  
 PLOT DATE: 2019 04 23

ENGINEER'S SEAL

CONSULTANT DRAWING NUMBER: E-03

**THE CITY OF WINNIPEG**  
 WATER AND WASTE DEPARTMENT  
 ENGINEERING DIVISION

2019 REHABILITATION OF PUBLIC WATER SERVICE  
 OUTLET PAVEMENT WORKS, BUILDING REPAIRS,  
 AND ELECTRICAL UPGRADES  
 ELECTRICAL - CHEVRIER BLVD.  
 BUILDING - LIGHTING &  
 INSTRUMENTATION

SHEET 7 OF 20  
 CITY DRAWING NUMBER: D-14913