



SITE PLAN

Scale 1:1500
 0 37.5 75
 1:1500 m

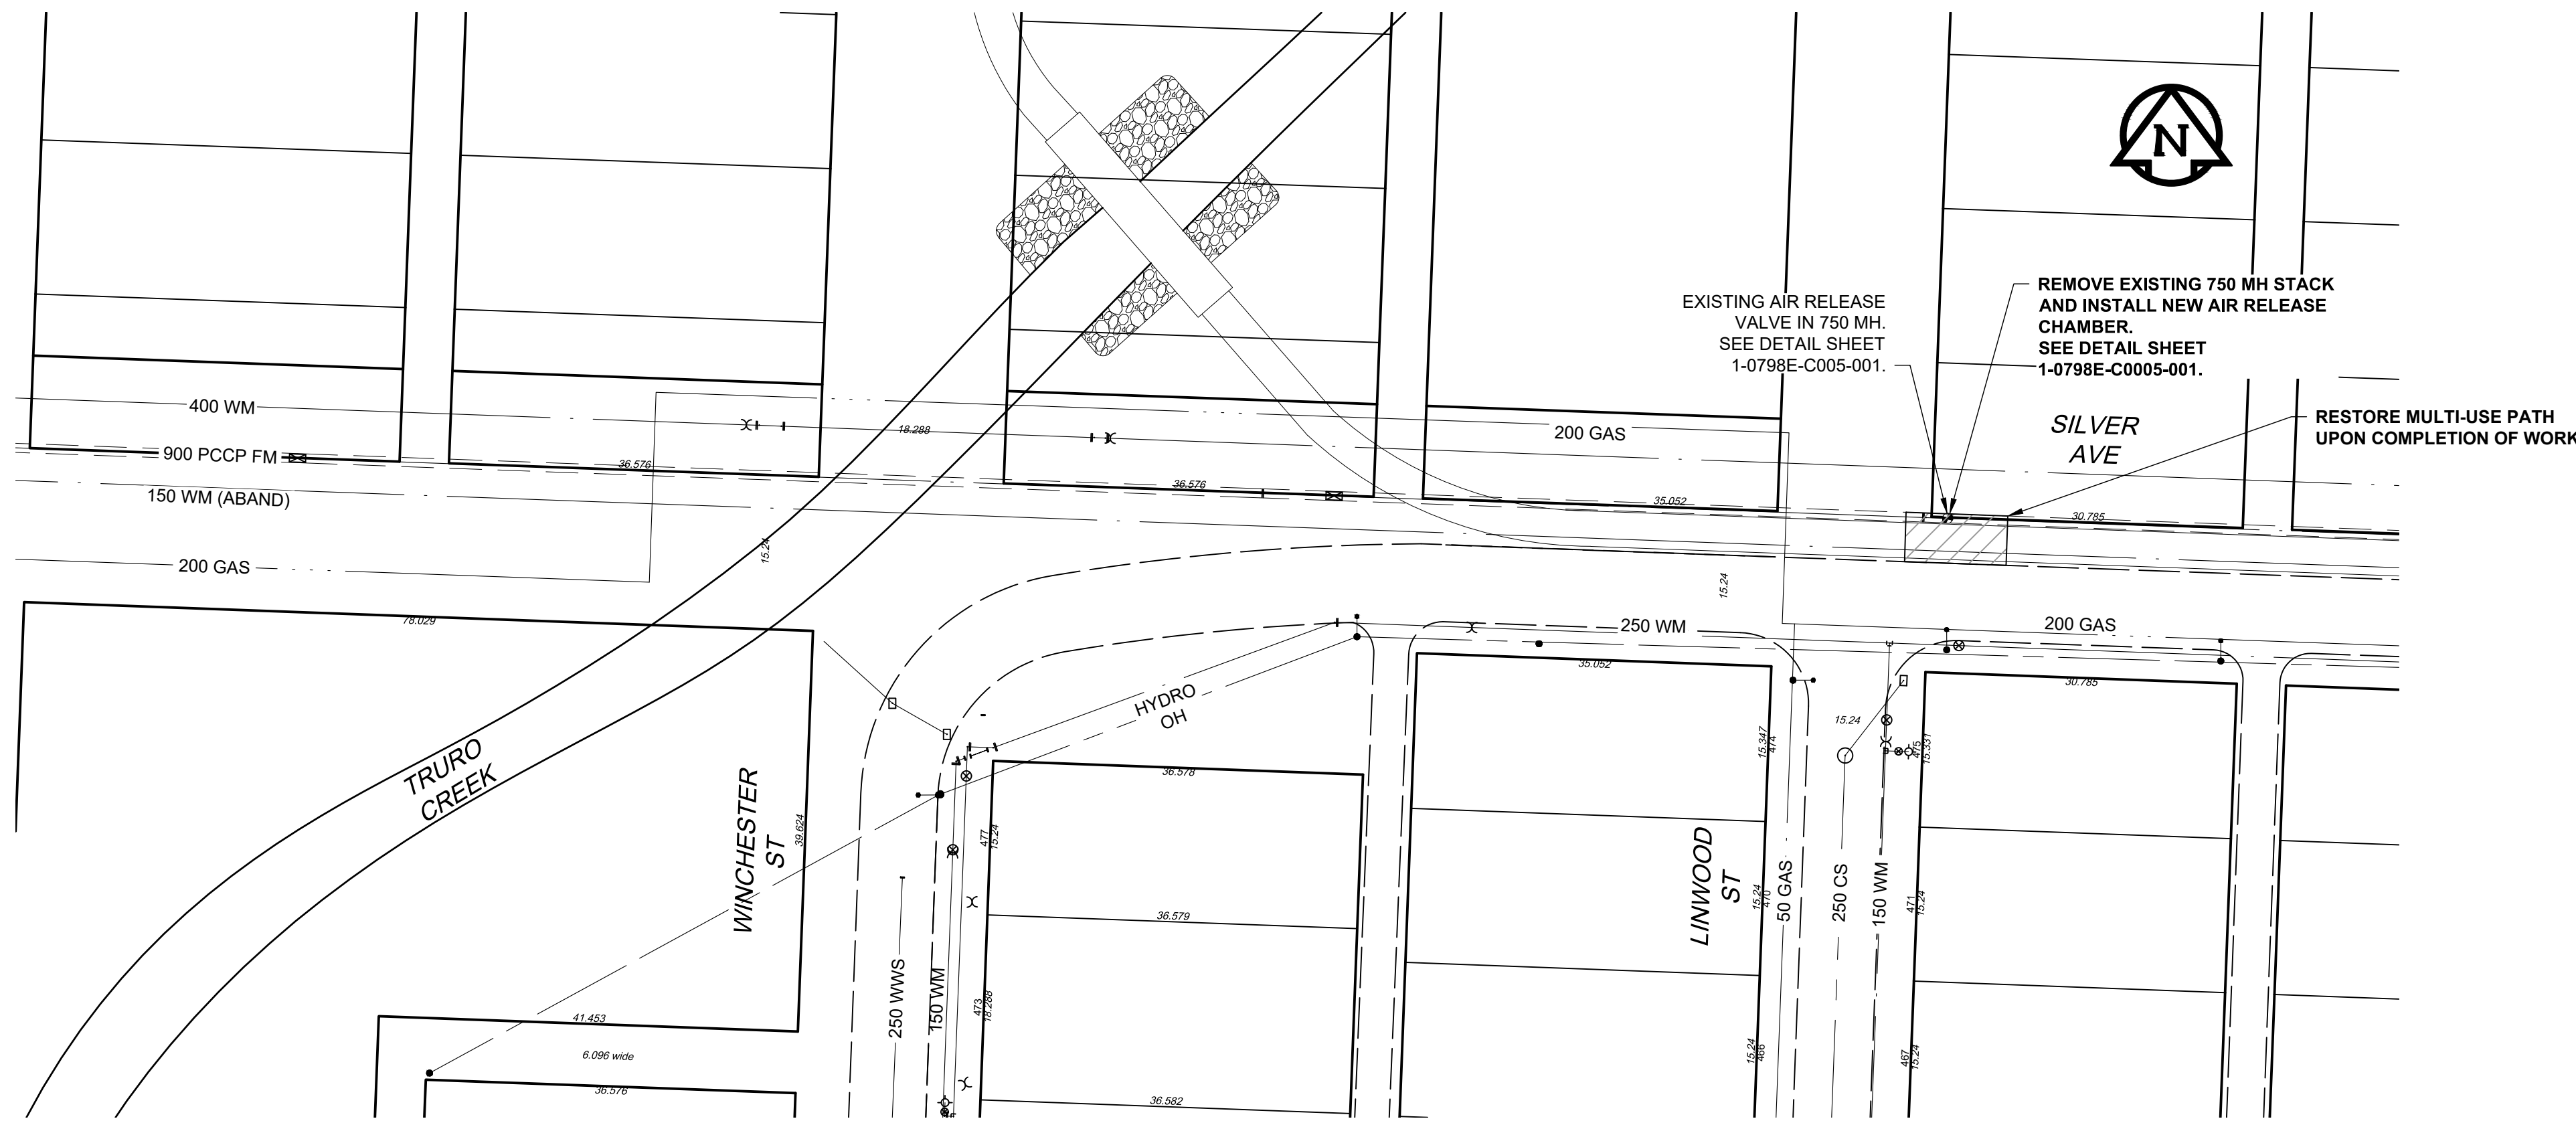

PLAN

Scale 1:500
 0 12.5 25
 m

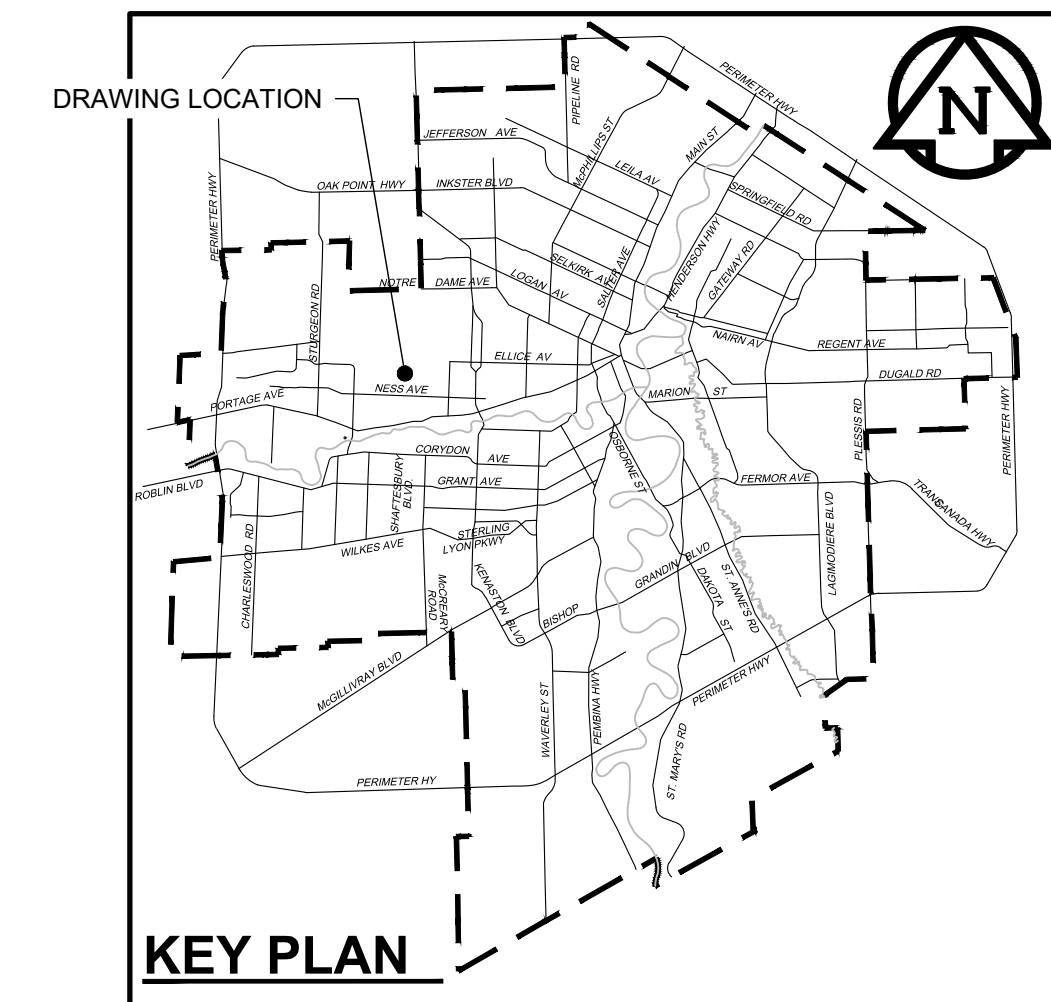

KEY PLAN

**ENGINEERS
 GEOSCIENTISTS
 MANITOBA**
 Certificate of Authorization
 AECOM Canada Ltd.
 No. 4671 Date: June 21, 2022

METRIC
 WHOLE NUMBERS INDICATE MILLIMETRES
 DECIMALIZED NUMBERS INDICATE METRES

WARNING
 IF POWER EQUIPMENT OR EXPLOSIVES ARE TO BE USED FOR EXCAVATION ON THIS PROJECT THE CONTRACTOR MUST:
 1) NOTIFY THE GAS COMPANY OF THE PROPOSED LOCATION OF EXCAVATION.
 2) TAKE PRECAUTION TO AVOID DAMAGE TO GAS COMPANY INSTALLATIONS.
 SEE PROVINCIAL REGULATION 210/72 FOR DETAILS

**LOCATION APPROVED
 UNDERGROUND STRUCTURES**
 SUPV. U/G STRUCTURES COMMITTEE DATE
 NOTE:
 LOCATION OF UNDERGROUND STRUCTURES AS SHOWN ARE BASED ON THE BEST INFORMATION AVAILABLE BUT NO GUARANTEE IS GIVEN THAT ALL EXISTING UTILITIES ARE SHOWN OR THAT THE GIVEN LOCATIONS ARE EXACT. CONFIRMATION OF EXISTENCE AND EXACT LOCATION OF ALL SERVICES MUST BE OBTAINED FROM THE INDIVIDUAL UTILITIES BEFORE PROCEEDING WITH CONSTRUCTION.

B.M. 84R505 N.W. Cor. Saskatchewan Ave. & Midland St., Tbt. on top of 0.05 m dia. x 1.2 m iron pipe 10.2 m S. of N.L. of Saskatchewan Ave. & 5.6 m. E. of W.L. of Midland St.
 CONSTRUCTION COMPLETION DATE: YYYY MM DD

NO.	ISSUED FOR TENDER	22/06/15	ADL
NO.	REVISIONS	DATE	BY

AECOM

DESIGNED BY	TJB	CHECKED BY	MGM
DRAWN BY	ADL	APPROVED BY	KWF
SCALE:	HORIZONTAL AS NOTED		
VERTICAL	N/A		
DATE	2022 06 21	DATE	Jun 21/22
RELEASED FOR CONSTRUCTION		Paul Bortoluzzi	

ENGINEER'S SEAL
 ORIGINAL SIGNED BY J. Thompson
 June 21, 2022
 CONSULTANT DRAWING NUMBER C-1007

THE CITY OF WINNIPEG
 WATER AND WASTE DEPARTMENT
 ENGINEERING DIVISION

PROVISION OF PIPELINE ACCESS MODIFICATIONS, CLEANING AND SUPPORT SERVICES FOR RIVER CROSSING INSPECTIONS - PHASE THREE
SITE 9
WEST END FEEDER MAIN (at TRURO CREEK)

SHEET 08 OF 11
 CITY DRAWING NUMBER 1-0798E-C0004-001