


1 MAIN FLOOR - DEMOLITION PLAN
 A1.1 SCALE: 1/8"=1'-0"

DEMOLITION NOTES

- ① REMOVE / LOOSEN EXISTING RADIATORS FOR EXISTING CARPET REMOVAL AND REPLACEMENT AS REQUIRED. CONTRACTOR TO REINSTALL.
- ② REMOVE EXISTING CARPET TILE AND RUBBER/CARPET BASE FROM AREAS NOTED ON DRAWING. PATCH & REPAIR FLOOR TO MAKE READY FOR NEW CARPET TILE.
- ③ REMOVE RUBBER BASE ON COLUMNS WHERE EXISTING PATCH & REPAIR COLUMNS WHERE REQUIRED TO MAKE READY FOR NEW RUBBER BASE.
- ④ EXISTING RUBBER FLOORING TO REMAIN. MAINTAIN EXISTING TRANSITION STRIP IF FEASIBLE.
- ⑤ EXISTING CERAMIC TILE TO REMAIN. MAINTAIN EXISTING TRANSITION STRIP IF FEASIBLE.
- ⑥ EXISTING CARPET TO REMAIN. CONTRACTOR TO REPAIR/REPLACE ANY AREAS/DAMAGED DURING DEMOLITION OR INSTALL OF NEW CARPET.
- ⑦ EXISTING VINYL TILE TO REMAIN. MAINTAIN EXISTING TRANSITION STRIP IF FEASIBLE.
- ⑧ EXISTING SHEET VINYL TO REMAIN. MAINTAIN EXISTING TRANSITION STRIP IF FEASIBLE.
- ⑨ EXISTING METAL BASE TO REMAIN.

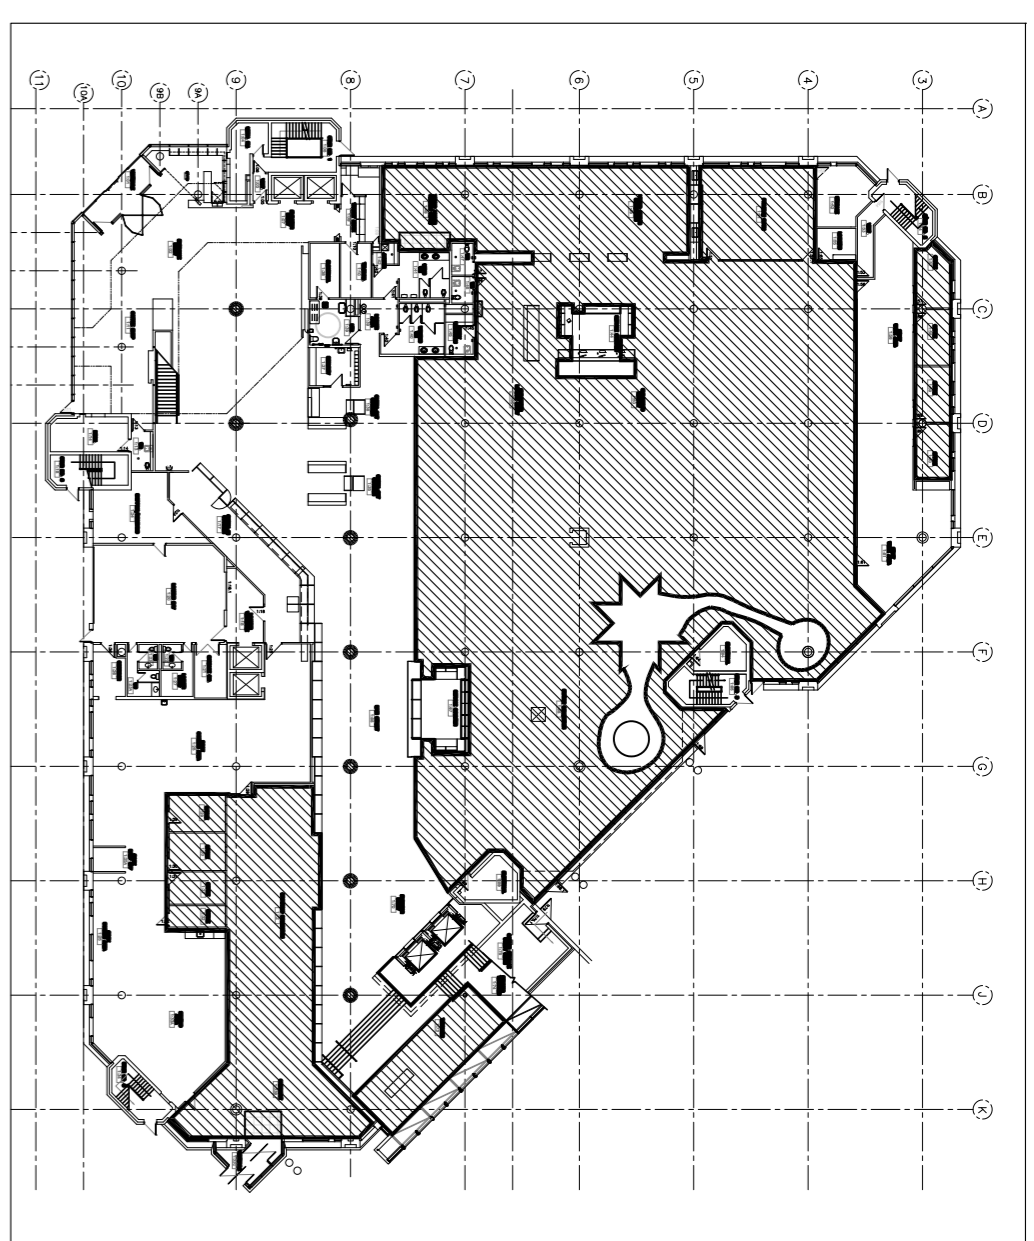

KEY PLAN
 SCALE: N.T.S.

DEMOLITION DRAWING LEGEND

- EXISTING DOORS
- EXISTING DOOR TO BE REMOVED
- EXISTING WALLS
- DEMOLITION DRAWING NOTE
- ① DENOTES AREA NOT IN CONTRACT/ EXISTING FLOORING TO REMAIN
- N.I.C.

NOTES :

THESE DRAWINGS SHALL NOT BE SCALED.
 THE CONTRACTOR SHALL VISIT THE SITE AND VERIFY ALL DIMENSIONAL DATA AND DETAILED INFORMATION SHOWN ARE CORRECT.
 THE CONTRACTOR IS TO REVIEW AND COORDINATE ALL ARCHITECTURAL, MECHANICAL, ELECTRICAL AND STRUCTURAL DRAWINGS FOR ADDITIONAL OPENINGS THROUGH FLOORS, WALLS AND CEILING/ROOF. PREPARE ELECTRICAL RISERS AND ALL OPENINGS NOT SHOWN ON DRAWINGS.
 ALL OPENINGS THROUGH FIRE ASSEMBLIES ARE TO BE STOPPED AND SEALED WITH U.L.C. APPROVED FIRE STOPPING TO MAINTAIN THE INTEGRITY OF THE FIRE SEPARATION, AND PROVIDE A SMOKE-TIGHT BARRIER.
 ALL PRODUCTS AND MATERIALS TO BE USED AND INSTALLED SHALL CONFORM WITH MANUFACTURER'S SPECIFICATIONS & APPLICABLE CODES.
 THE CONTRACTOR SHALL BE RESPONSIBLE FOR PATCH AND MAKE GOOD ALL EXISTING CONSTRUCTION DEFECTS BY THE REMOVAL OF ALL ITEMS FORMING THE PART OF THE RENOVATION WORK.
 WHERE NEW FLOORING AND BASE IS TO BE INSTALLED IN EXISTING AREAS REFER TO FLOOR PLAN AND ROOM SCHEDULE. THE EXISTING FLOORING SURFACE AND BASE MUST BE REMOVED UNLESS OTHERWISE NOTED. ALL FLOOR SURFACES SHALL BE PREPARED IN ACCORDANCE TO MANUFACTURER'S RECOMMENDATIONS FOR INSTALLATION OF NEW FLOOR.
 WHERE REMAINING OF EXISTING WALLS IS INDICATED ON THE ROOM SCHEDULE, THESE WALLS MUST BE CLEANED OF ANY EXISTING WALL COVERING, PATCHES & REPAIRED TO ACCEPT NEW MATERIAL, UNLESS OTHERWISE NOTED.

NO.	REVISION/DESCRIPTION	BY	DATE
0	ISSUED FOR CONSTRUCTION	CEA	02.18.2022
0	ISSUED FOR FINAL CLIENT APPROVAL	CEA	11.04.2021
0	ISSUED FOR CLIENT REVIEW	CEA	10.29.2021

SEALS

DRAWN BY	CHECKED BY	APPROVED
SPCEA	USER APPROVAL	

DATE: 2021.11.03

CITY OF WINNIPEG
 ASSETS & PROJECT MANAGEMENT DEPARTMENT
 MUNICIPAL ACCOMMODATIONS DIVISION
 4th FLOOR, 185 WILKINS ST., WINNIPEG, MANITOBA R3B 1J1

PROJECT
 TENDER NO. 139-2022
 INTERIOR RENOVATIONS FOR
 MILLENNIUM LIBRARY
 251 DONALD STREET

SHEET TITLE
 MAIN FLOOR
 DEMOLITION PLAN AND NOTES

SCALE PROJECT NO. SHEET NO.
 AS SHOWN 2021-059 A1.1

DRAWING SHEET SIZE: A1 (841mm x 594mm) PLOT 1:1