


CONTAINMENT PLAN
SCALE: 1: 75

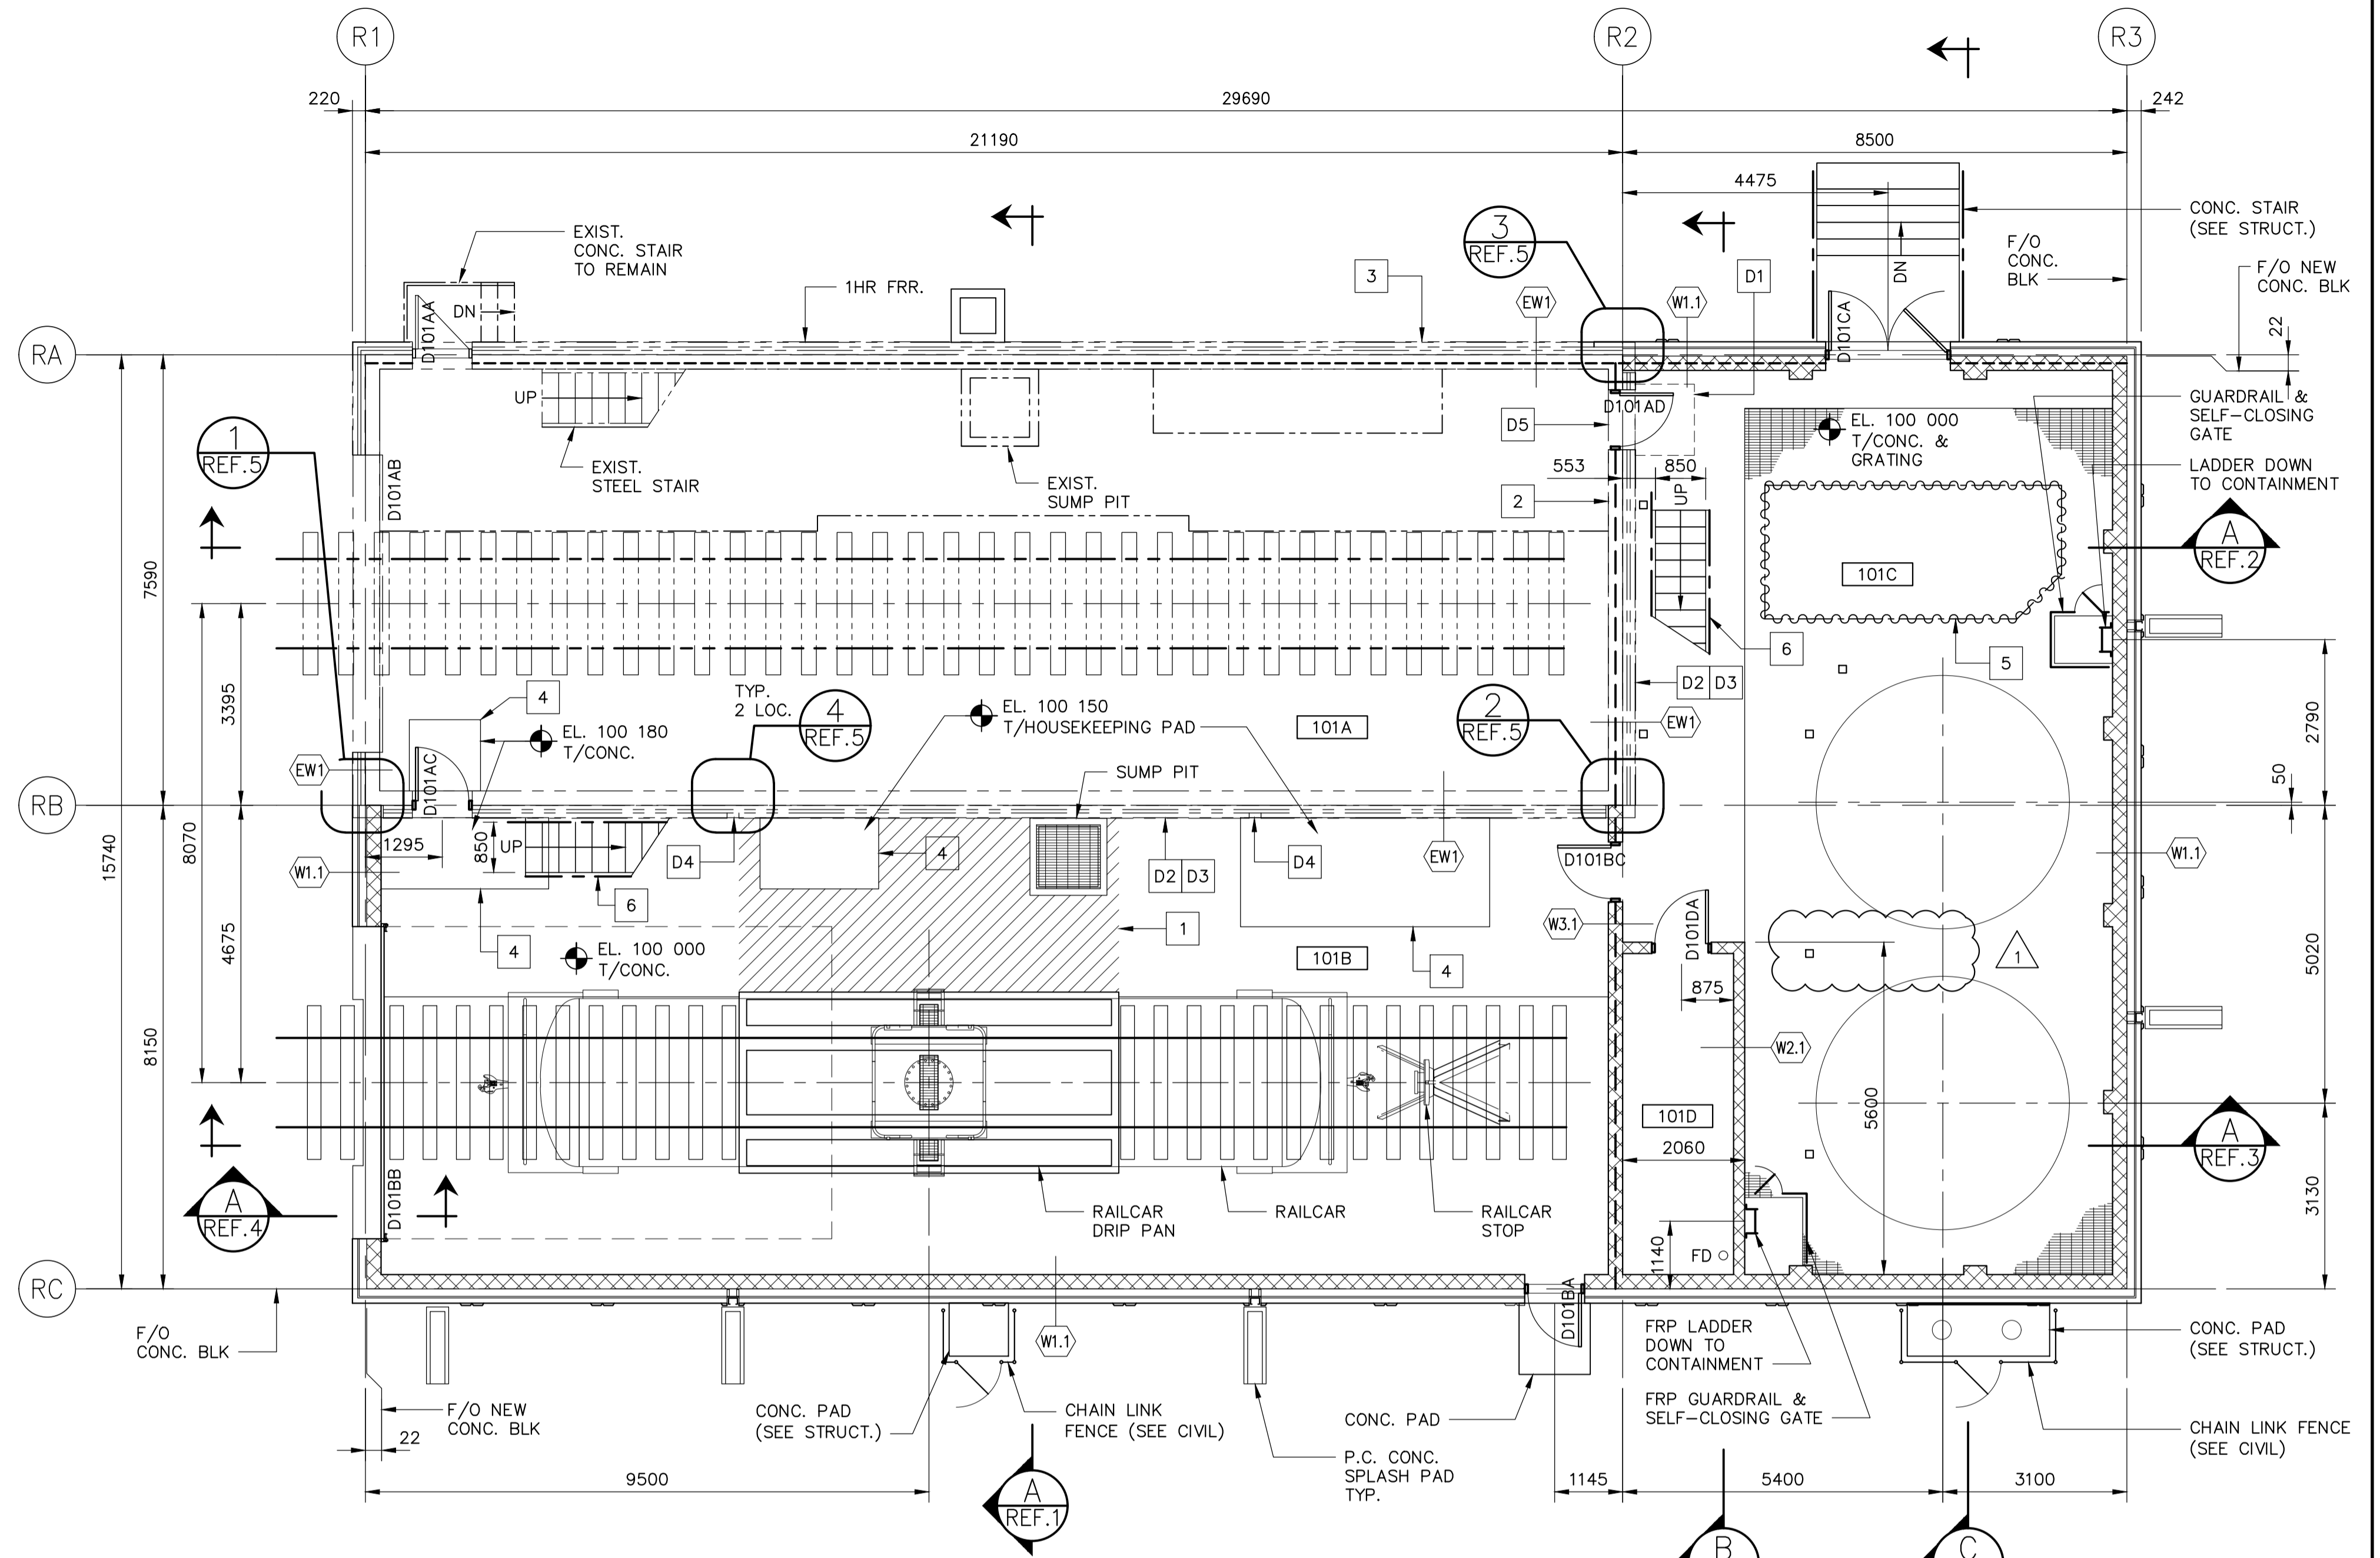


MAIN FLOOR PLAN
SCALE: 1: 75

DEMOLITION KEYNOTES:

- D1 DEMOLISH EXIST. CONC. SLAB, GUARDRAIL AND SHOE SCRAPER.
- D2 REMOVE ALL EXIST. ACRYLIC STUCCO & INSUL. BANDING FROM BRICK ON GRID LINES 'RB' & 'R2' ONLY.
- D3 REMOVE ALL EXIST. INSUL. & FLASHING ON GRADE BEAM ON GRID LINES 'RB' & 'R2' ONLY.
- D4 REMOVE EXIST. RWL (2 LOC.).
- D5 REMOVE EXIST. DOOR & FRAME. REPLACE W/ NEW FIRE RATED DOOR (SEE DOOR SCHEDULE).

KEYNOTES:

- 1 PAINT CONC. WITH CHEMICAL RESISTANT COATING TO MATCH EXIST. PAINTED CONC. IN EXIST. RAILCAR SHELTER. NEW COATING LIMITS SHOWN AS HATCHED AREA (±15sq.m.).
- 2 REMOVE EXIST. HVAC LOUVER IN WALL AND INFILL TO MATCH EXIST (SEE MECH.).
- 3 NEW HVAC LOUVER OPENING IN EXIST. WALL (SEE MECH. & STRUCT.).
- 4 PAINT EDGE OF CONC. SAFETY YELLOW. 50mm HORIZ. TOP OF CONC. & ENTIRE VERT. SURFACE, ALL AROUND.
- 5 CHEMICAL SAFE CURTAINS ON TRACK FASTENED TO STRUCT. ABOVE. PROVIDE SUPPORT FRAMING AS REQ'D.
- 6 STEEL STAIR C/W HANDRAIL ON BOTH SIDES (SEE STRUCT.).

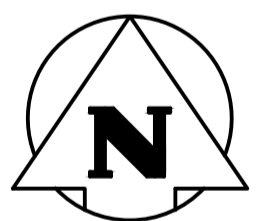

| | | |
|--------------------|----------------------|-------------------------|
| 10 | | |
| 9 | | |
| 8 | | |
| 7 | | |
| 6 | | |
| 5 | 1-0101-BDTL-F302-002 | SECTIONS & DETAILS |
| 4 | 1-0101-BDTL-F202-001 | SECTIONS & DETAILS |
| 3 | 1-0101-BGAD-F211-003 | BUILDING SECTIONS |
| 2 | 1-0101-BGAD-F211-002 | BUILDING SECTIONS |
| 1 | 1-0101-BGAD-F211-001 | BUILDING SECTIONS |
| NO. | DRAWING NUMBER | REFERENCE DRAWING TITLE |
| REFERENCE DRAWINGS | | |



| | |
|--|----------------|
| B.M. ELEV. | |
| CONSTRUCTION COMPLETION DATE: YYYY MM DD | |
| DESIGNED BY | SNH |
| CHECKED BY | JMW |
| DRAWN BY | SNH |
| APPROVED BY | JMW |
| SCALE: | 1: 75 |
| RELEASED FOR CONSTRUCTION | |
| 1 RE-ISSUED FOR CONSTRUCTION | 2022 06 17 JMW |
| 0 ISSUED FOR CONSTRUCTION | 2022 05 18 JMW |
| NO. | REVISIONS |
| DATE | BY |
| DATE | 2022 02 23 |
| DATE | |

KGS GROUP

ENGINEER'S SEAL

CONSULTANT DRAWING NUMBER: 21-0107-015_B2.101

| | |
|------------------|----------|
| BID OPPORTUNITY: | 197-2022 |
| CONTRACT NUMBER: | |

THE CITY OF WINNIPEG
WATER AND WASTE DEPARTMENT
ENGINEERING DIVISION

Winnipeg

NORTH END SEWAGE TREATMENT PLANT (NEWPC)
INTERIM PHOSPHOROUS REMOVAL
AREA F - CHEMICAL RECEIVING AND STORAGE FACILITY
CONTAINMENT & MAIN FLOOR PLANS
BUILDING 101

CITY DRAWING NUMBER: 1-0101-BGAD-F202-001

SHEET 1 OF 1