




GENERAL NOTES:
 1. THE CONTRACTOR TO VERIFY THE PROPER LOCATION OF THE UPS.

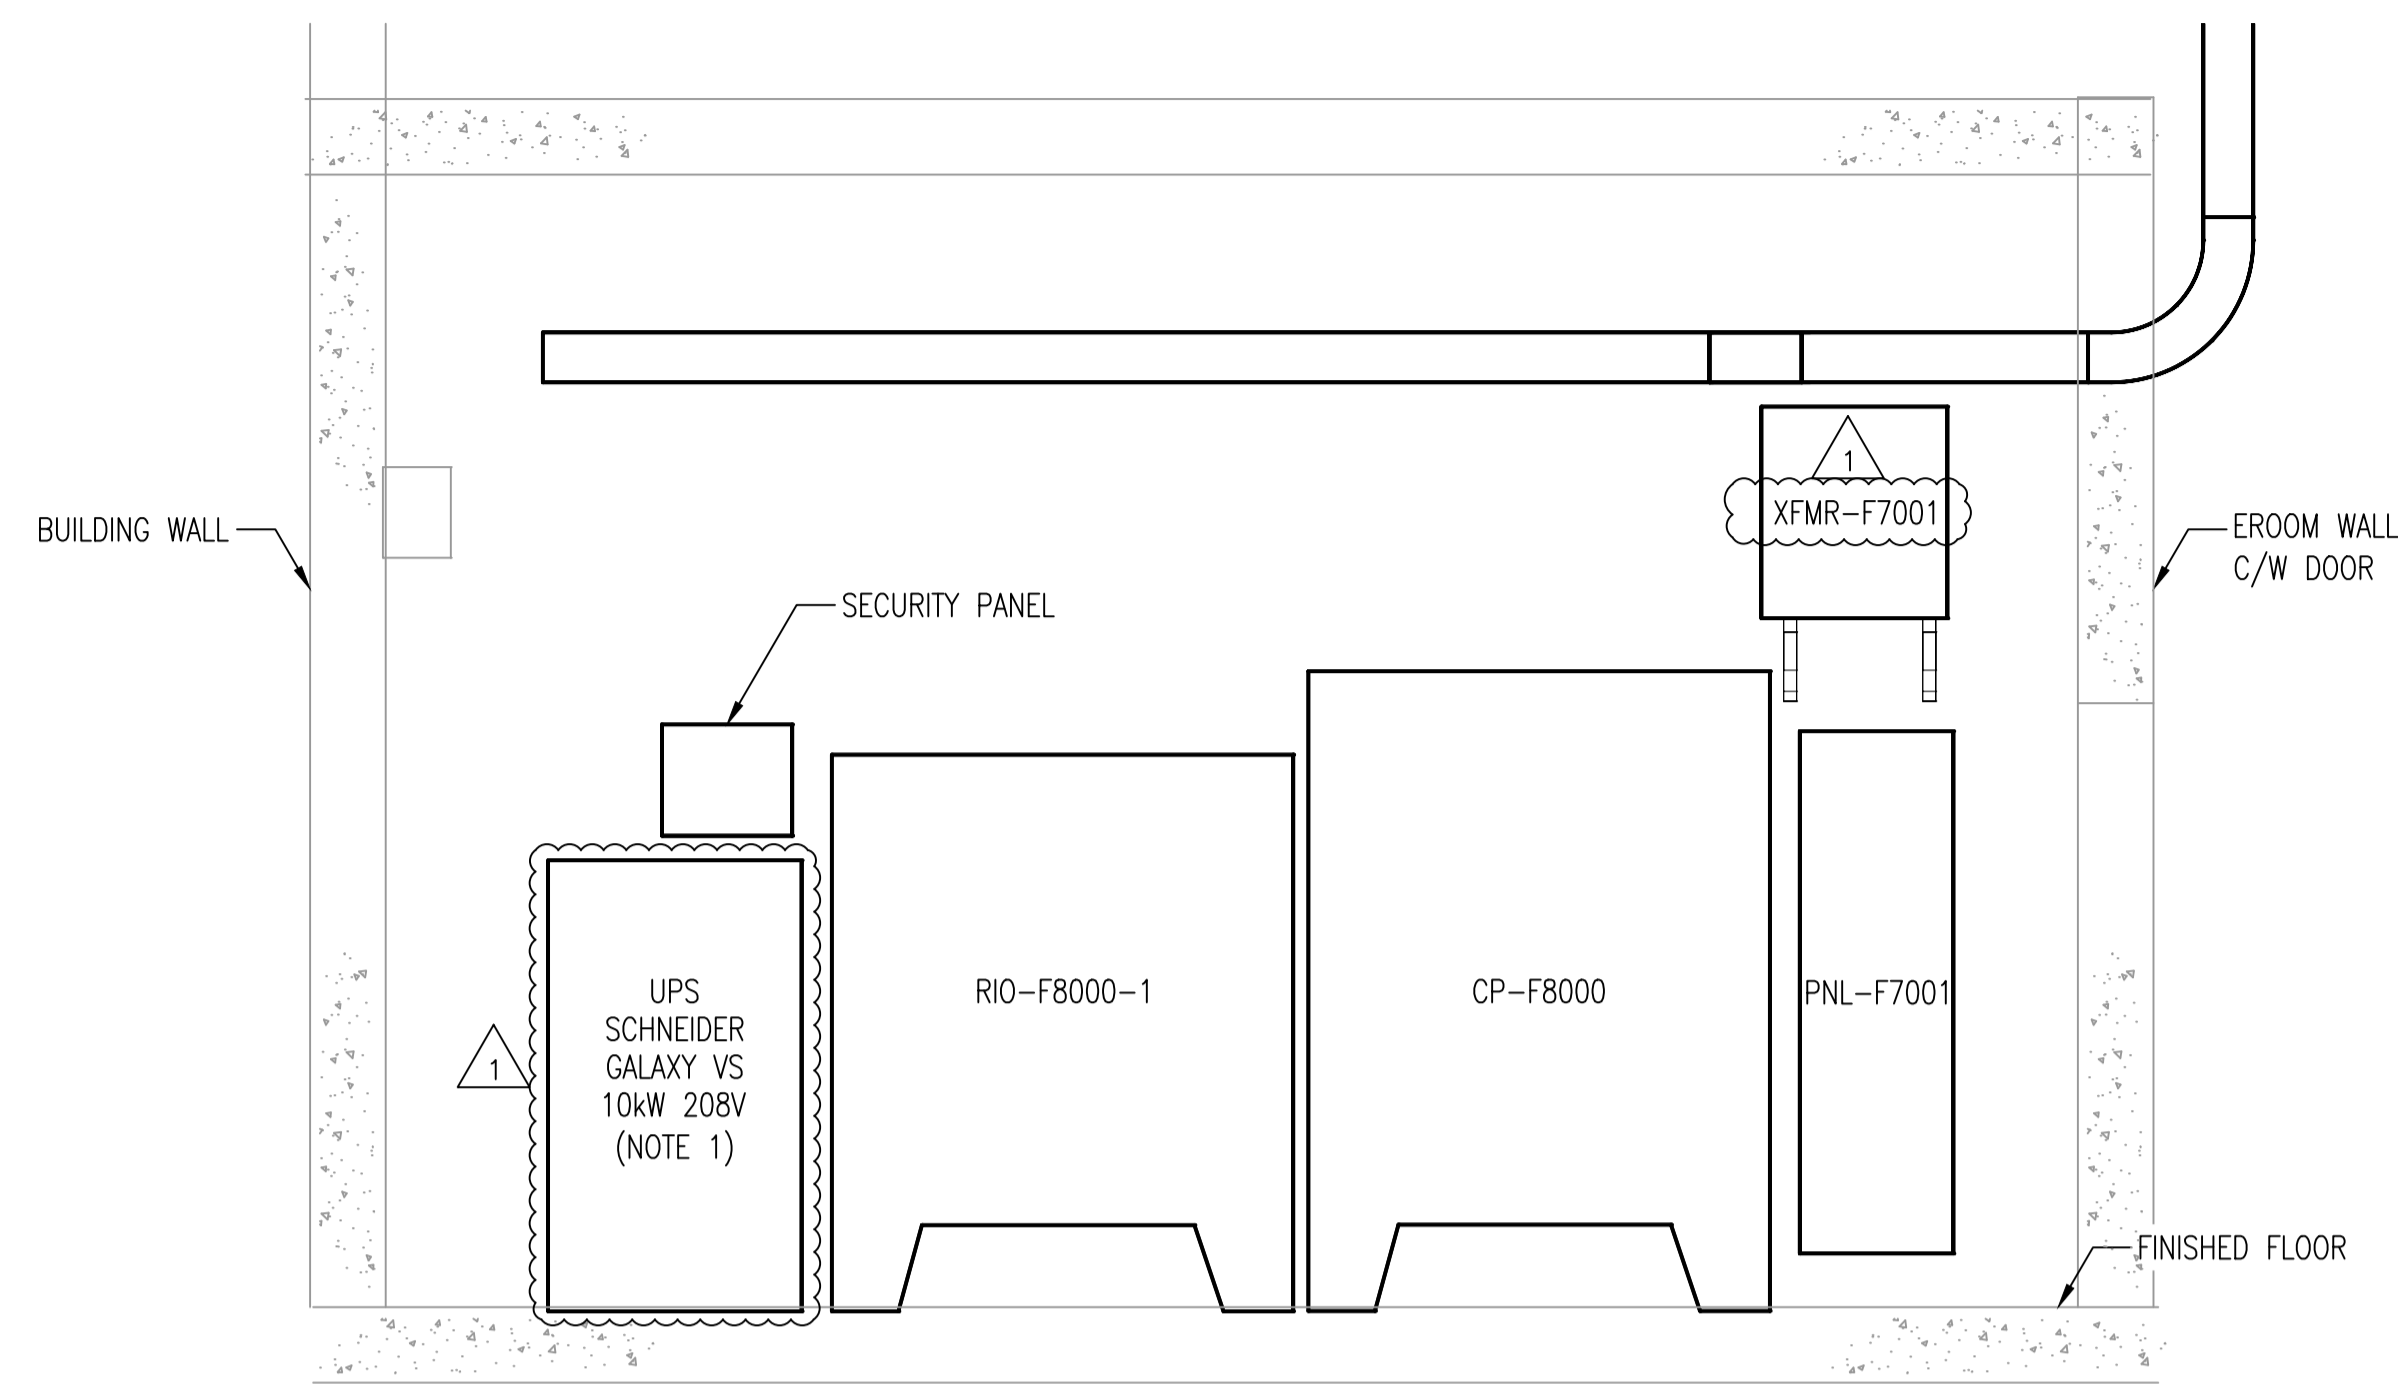


A REF.1
 ELECTRICAL ROOM – ELEVATION – EAST WALL
 SCALE: 1:25mm

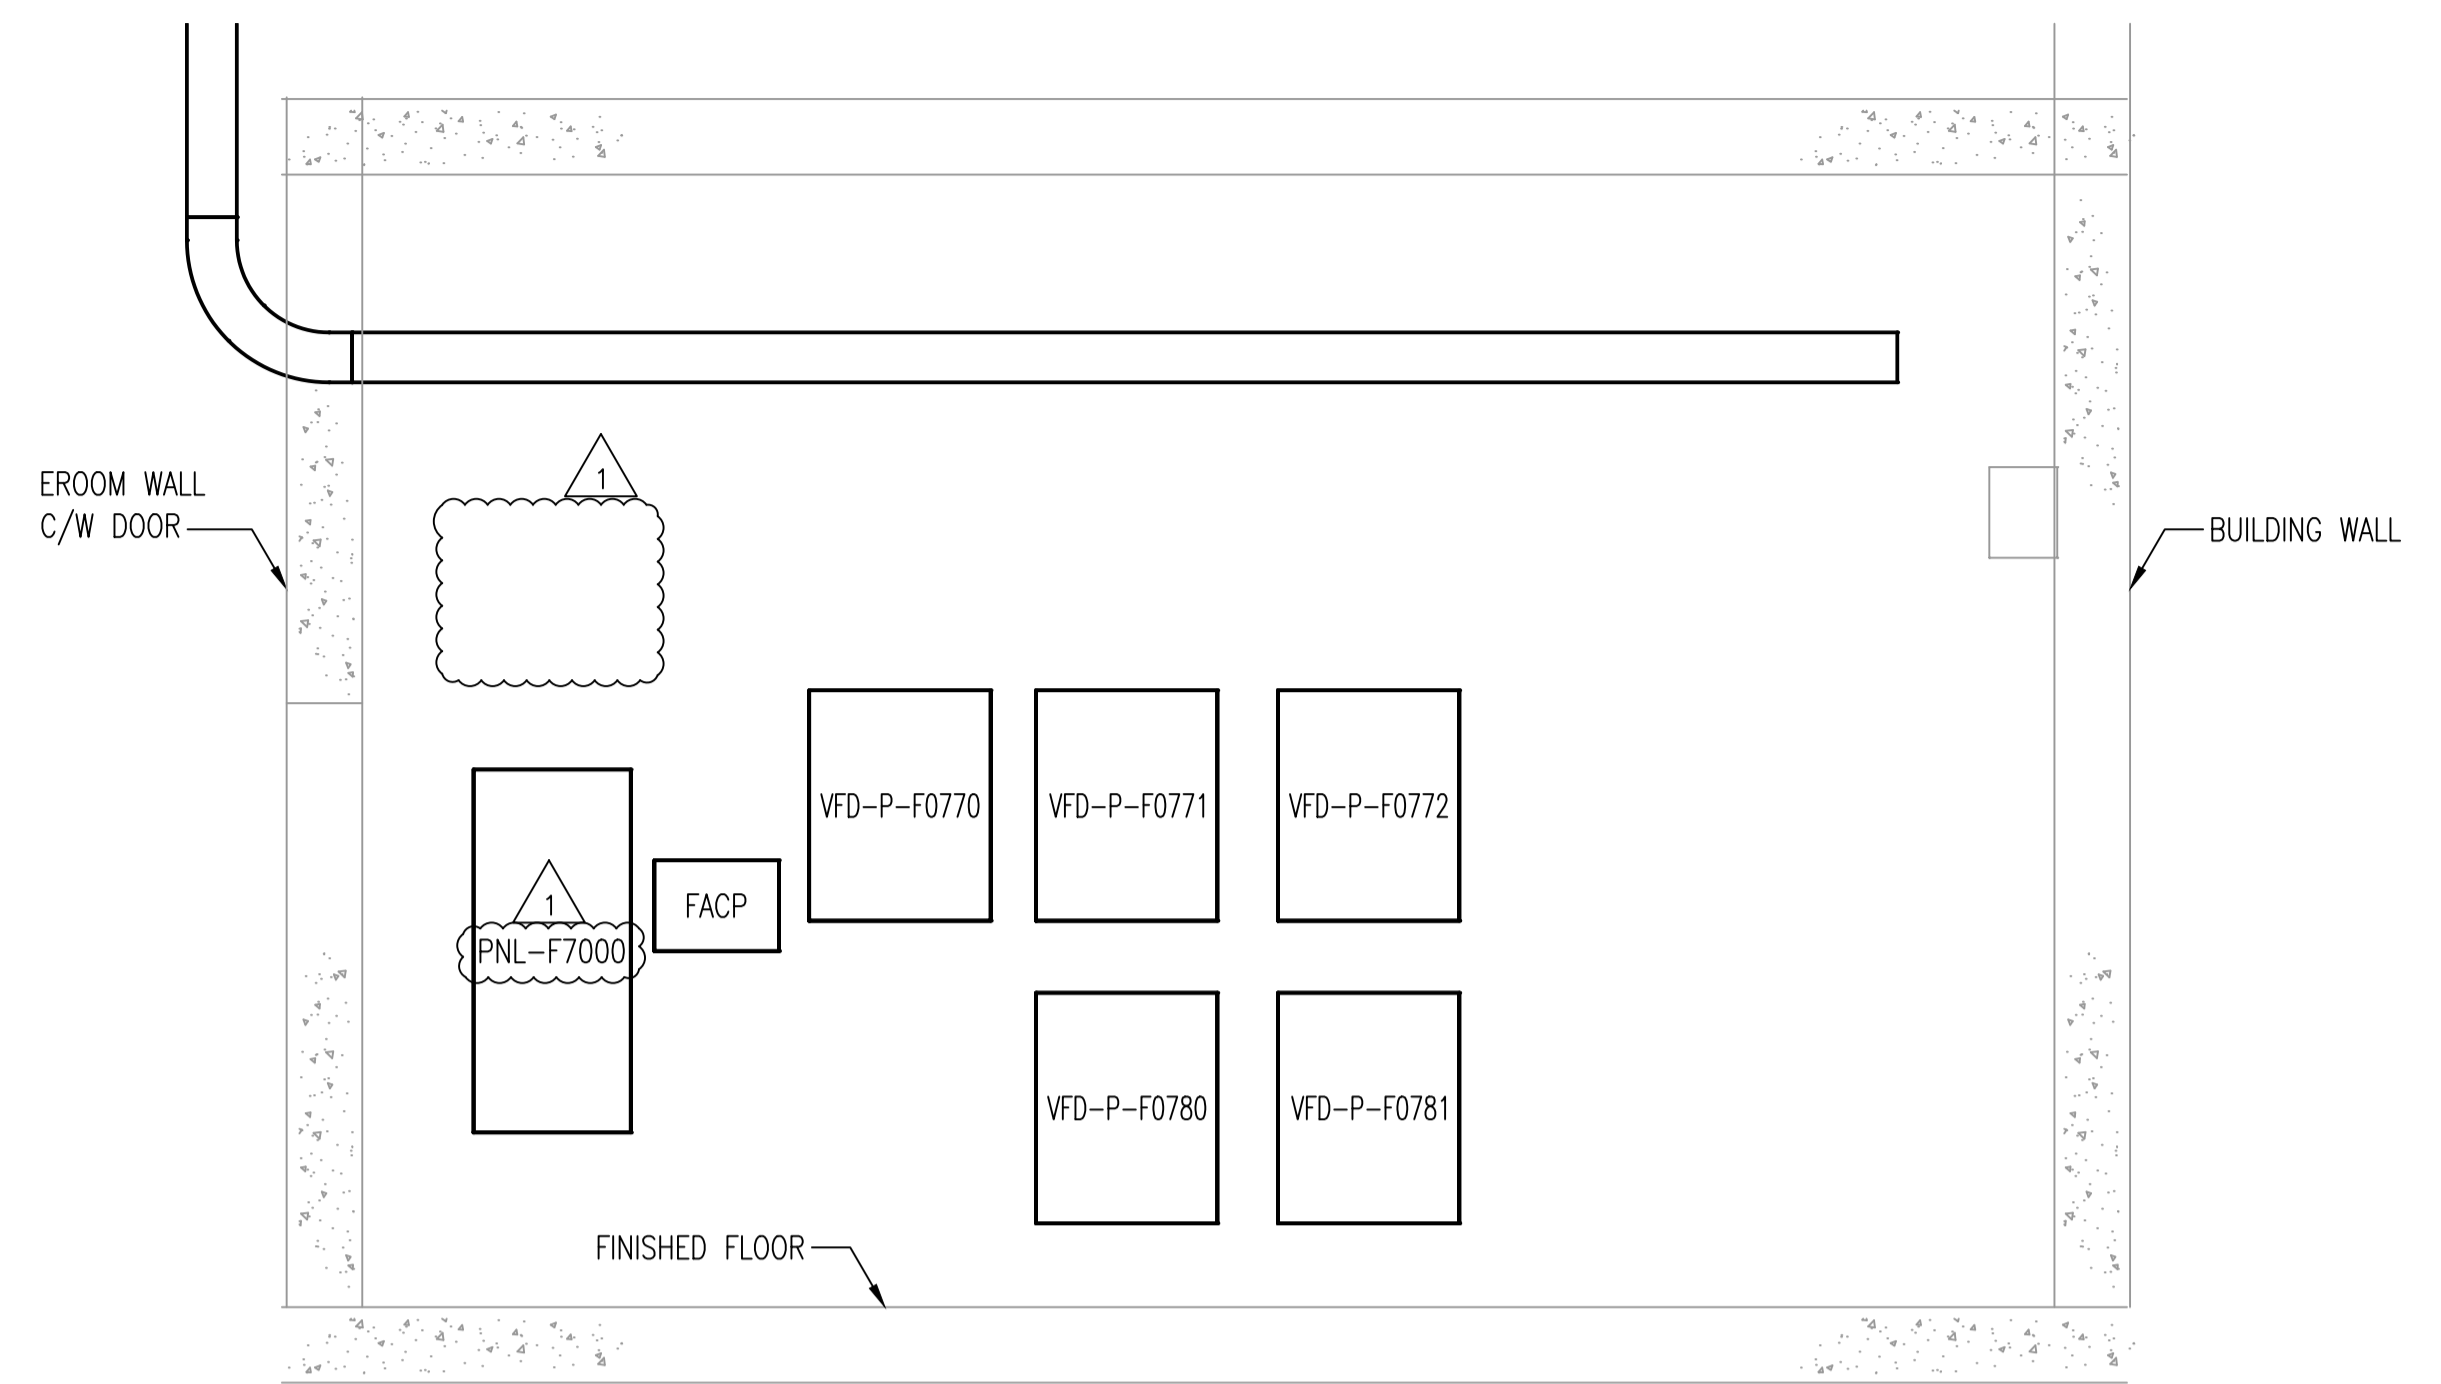


B REF.1
 ELECTRICAL ROOM – ELEVATION – WEST WALL
 SCALE: 1:25mm

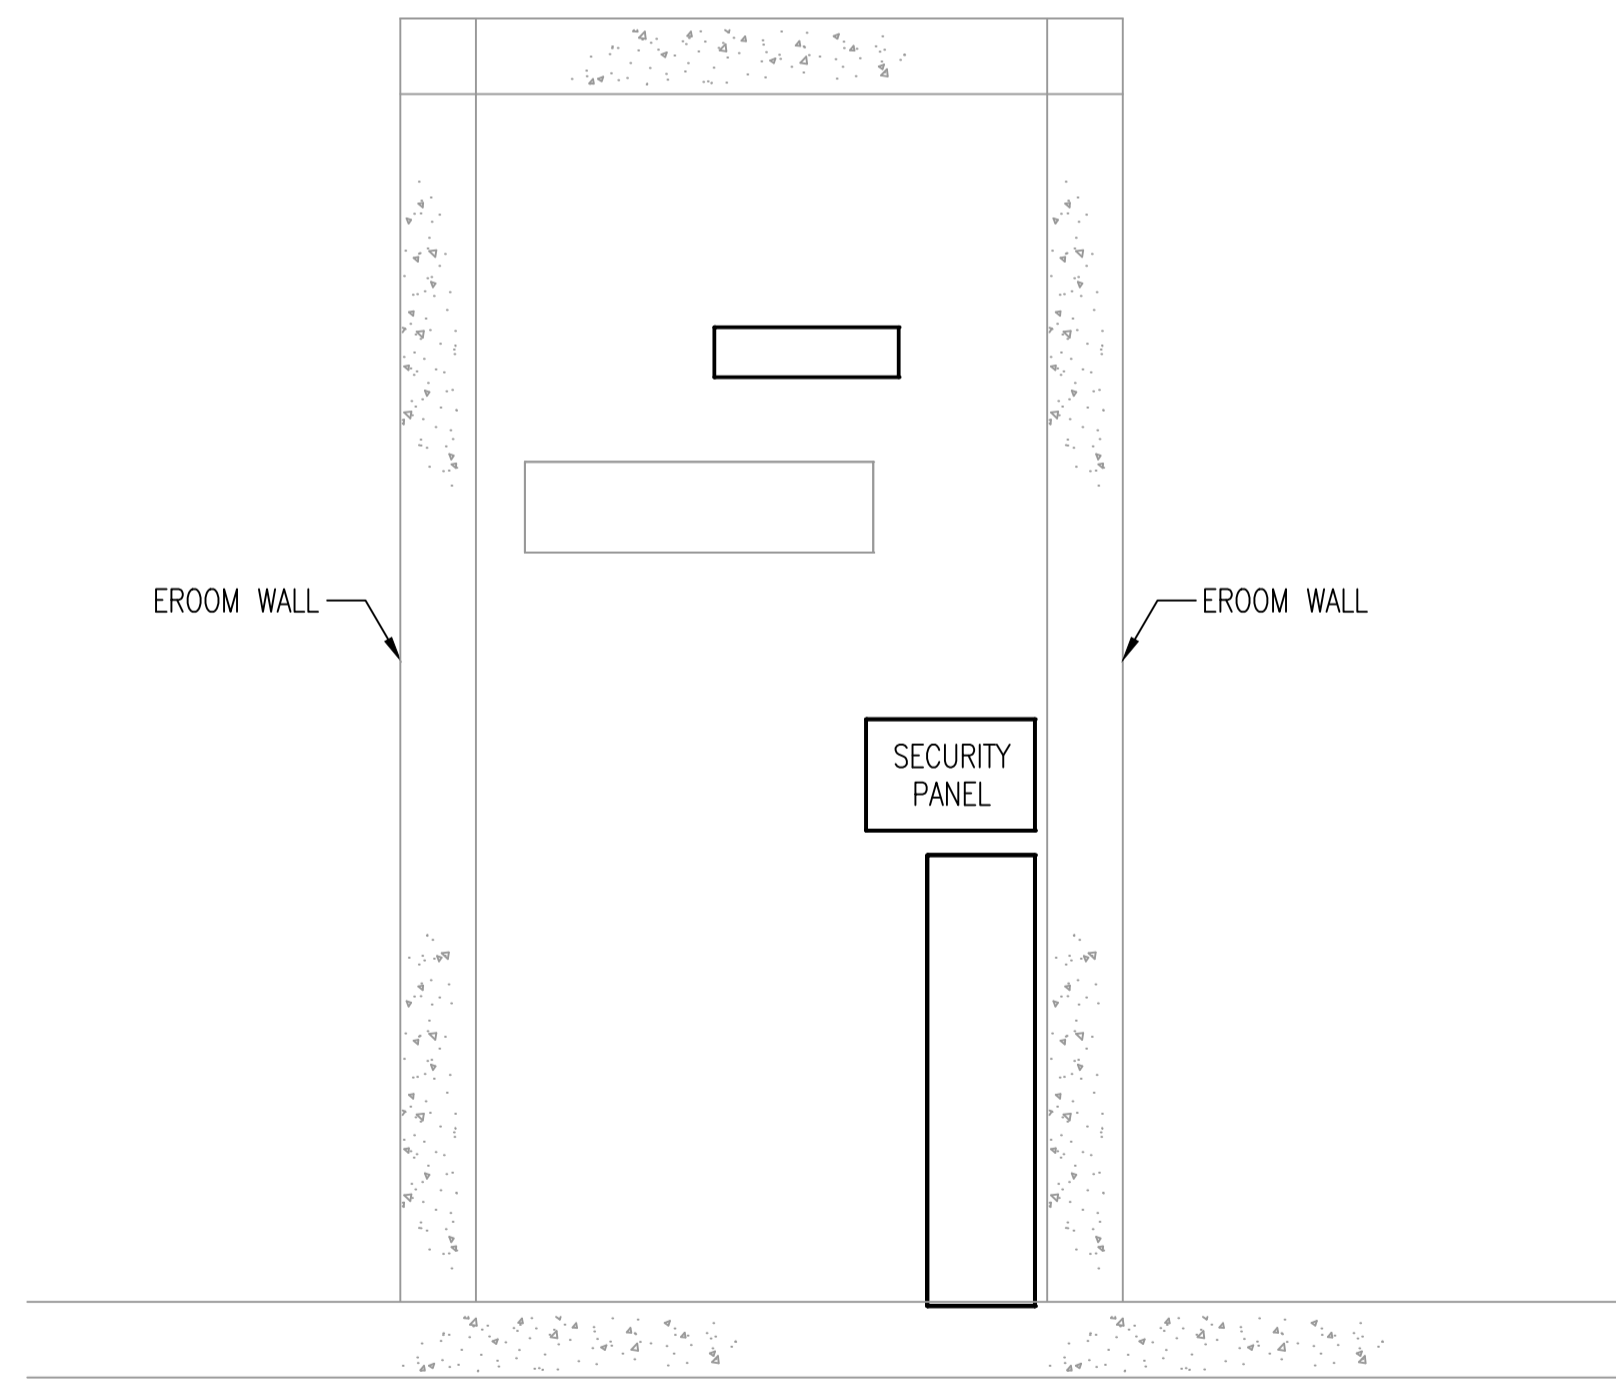

C REF.1
 ELECTRICAL ROOM – ELEVATION – SOUTH WALL
 SCALE: 1:25mm

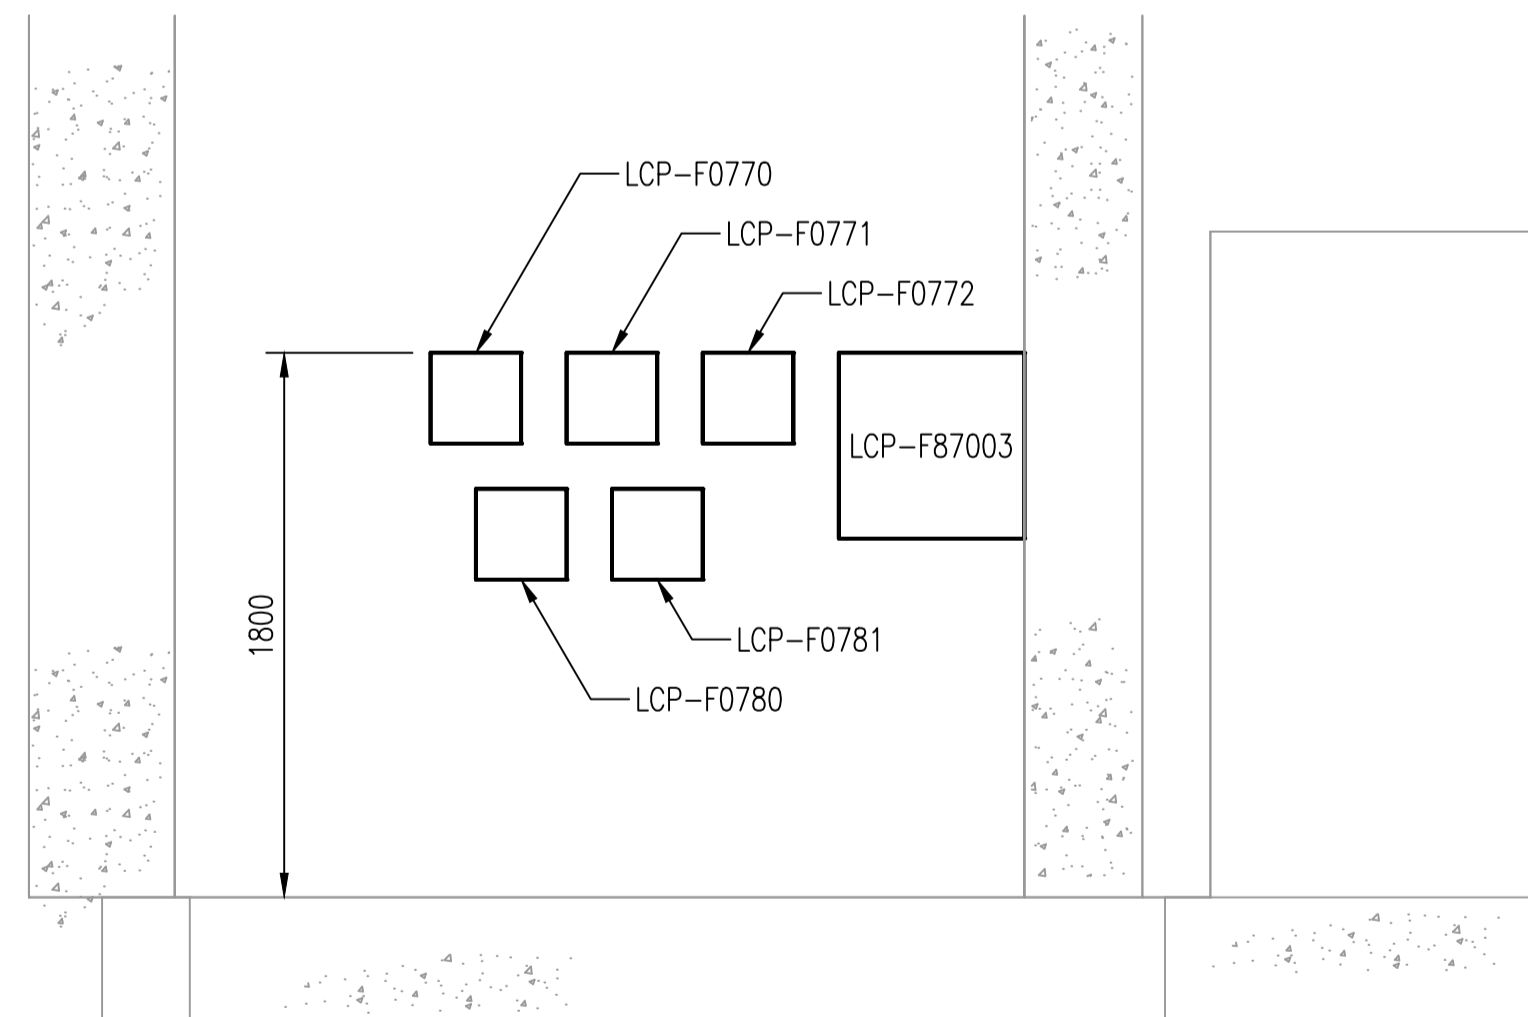

D REF.1
 BLDG. 101C MAIN FLOOR – ELEVATION – SOUTH WALL
 SCALE: 1:25mm

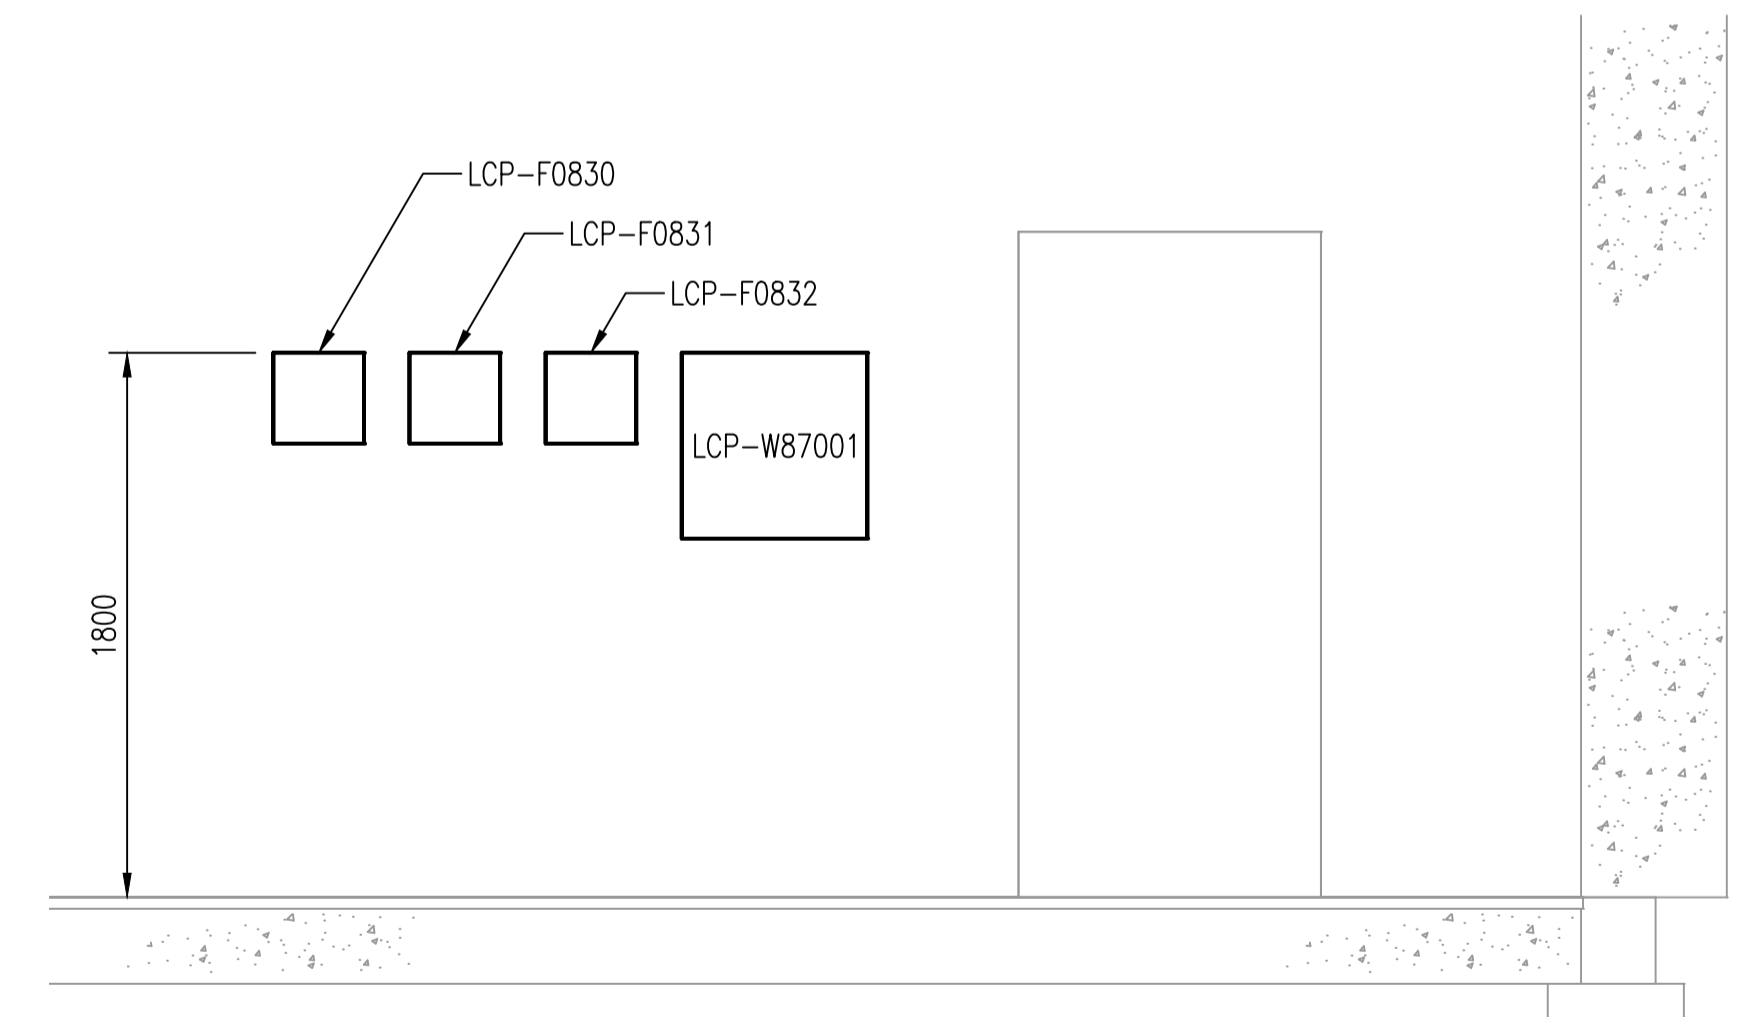

E REF.1
 BLDG. 102 MAIN FLOOR – ELEVATION – EAST WALL
 SCALE: 1:25mm

10		
9		
8		
7		
6		
5		
4		
3		
2		
1	1-0101-EGAD-F201-001	ELECTRICAL-SITE PLAN
NO.	DRAWING NUMBER	REFERENCE DRAWING TITLE
REFERENCE DRAWINGS		



B.M. ELEV.			
CONSTRUCTION COMPLETION DATE: YYYY MM DD			
NO.	REVISIONS	DATE	BY
1	RE-ISSUED FOR CONSTRUCTION	2022 07 05	JAB
0	ISSUED FOR CONSTRUCTION	2022 05 18	JAB

KGS GROUP			
DESIGNED BY	DG	CHECKED BY	JAB
DRAWN BY	RG	APPROVED BY	JAB
SCALE:	AS SHOWN		
DATE	2022 04 18	DATE	
PLOT DATE: 2022 07 21			

ENGINEER'S SEAL	
CONSULTANT DRAWING NUMBER	
21-0107-015_E3.102	

THE CITY OF WINNIPEG
 WATER AND WASTE DEPARTMENT
 ENGINEERING DIVISION

Winnipeg

NORTH END SEWAGE TREATMENT PLANT (NEWPC)
 INTERIM PHOSPHOROUS REMOVAL
 ELECTRICAL

ELECTRICAL DETAILS – INSTALLATION DETAILS

CITY DRAWING NUMBER	1-0101-EGAD-F208-001
SHEET	OF