


A SECTION
1-0165S-C0001-001

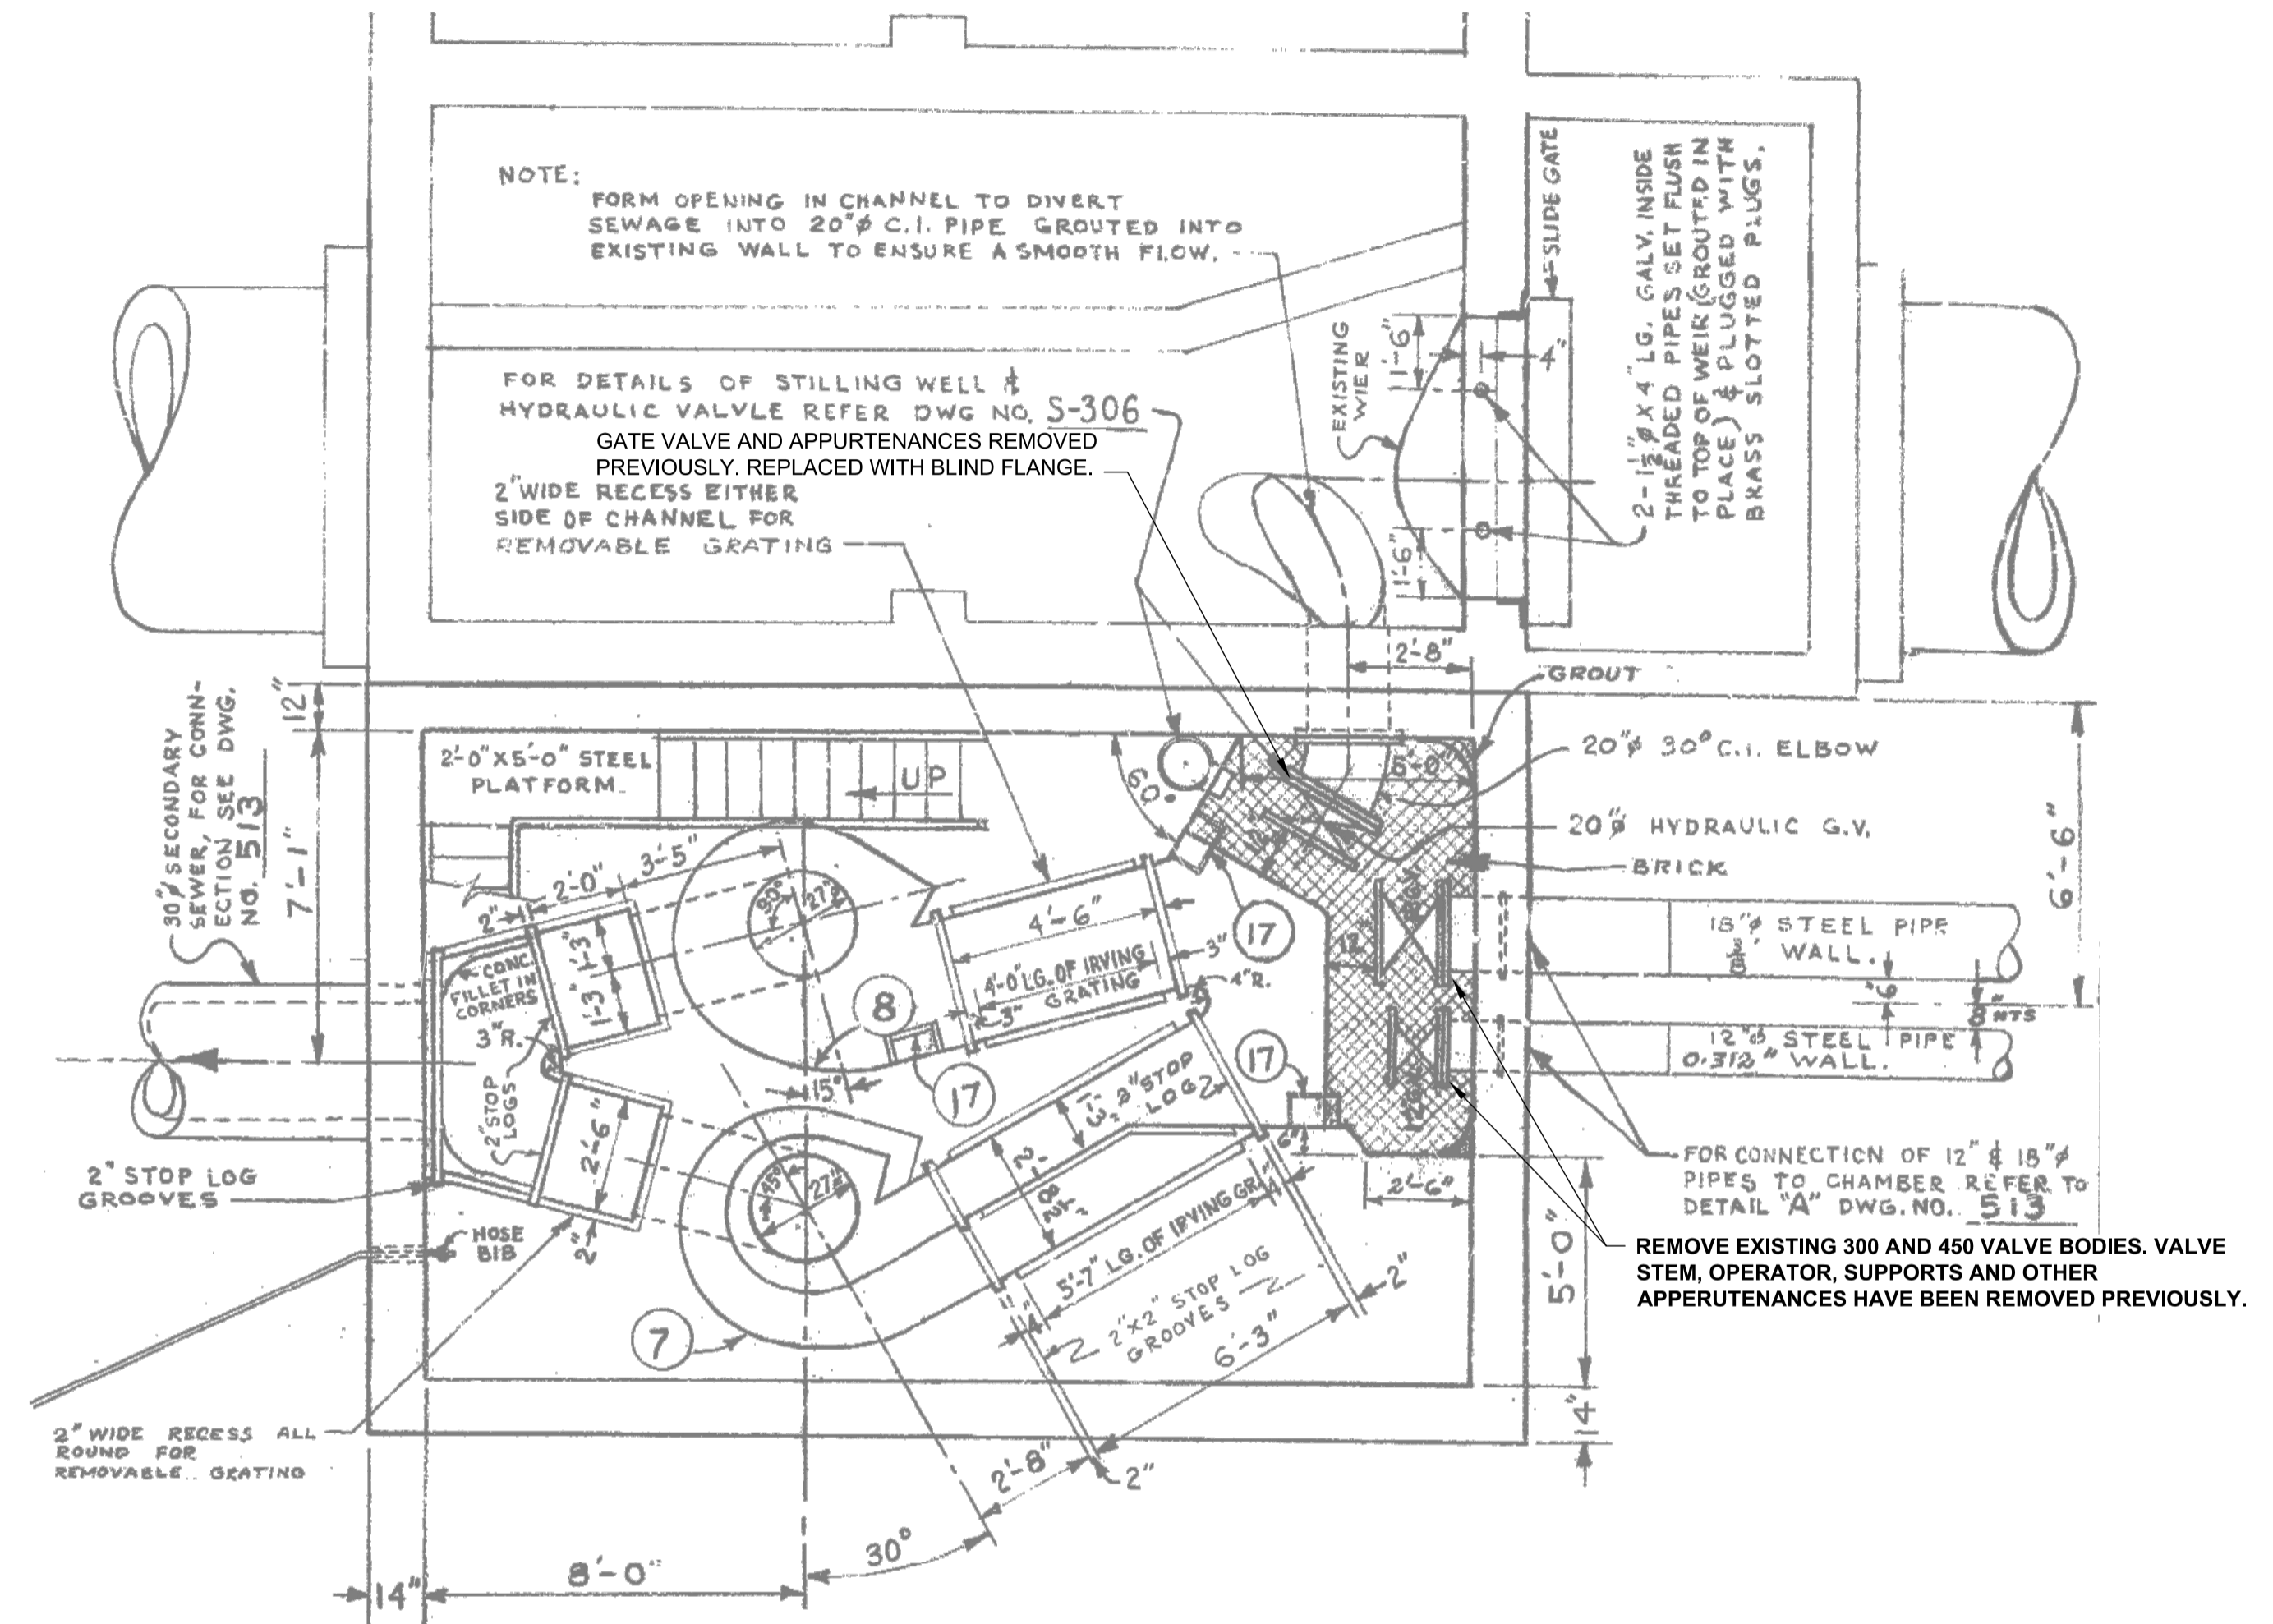

DETAIL
1-0165S-C0001-001 FLOOR PLAN

ENGINEERS GEOSCIENTISTS MANITOBA
Certificate of Authorization
AECOM Canada Ltd.
No. 4671 Date: 2022/06/07

WARNING
IF POWER EQUIPMENT OR EXPLOSIVES ARE TO BE USED FOR EXCAVATION ON THIS PROJECT THE CONTRACTOR MUST:
1) NOTIFY THE GAS COMPANY OF THE PROPOSED LOCATION OF EXCAVATION.
2) TAKE PRECAUTION TO AVOID DAMAGE TO GAS COMPANY INSTALLATIONS.
SEE PROVINCIAL REGULATION 210/72 FOR DETAILS

LOCATION APPROVED UNDERGROUND STRUCTURES
SUPV. U/G STRUCTURES COMMITTEE DATE
NOTE:
LOCATION OF UNDERGROUND STRUCTURES AS SHOWN ARE BASED ON THE BEST INFORMATION AVAILABLE BUT NO GUARANTEE IS GIVEN THAT ALL EXISTING UTILITIES ARE SHOWN OR THAT THE GIVEN LOCATIONS ARE EXACT. CONFIRMATION OF EXISTENCE AND EXACT LOCATION OF ALL SERVICES MUST BE OBTAINED FROM THE INDIVIDUAL UTILITIES BEFORE PROCEEDING WITH CONSTRUCTION.

B.M. ELEV.			
CONSTRUCTION COMPLETION DATE: YYYY MM DD			
NO.	ISSUED FOR TENDER	22/06/07	ADL
	REVISIONS	DATE	BY

AECOM	
DESIGNED BY: TGB	CHECKED BY: MPG
DRAWN BY: ADL	APPROVED BY: CCM
SCALE: HORIZONTAL AS NOTED	RELEASED FOR CONSTRUCTION: K Zurek
VERTICAL: N/A	DATE: Jun 6/22
DATE: 2022 06 06	DATE: Jun 6/22

ENGINEER'S SEAL
ORIGINAL SIGNED BY C. Macey 06/07/22
CONSULTANT DRAWING NUMBER: C-3001

THE CITY OF WINNIPEG
WATER AND WASTE DEPARTMENT
ENGINEERING SERVICES DIVISION
REHABILITATION OF MUNROE AVENUE
SIPHON BY CIPP LINING
POLSON COMMUNUTOR CHAMBER
SECTIONS & DETAILS

SHEET 6 OF 7
CITY DRAWING NUMBER
1-0173F-C0001-001