






DRAWING LIST

- E0.1 DRAWING LIST, SYMBOL LEGEND AND SITE PLAN
- E1.1 PARTIAL MAIN FLOOR AND ROOF PLAN - ELECTRICAL - DEMOLITION AND NEW CONSTRUCTION
- E2.1 ELECTRICAL SPECIFICATION AND SCHEDULES

ELECTRICAL SYMBOL LEGEND	
	MOTOR AND DISCONNECT
	SURFACE MOUNTED PANEL
	GFI DUPLEX RECEPTACLE 20A 1" SLOT 5-20R
	PROGRAMMABLE RELAY

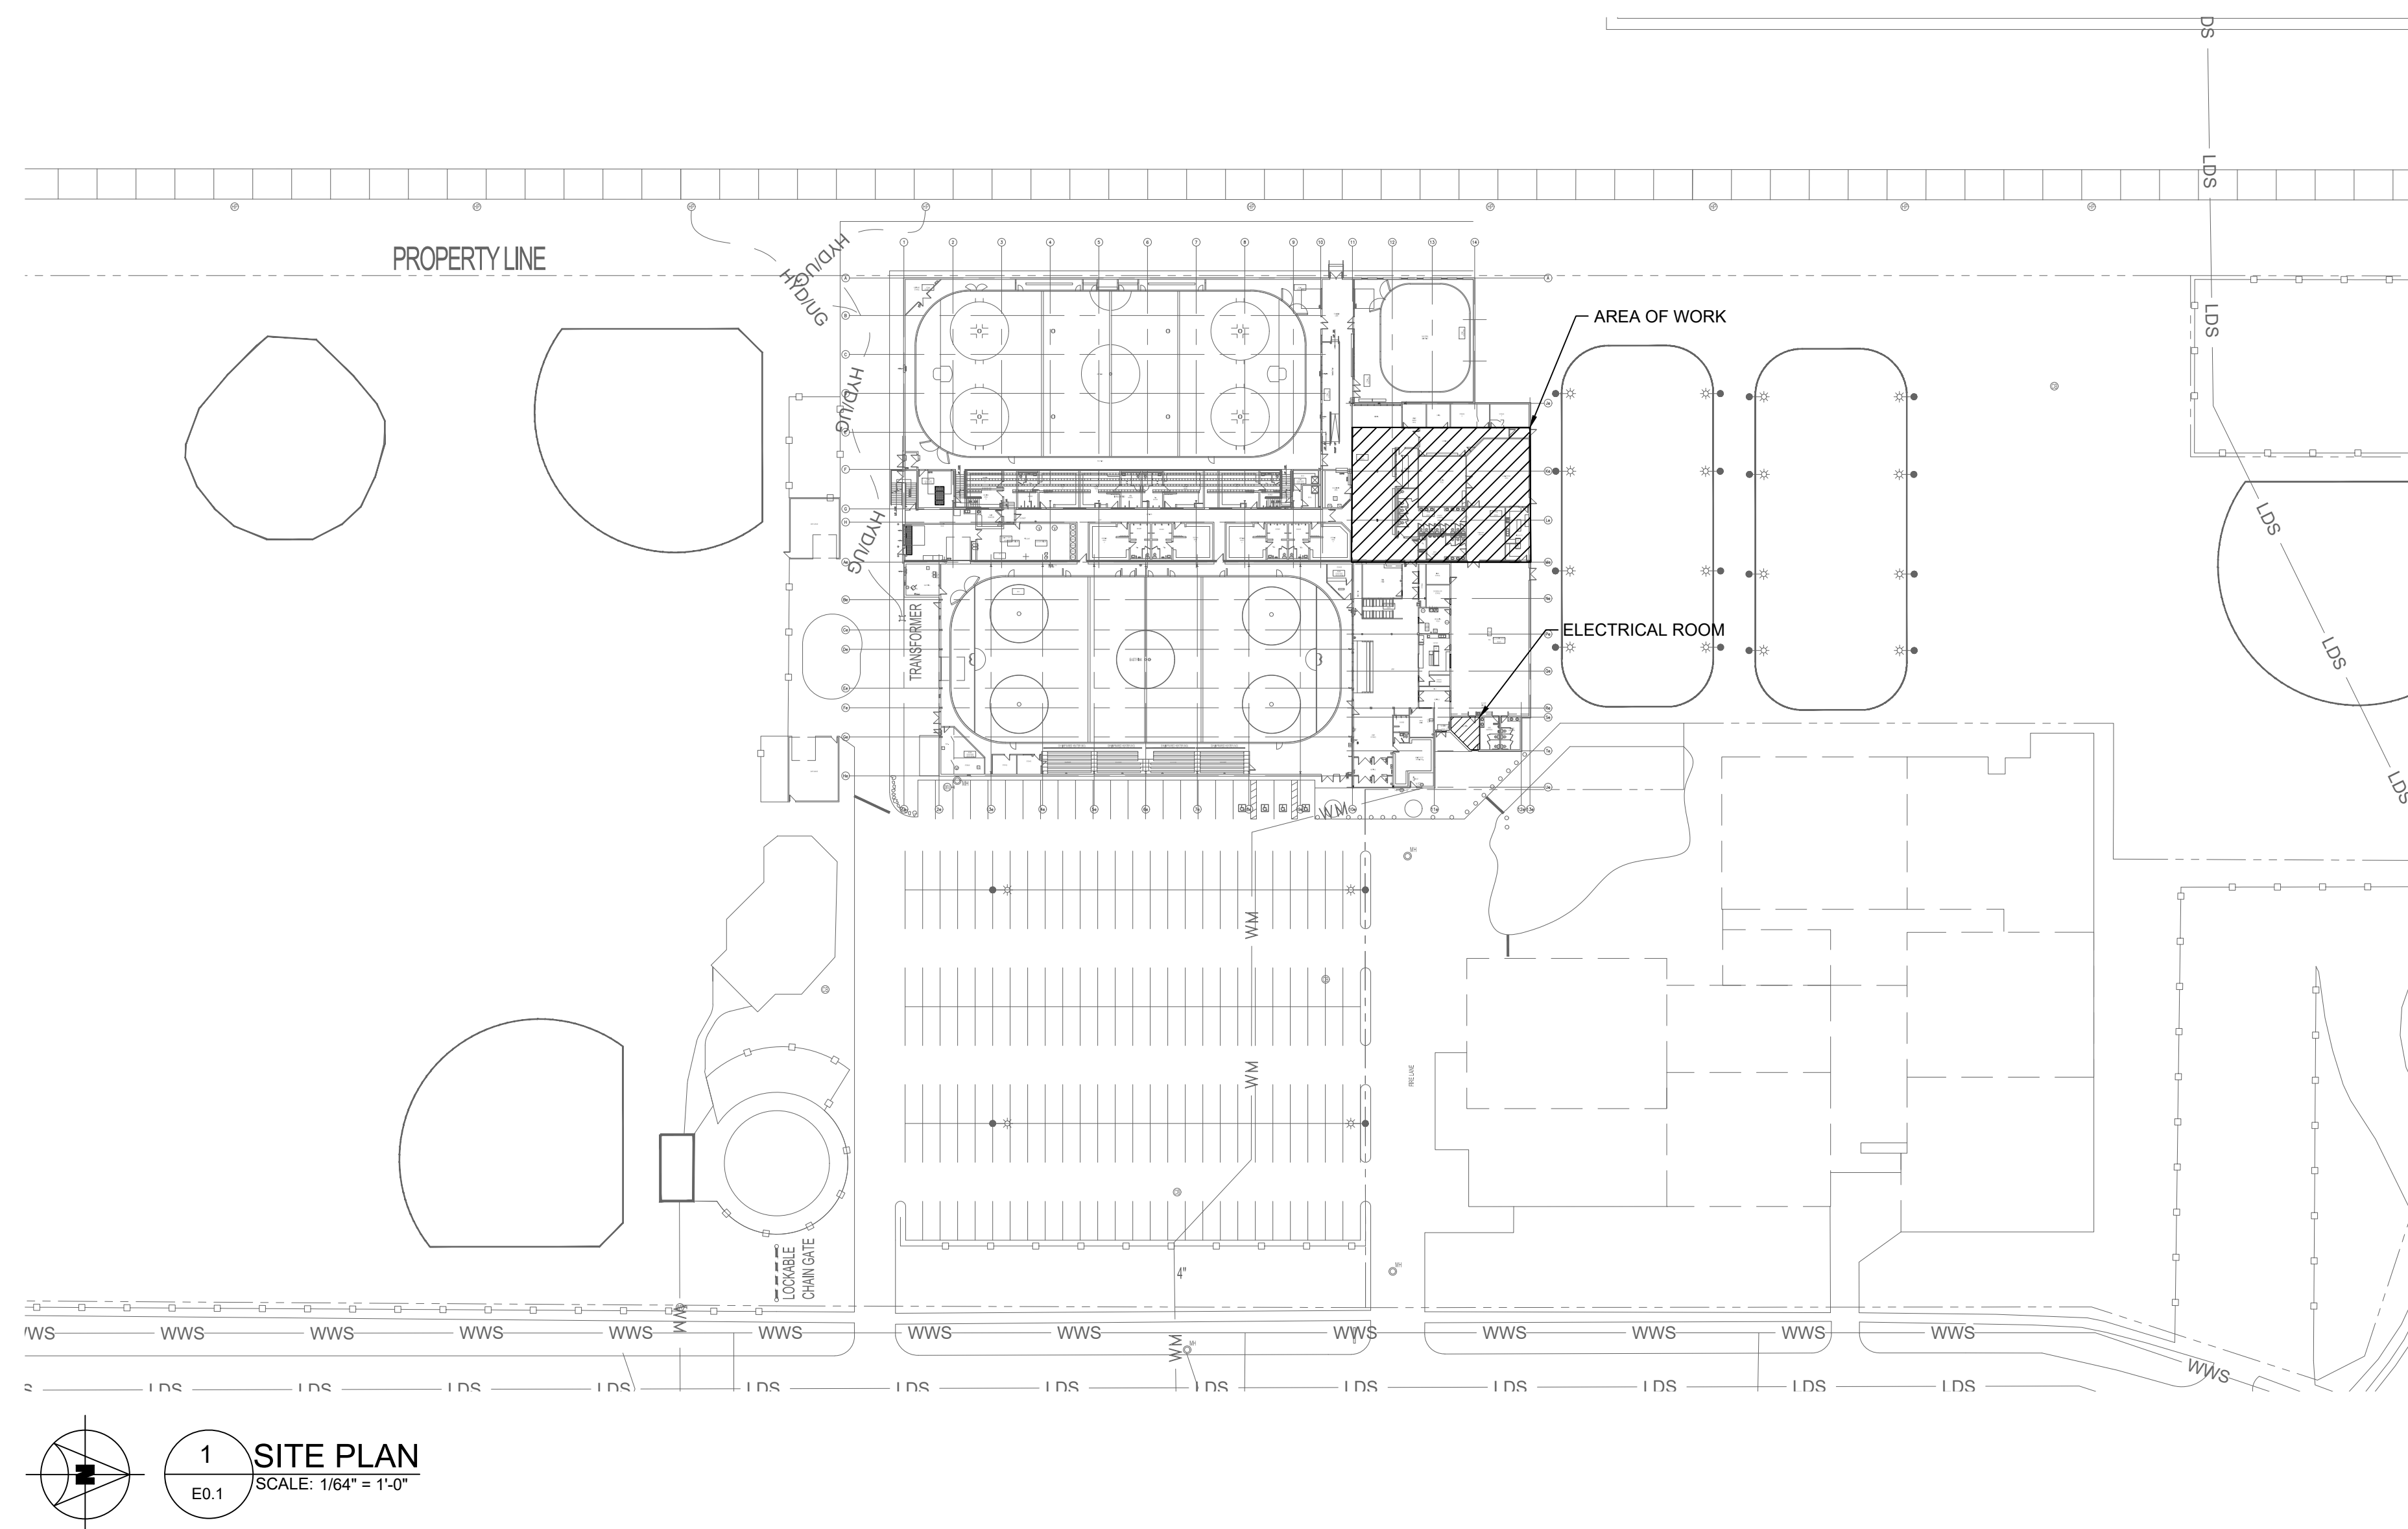

FILE NAME AND PATH: G:\PROJECTS\2022\21 SOUTHDALE CC\WMA Replacement\3.0 Cond. Rev\04.4 Elec\2179_00-1_L1.dwg
 LAYOUT: E0.1 LAST SAVED BY: gignour DATE PLOTTED: July 4, 2022 10:38:08 AM

	1 SITE PLAN SCALE: 1/164" = 1'-0"	 ENGINEERS GEO-SCIENTISTS MANITOBA Certificate of Authorization SMS Engineering Ltd. No. 166	 PROVINCE OF MANITOBA G.J. WHIFFEN REGISTERED PROFESSIONAL ENGINEER Member # 34242	 770 Bradford Street Winnipeg, Canada (204) 775-0291 smseng.com	Project Title SOUTHDALE CC RTU REPLACEMENT BID OPP. 648-2022	Drawing Title DRAWING LIST, SYMBOL LEGEND AND SITE PLAN	Drawn By AMP Checked By BG Approved By GW Scale AS NOTED Date AUG. 2022 Project No. 22-179-01	Revision Number 0 Drawing Number E0.1 Sheet Order 1 OF 3	
0 LETTER OR NUMBER	ISSUED FOR CONSTRUCTION DESCRIPTION	GW BY DDMMYY						WINNIPEG MANITOBA	