

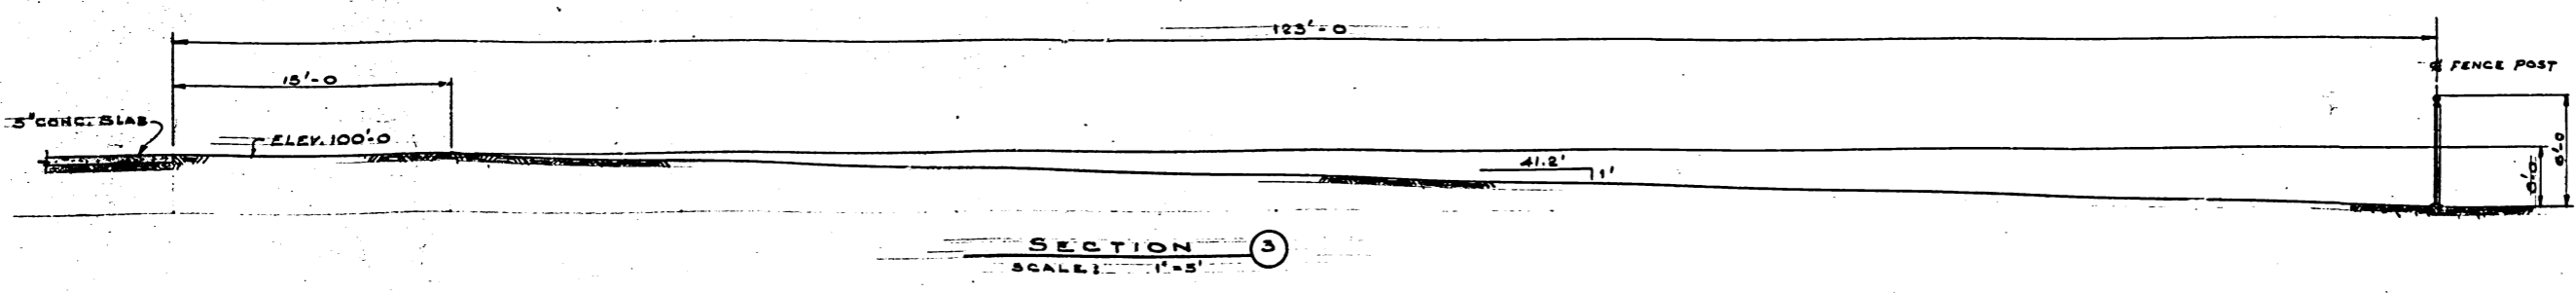
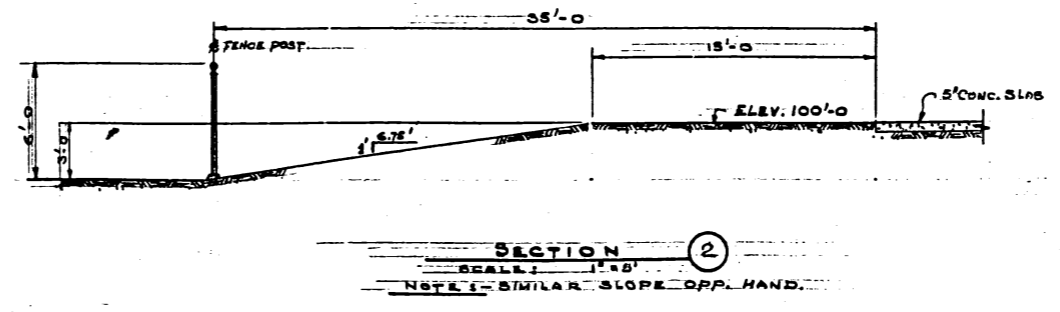


POOL AREA GRADING PLAN
SCALE: 1" = 10'

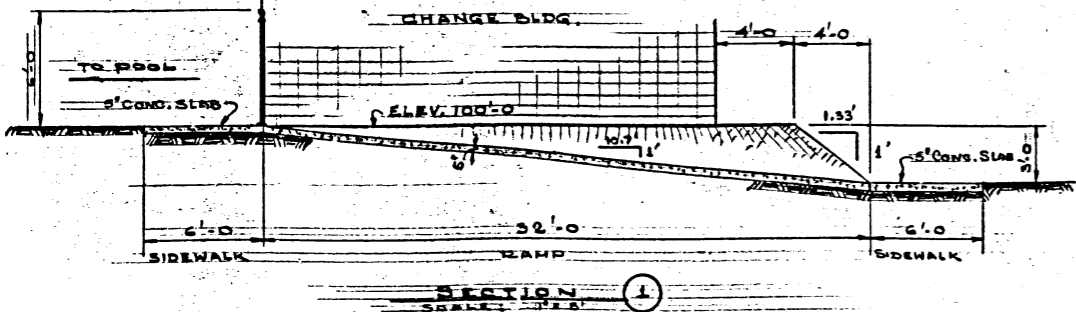

NO.	DESCRIPTION	DATE	DWN.	CH.

REVISIONS

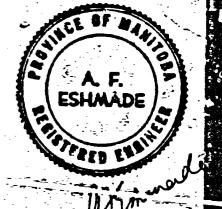

APPROVED BY: *[Signature]* DATE: 9/5/67

CITY OF ST. VITAL
CENTENNIAL SWIMMING POOL
FENCE, GRADING PLAN
AND SECTIONS


UNDERWOOD McLELLAN & ASSOCIATES
LIMITED

CONSULTING PROFESSIONAL ENGINEERS
MANITOBA SASKATCHEWAN ALBERTA BRITISH COLUMBIA

DRAWN BY: O.T.	DESIGNED BY:
CHECKED BY:	CHECKED BY: <i>[Signature]</i>
DATE DRAWN: MAY 8/67	SCALE: AS SHOWN
JOB NO.: 23-538-02	DRAWING NO.: 01
SHEET OF	

SITE PLAN

245

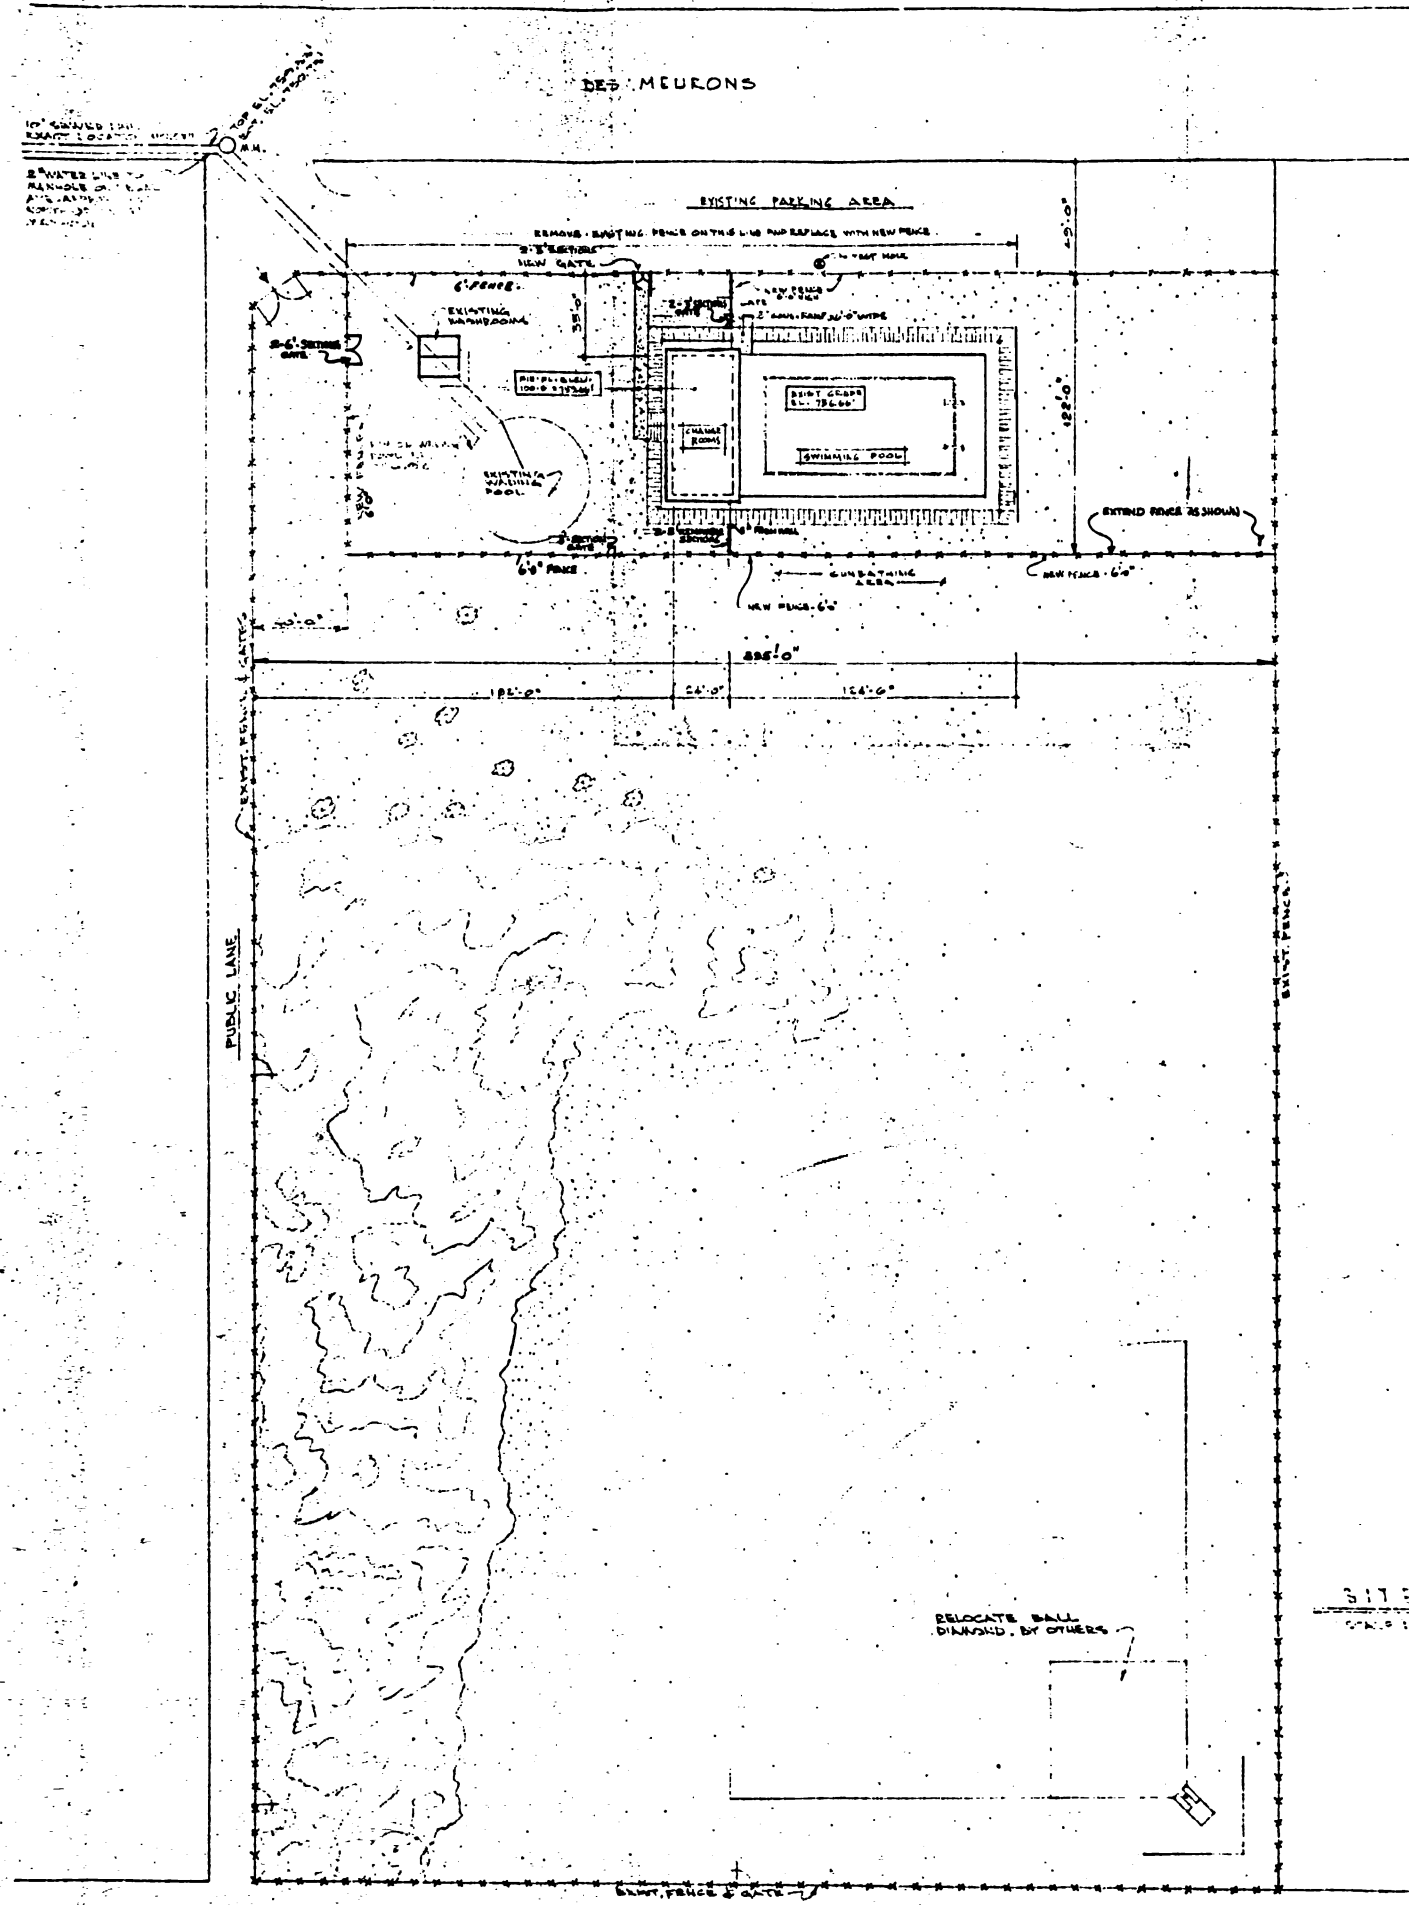

ROOM FINISH SCHEDULE												
ROOM NO.	NAME	FLOOR		BASE		WALLS		CEILING		TRIM		REMARKS
		MAT'L.	FIN.	MAT'L.	FIN.	MAT'L.	FIN.	MAT'L.	FIN.	MAT'L.	FIN.	
101	LOBBY	CONC.	W/SED			CONC. BLK	PAINTED	CECK	ST. IV	FIR	PAINT	PAINT
102	TICKETS & STORAGE	V.A.T.		R.G.B.								
103	FIRST AID ROOM	V.A.T.		R.G.B.								
104	LOCKER CH. & VA.	CONC.	W/SED				PAINTED					
105	DRY WASHROOM											
106	TRYING ROOM											
107	WET WASHROOM											
108	SHOWER ROOM						SPECTRA GLASS			FIR	PAINT	PAINT
109	BEEN CHANGE RM.											
110	DRY WASHROOM											
111	DRYING AREA											
112	WET WASHROOM											
113	SHOWER ROOM	CONC.	W/SED			CONC. BLK	SPECTRA GLASS			FIR	PAINT	PAINT
B1	EXCHANGE RM.	CONC.	W/SED			CONC.						

V.A.T. - VINYL ASBESTOS TILE
R.W.A. - PRESERVATIVE WOOL FELT

LIST OF DRAWINGS	
NO.	TITLE
ARCHITECTURAL	
A-1	SITE PLAN & MISC. DETAILS
A-2	FLOOR PLANS & CIVIL PROVISIONS
A-3	ELEVATIONS & MISC. DETAILS
A-4	SECTIONAL DETAILS
A-5	MISC. DETAILS
A-6	POOL MARKINGS AND EQUIPMENT
STRUCTURAL	
S-1	PILE LAYOUT
S-2	FOUNDATION DETAILS
S-3	SECTIONS AND DETAILS
S-4	SECTIONS AND DETAILS

MECHANICAL	
M1	MECHANICAL ROOM LAYOUT
M2	PLUMBING AND DRAINAGE

ELECTRICAL	
E-1	SITE PLAN AND MISC. LIGHTING
E-2	CHANGE HOUSE DETAILS

NO.	DESCRIPTION	DATE	BY	CHKD.
1	REVISION OF PENCES AND DIMS			


REVISIONS

APPROVED BY: *[Signature]* DATE: 12/16/66
CITY OF ST. VITAL
CENTENNIAL SWIMMING POOL
 SITE PLAN & MISC. DETAILS

UNDERWOOD McLELLAN & ASSOCIATES LIMITED
 CONSULTING PROFESSIONAL ENGINEERS
 MANITOBA SASKATCHEWAN ALBERTA BRITISH COLUMBIA


DRAWN BY: H. J. HALL	DESIGNED BY: A. F. ESHMADE
CHECKED BY: H. J. HALL	CHECKED BY: A. F. ESHMADE
DATE DRAWN: AUGUST 12th. 1966	SCALE: AS SHOWN
JOB NO. 23-638-02	DRAWING NO. A-1
SHEET 1 OF 14	

SITE PLAN
SCALE 1" = 40'-0"

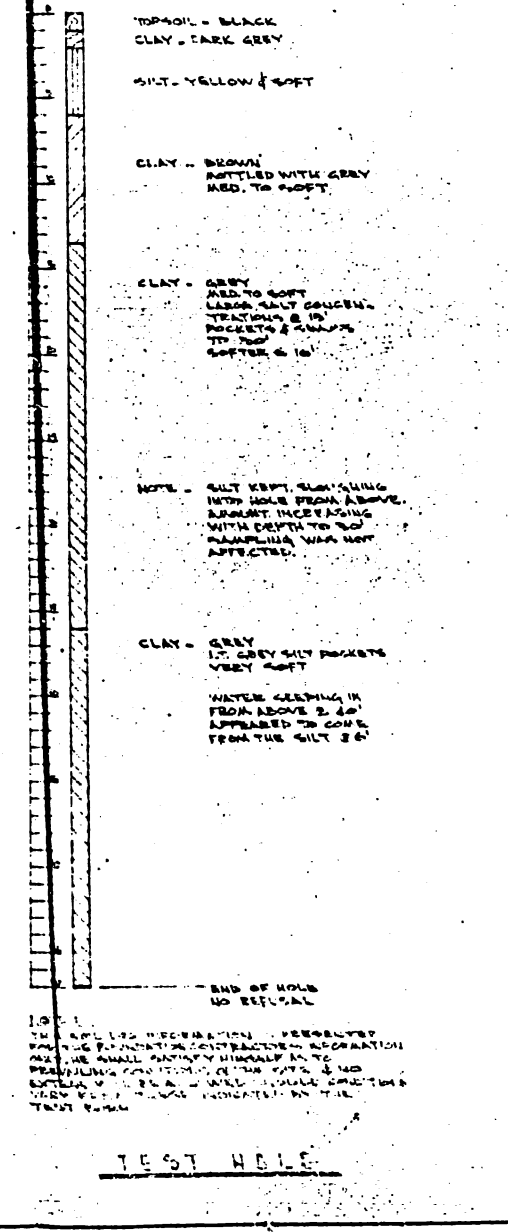


TEST HOLE






description

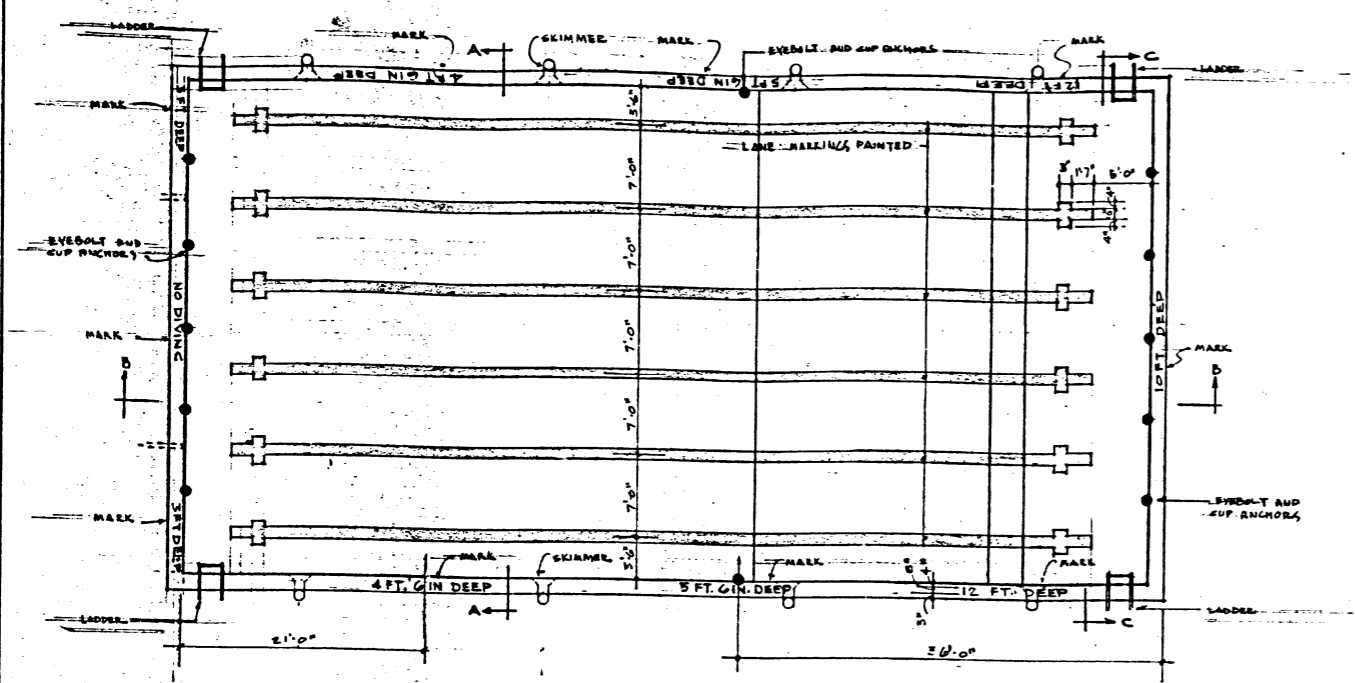

EYEBOLT AND CUP ANCHOR DETAIL
SCALE 3/8" = 1'-0"

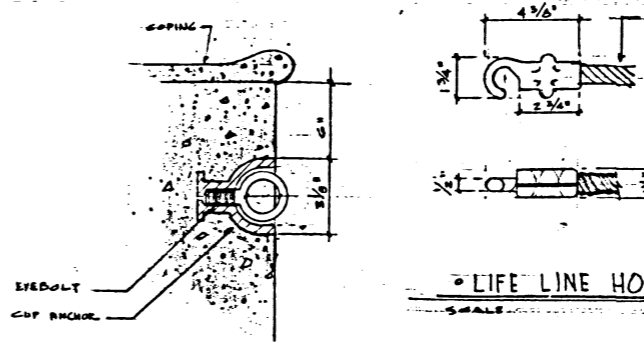


LIFE LINE HOOK DETAIL
SCALE 3/8" = 1'-0"

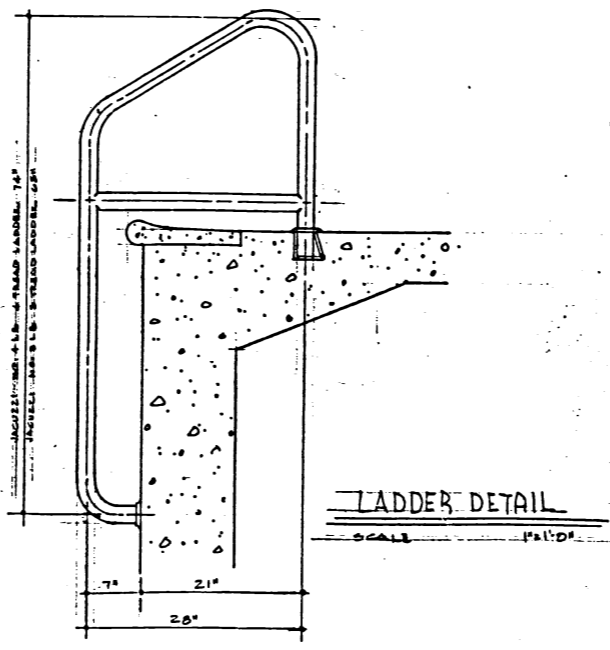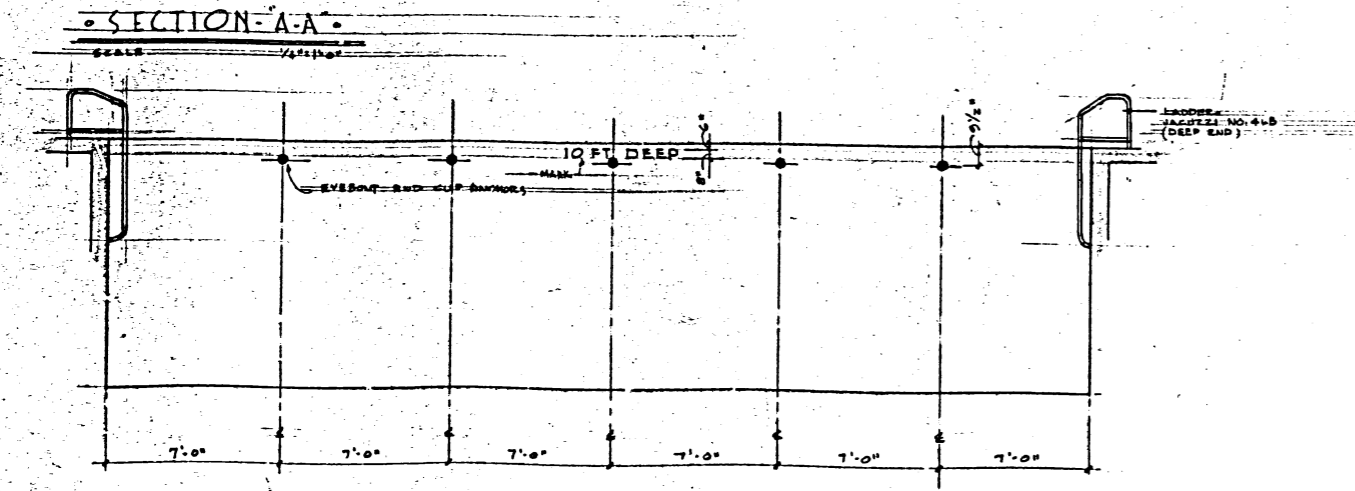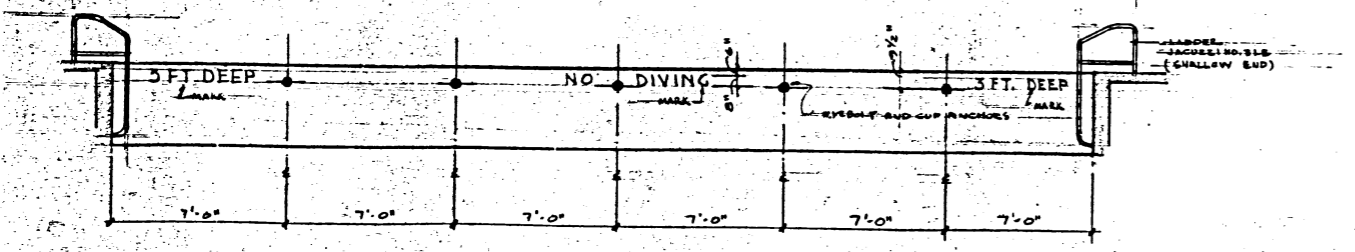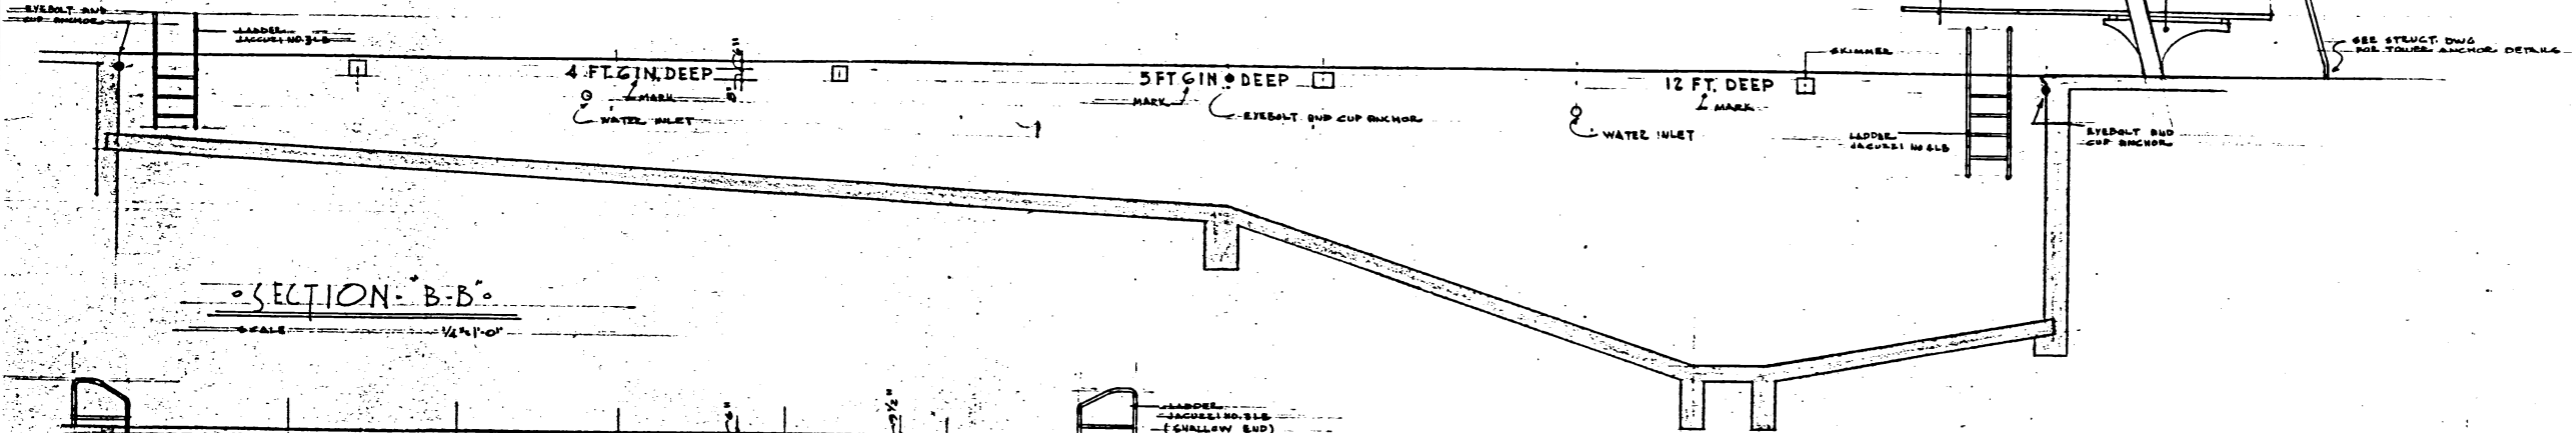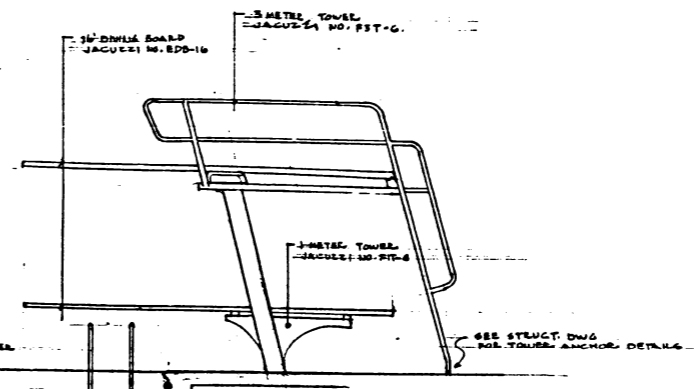

POOL EQUIPMENT LIST	
NO. AREA	DESCRIPTION
12	CUP ANCHORS JACOBS NO. EDD-16
2	LADDERS
2	WEDGE ANCHORS
1	METAL TOWER
2	1/2" DIA. BOARDS
1	LIFEGUARD CHAIR
1	VACUUM CLEANER
1	TEST KIT
8 PC.	42' POLY ROPE
12	FLOATS
12	ROPE HOOPS
1	WALL BRUSH
1	ALGAE BRUSH
1	HAND GRIP
1	THERM METER
1	LIFE HOOP
1	LIFE LINE AND ROPE

NO.	DESCRIPTION	DATE	DWN.	CHK.
REVISIONS				

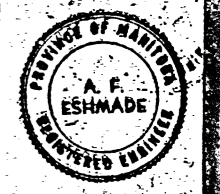


APPROVED BY *[Signature]* DATE *8/16*

CITY OF ST. VITAL
CENTENNIAL SWIMMING POOL
POOL MARKINGS





UNDERWOOD McLELLAN & ASSOCIATES LIMITED
CONSULTING PROFESSIONAL ENGINEERS
MANITOBA SASKATCHEWAN ALBERTA BRITISH COLUMBIA

DRAWN BY B.H. - R.E.L. DESIGNED BY
CHECKED BY
DATE DRAWN AUGUST 12th 1966 SCALE AS SHOWN
JOB NO. 23-638-02 DRAWING NO. A-6
SHEET 6 OF 14

description

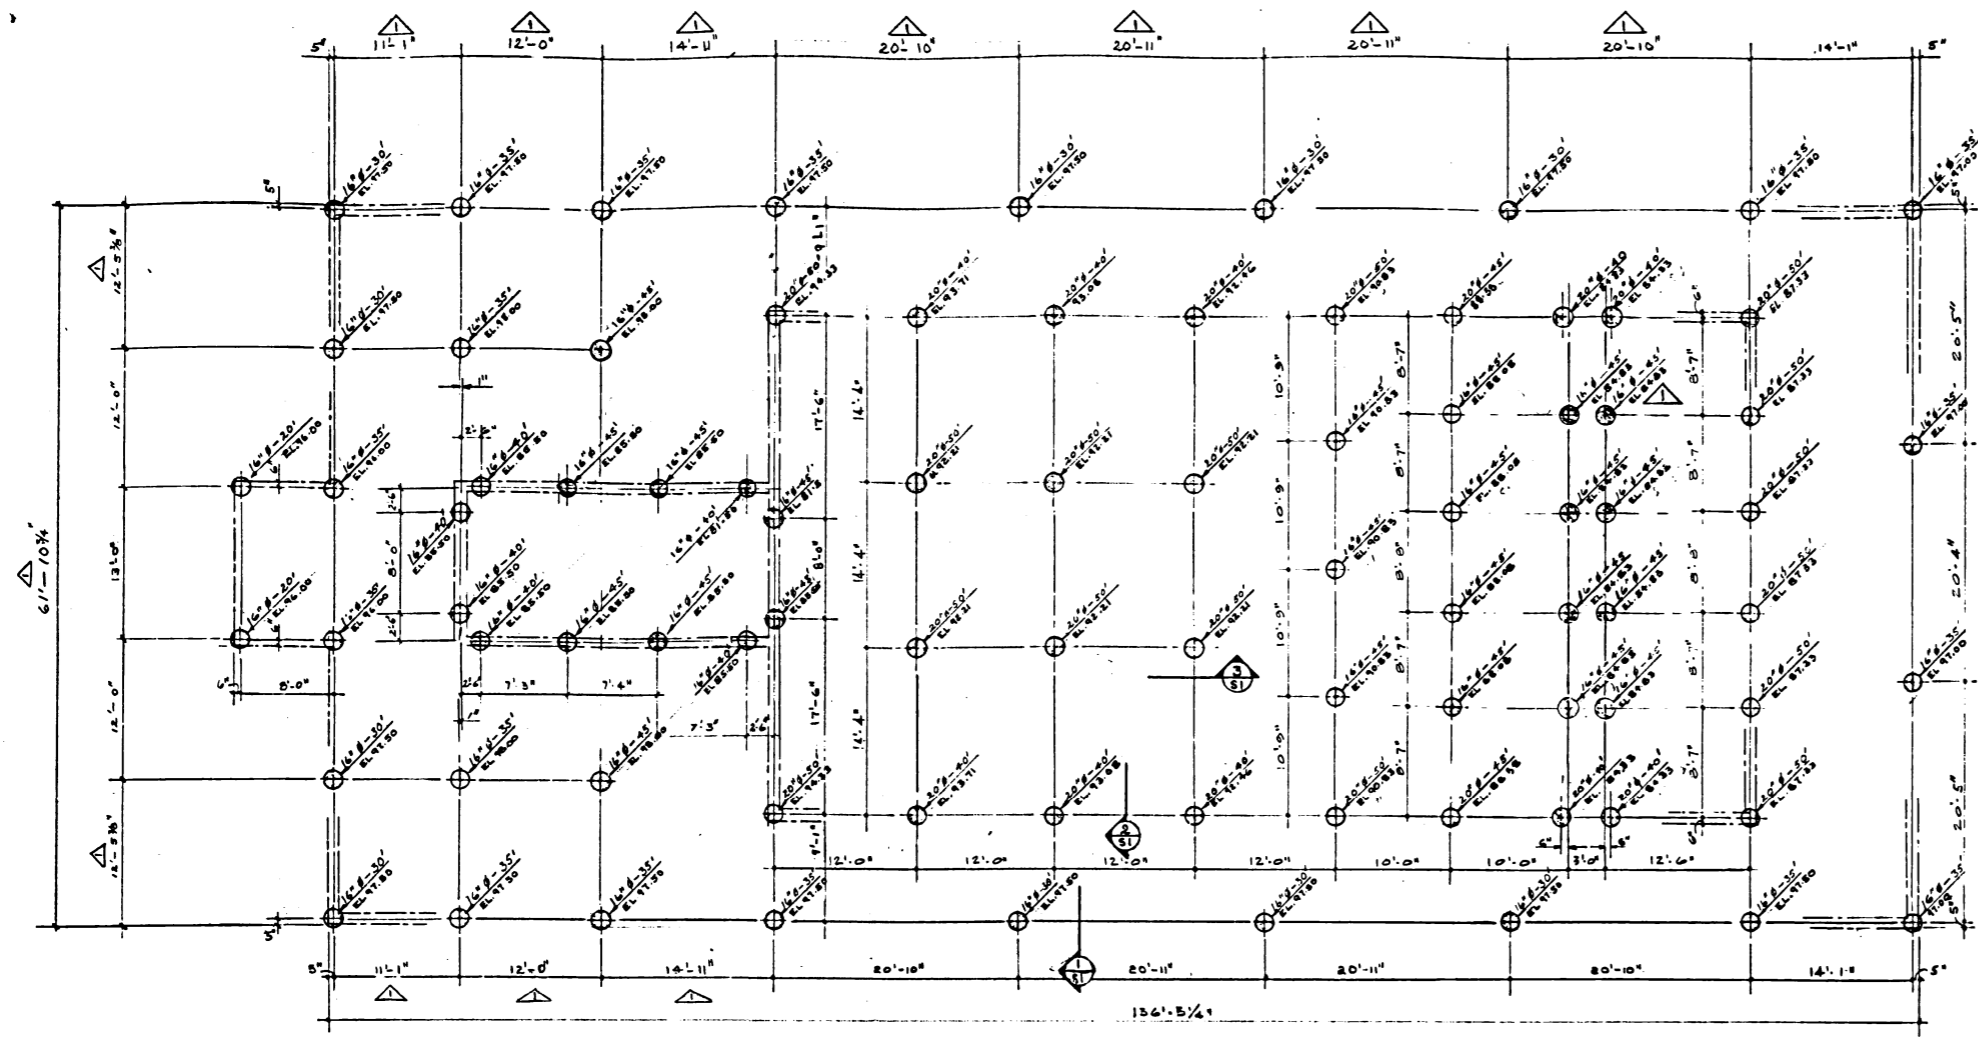


PILE LAYOUT
1/8" = 1'-0"

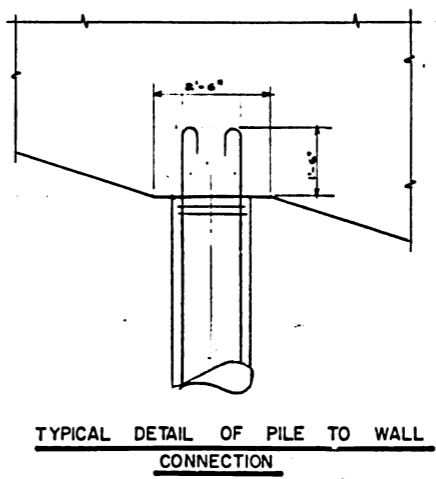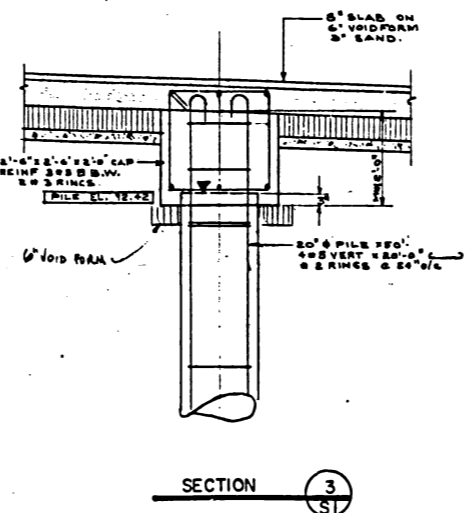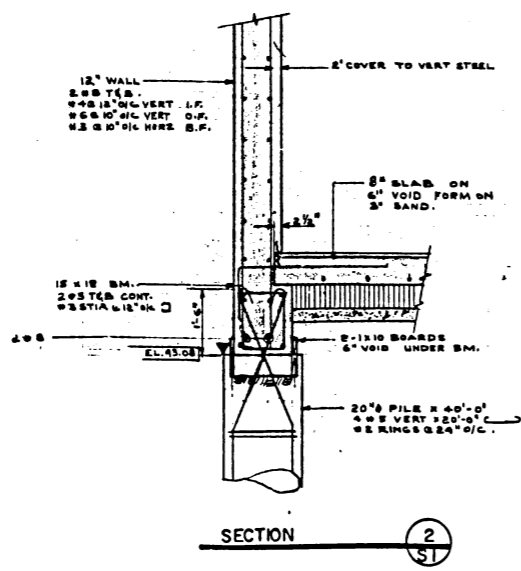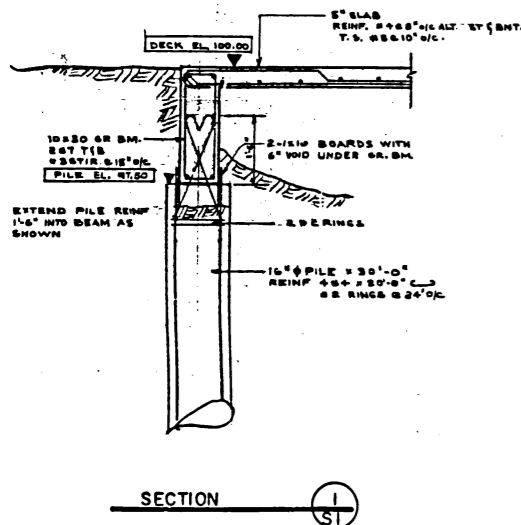

SCALE: ALL DETAILS 1/2" = 1'-0"

NO.	DESCRIPTION	DATE	DWN.	CHKD.

REVISIONS

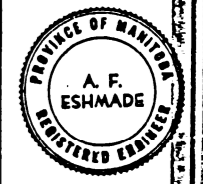

APPROVED BY: *[Signature]* DATE: 12/15/66


CITY OF ST. VITAL
CENTENNIAL SWIMMING POOL

PILE LAYOUT

UNDERWOOD McLELLAN & ASSOCIATES
LIMITED


CONSULTING PROFESSIONAL ENGINEERS
MANITOBA SASKATCHEWAN ALBERTA BRITISH COLUMBIA

DRAWN BY: R.S.H.	DESIGNED BY: <i>[Signature]</i>
CHECKED BY: <i>[Signature]</i>	CHECKED BY: <i>[Signature]</i>
DATE DRAWN: AUGUST 12th. 1966	SCALE: AS SHOWN
JOB NO. 23-638-02	DRAWING NO. S-1
SHEET 7 OF 14	

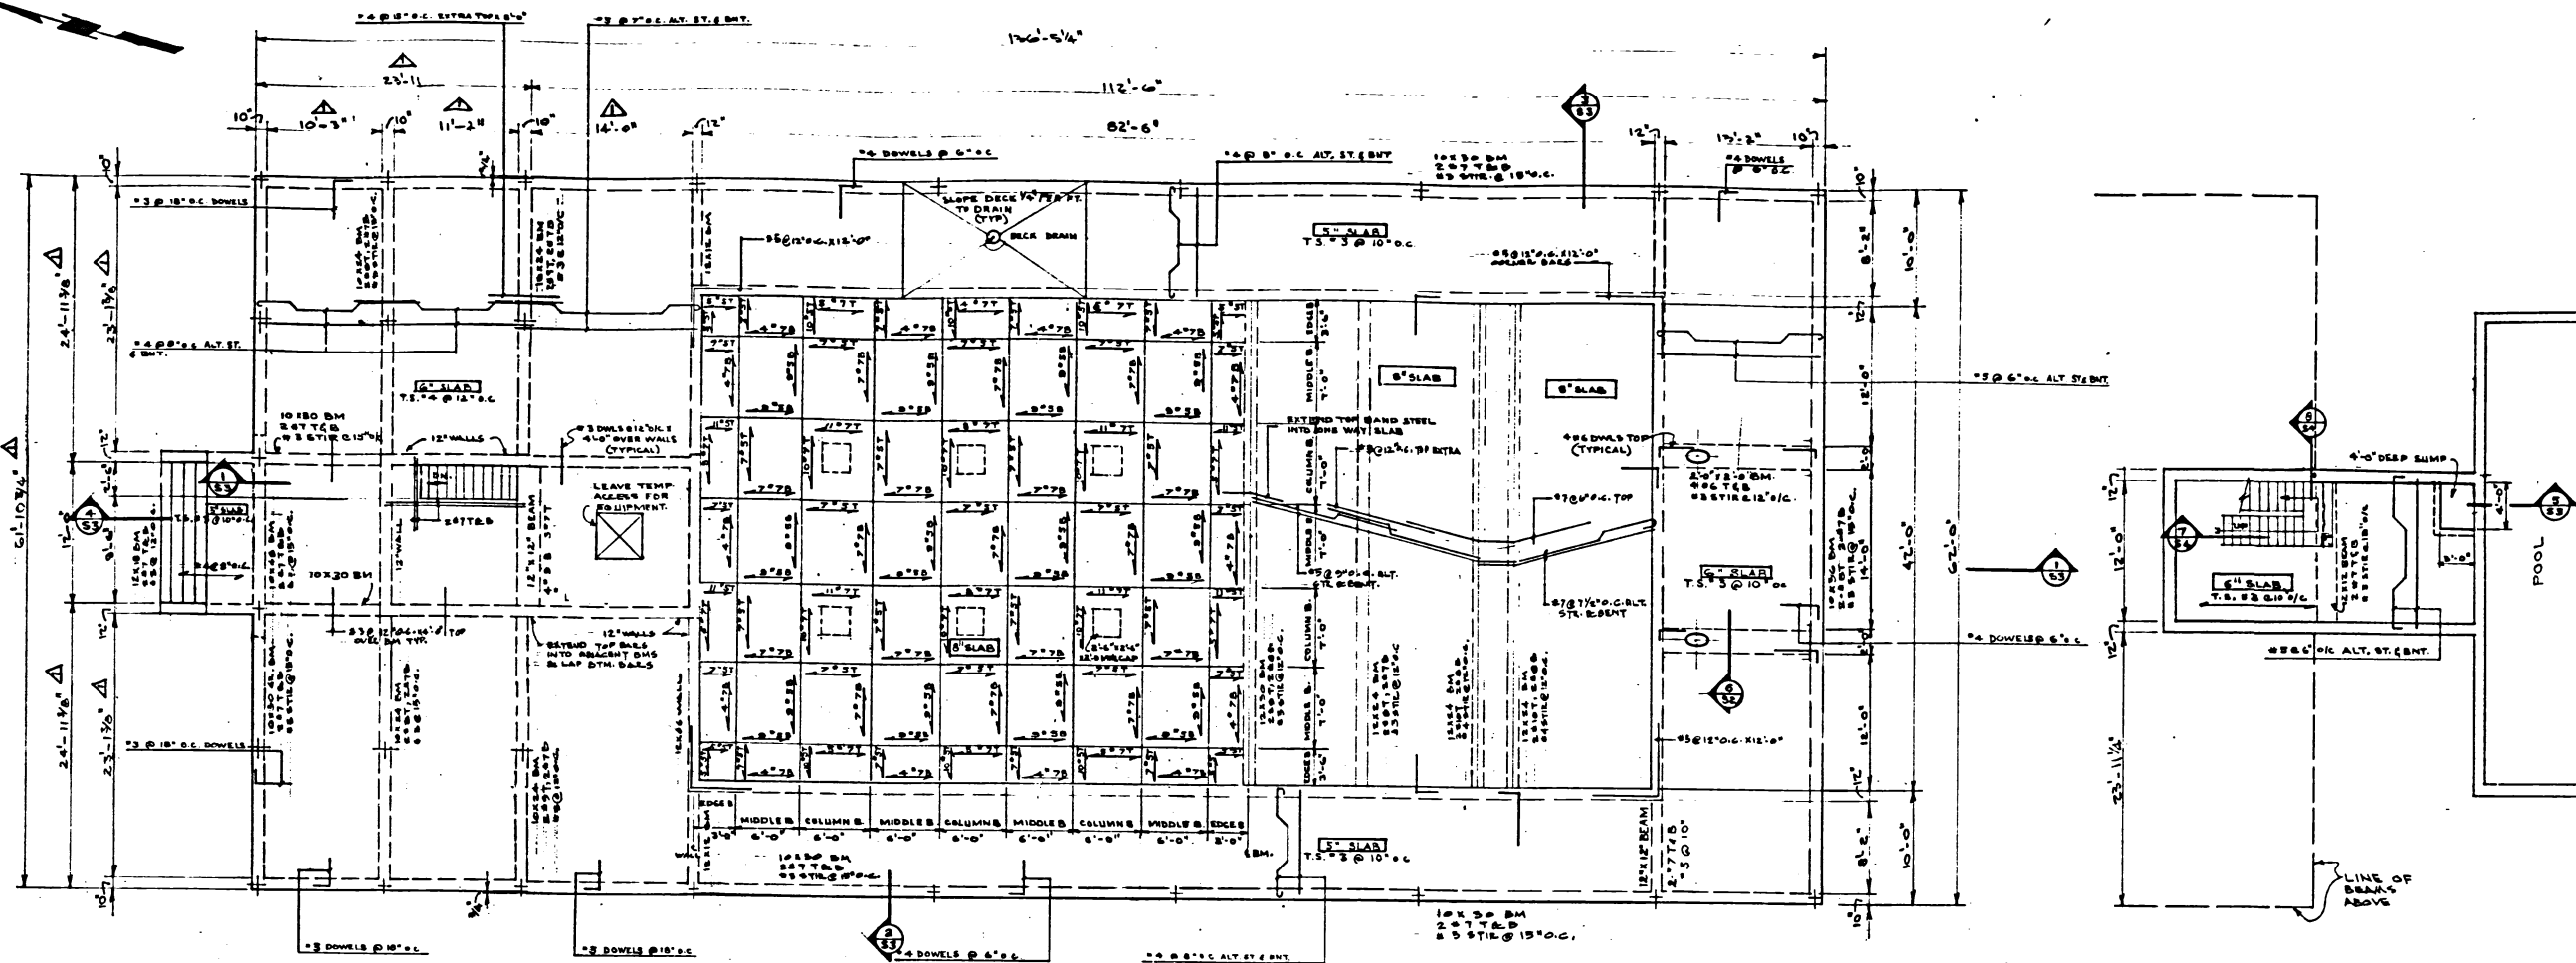


° FLOOR PLAN °
SCALE 1/8" = 1'-0"

° MECHANICAL ROOM PLAN °
SCALE 1/8" = 1'-0"

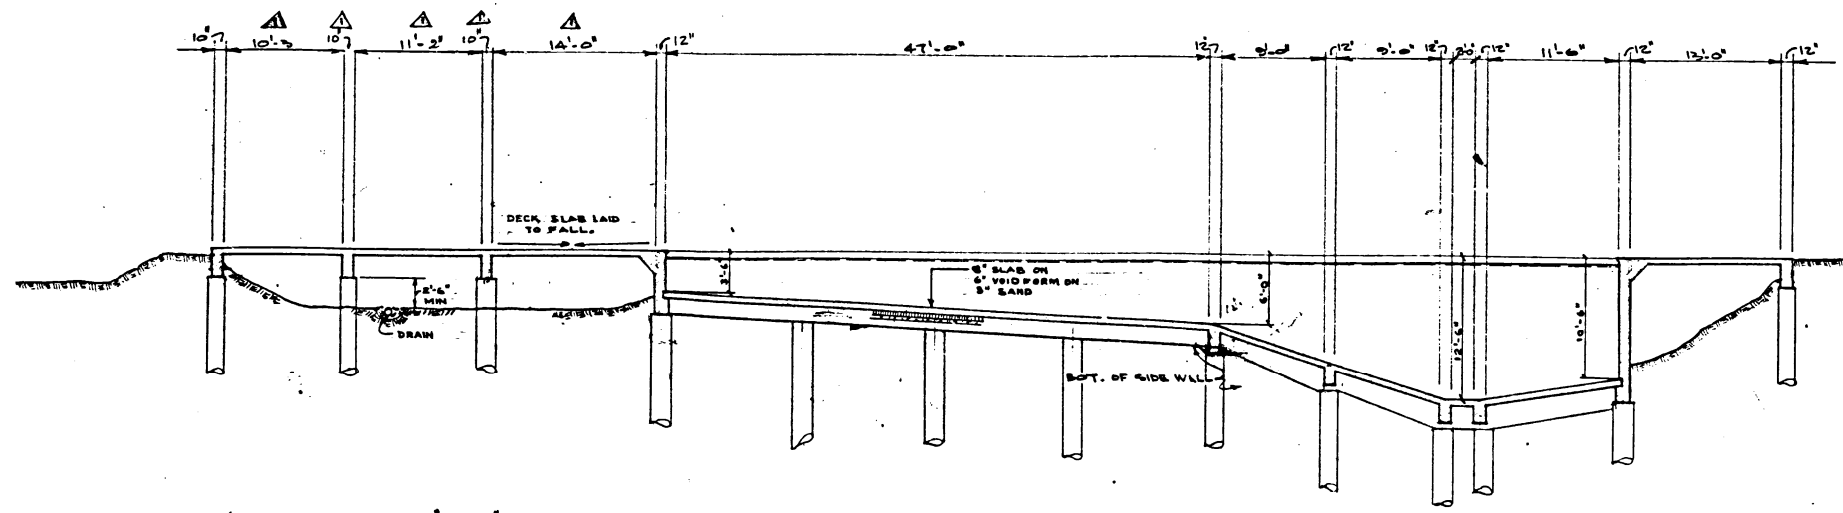



° SECTION - A-A °
SCALE 1/8" = 1'-0"

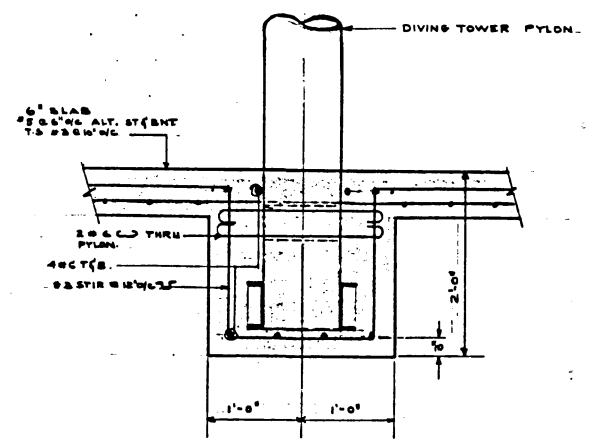


SECTION 6-6
SCALE 1/8" = 1'-0"

REVISIONS			
NO.	DESCRIPTION	DATE	CHK.

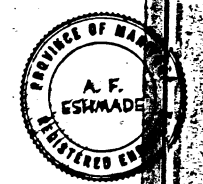
	
APPROVED BY: <i>[Signature]</i> DATE: 12/16/66	DRAWN BY: H. J. McLELLAN
CITY OF ST. VITAL CENTENNIAL SWIMMING POOL	
FOUNDATION DETAILS	
UNDERWOOD McLELLAN & ASSOCIATES LIMITED CONSULTING PROFESSIONAL ENGINEERS MANITOBA SASKATCHEWAN ALBERTA BRITISH COLUMBIA	
DATE DRAWN: AUGUST 12TH 1966 JOB NO. 23-638-02	SCALE: AS SHOWN DRAWING NO. S-2
SHEET 8 OF 14	

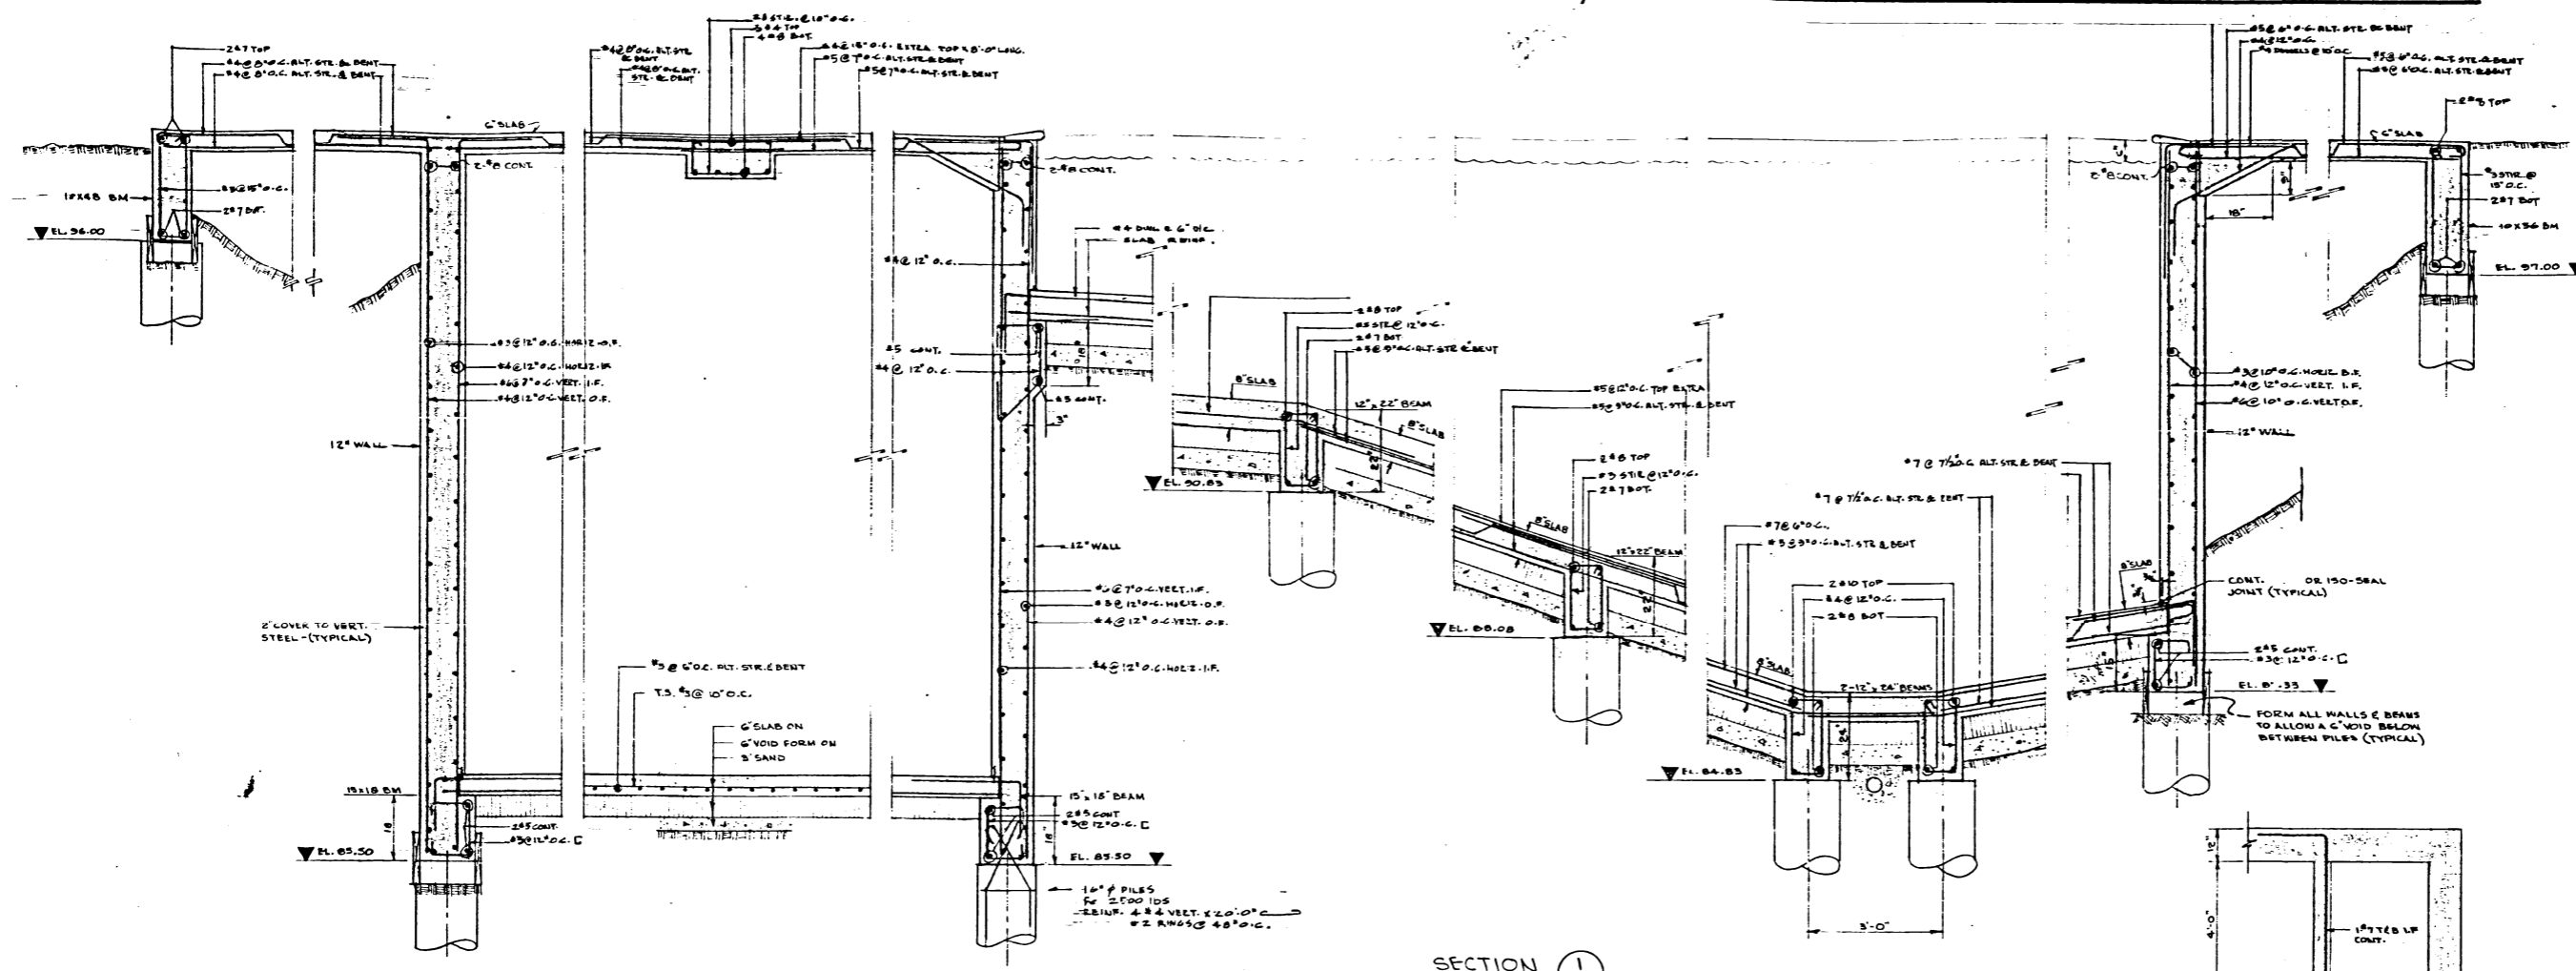


SECTION 1
SCALE: 1/2" = 1'-0"

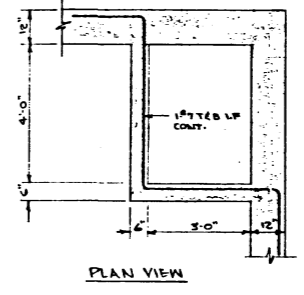


PLAN VIEW

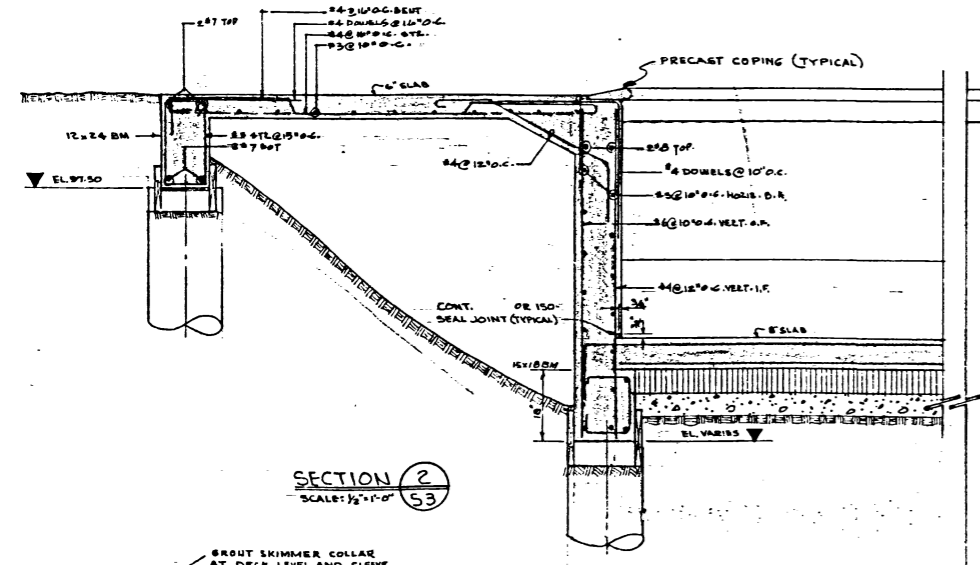


SECTION 2
SCALE: 1/2" = 1'-0"

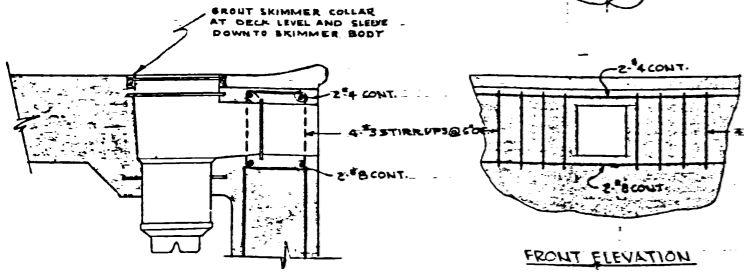


FRONT ELEVATION

 


SECTION THRU SKIMMER
SCALE: 1" = 1'-0"

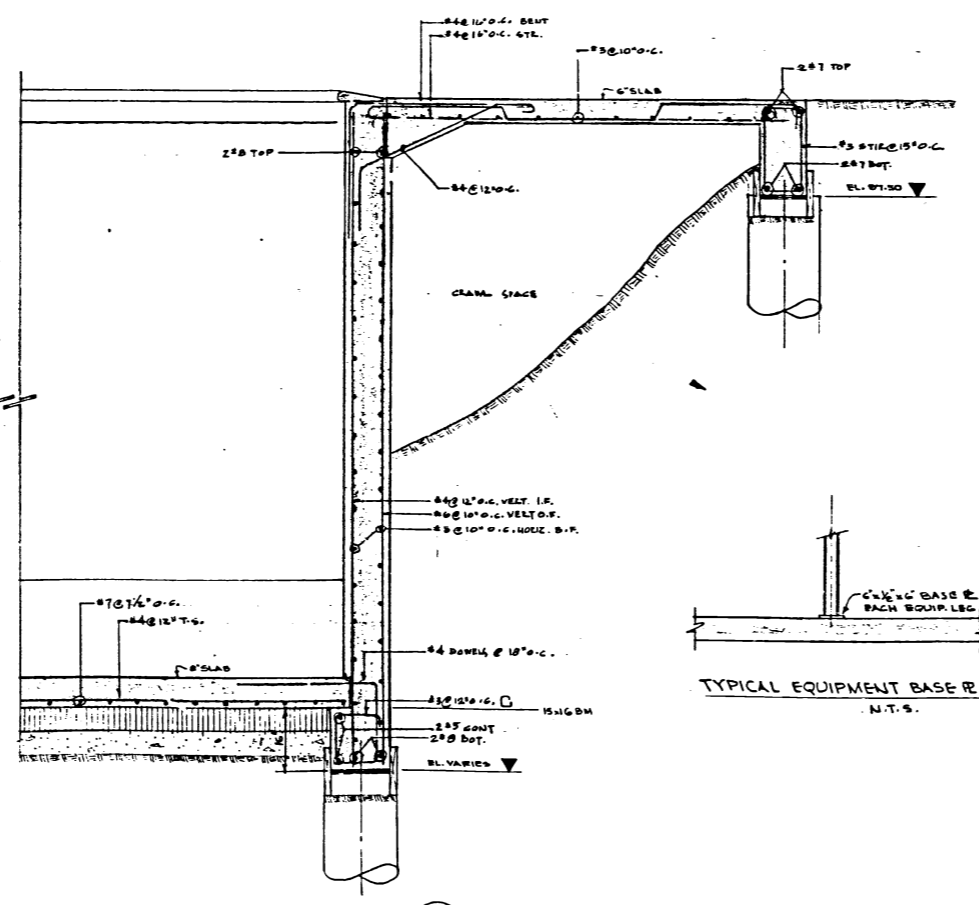


SECTION 3
SCALE: 1/2" = 1'-0"

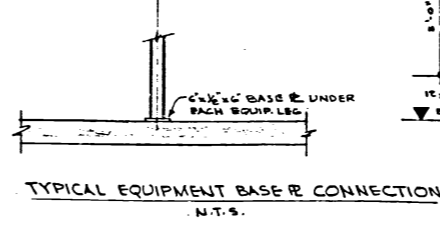


TYPICAL EQUIPMENT BASE CONNECTION
N.T.S.

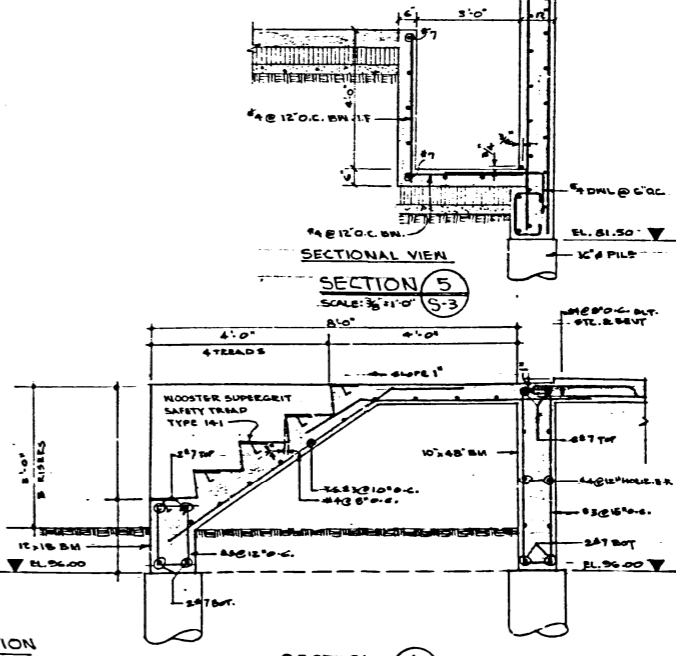

SECTION 4
SCALE: 1/2" = 1'-0"

 

SECTION 5
SCALE: 1/2" = 1'-0"

NO.	DESCRIPTION	DATE	DWNL	CHK
REVISIONS				
				
APPROVED BY <i>L. Hunt</i>		DATE 12/8/16		
CITY OF ST. VITAL				
CENTENNIAL SWIMMING POOL				
SECTIONS 8 DETAILS				
UNDERWOOD McLELLAN & ASSOCIATES LIMITED				
CONSULTING PROFESSIONAL ENGINEERS				
MANITOBA SASKATCHEWAN ALBERTA BRITISH COLUMBIA				
DRAWN BY H.L.H.G.	DESIGNED BY AFE			
CHECKED BY	CHECKED BY AFE			
DATE DRAWN AUGUST 12TH, 1966	SCALE AS SHOWN			
JOB NO. 23-638-02	DRAWING NO. S-3			
SHEET 9 OF 14				