



**EAST ELEVATION**  
SCALE : 1:50

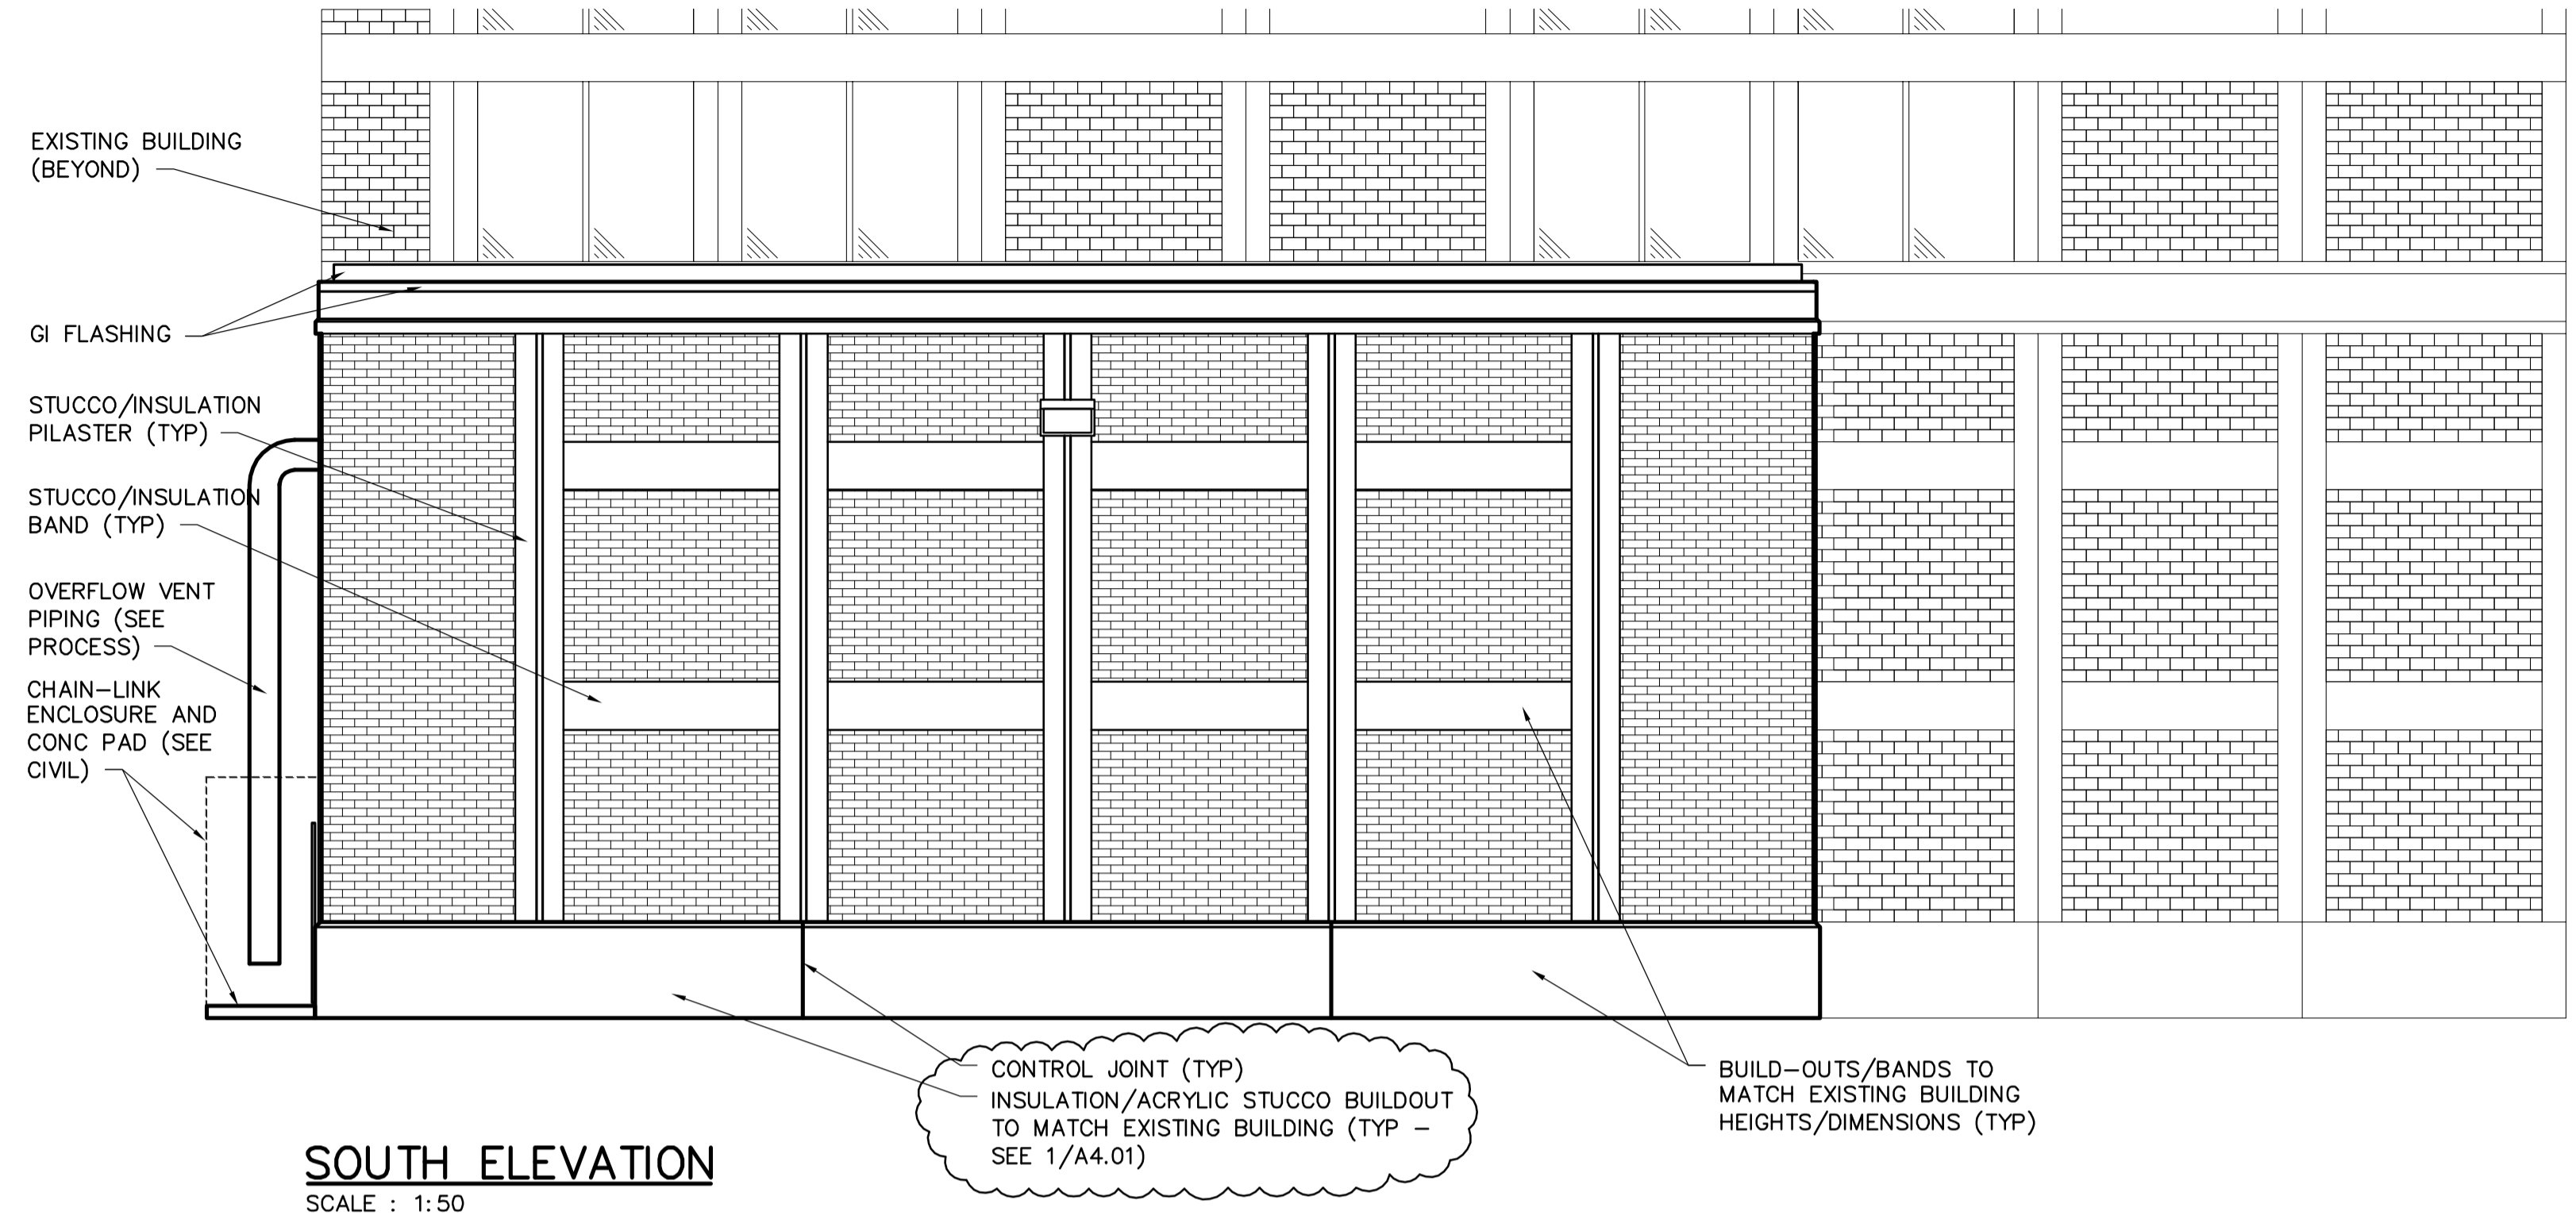

**SOUTH ELEVATION**  
SCALE : 1:50

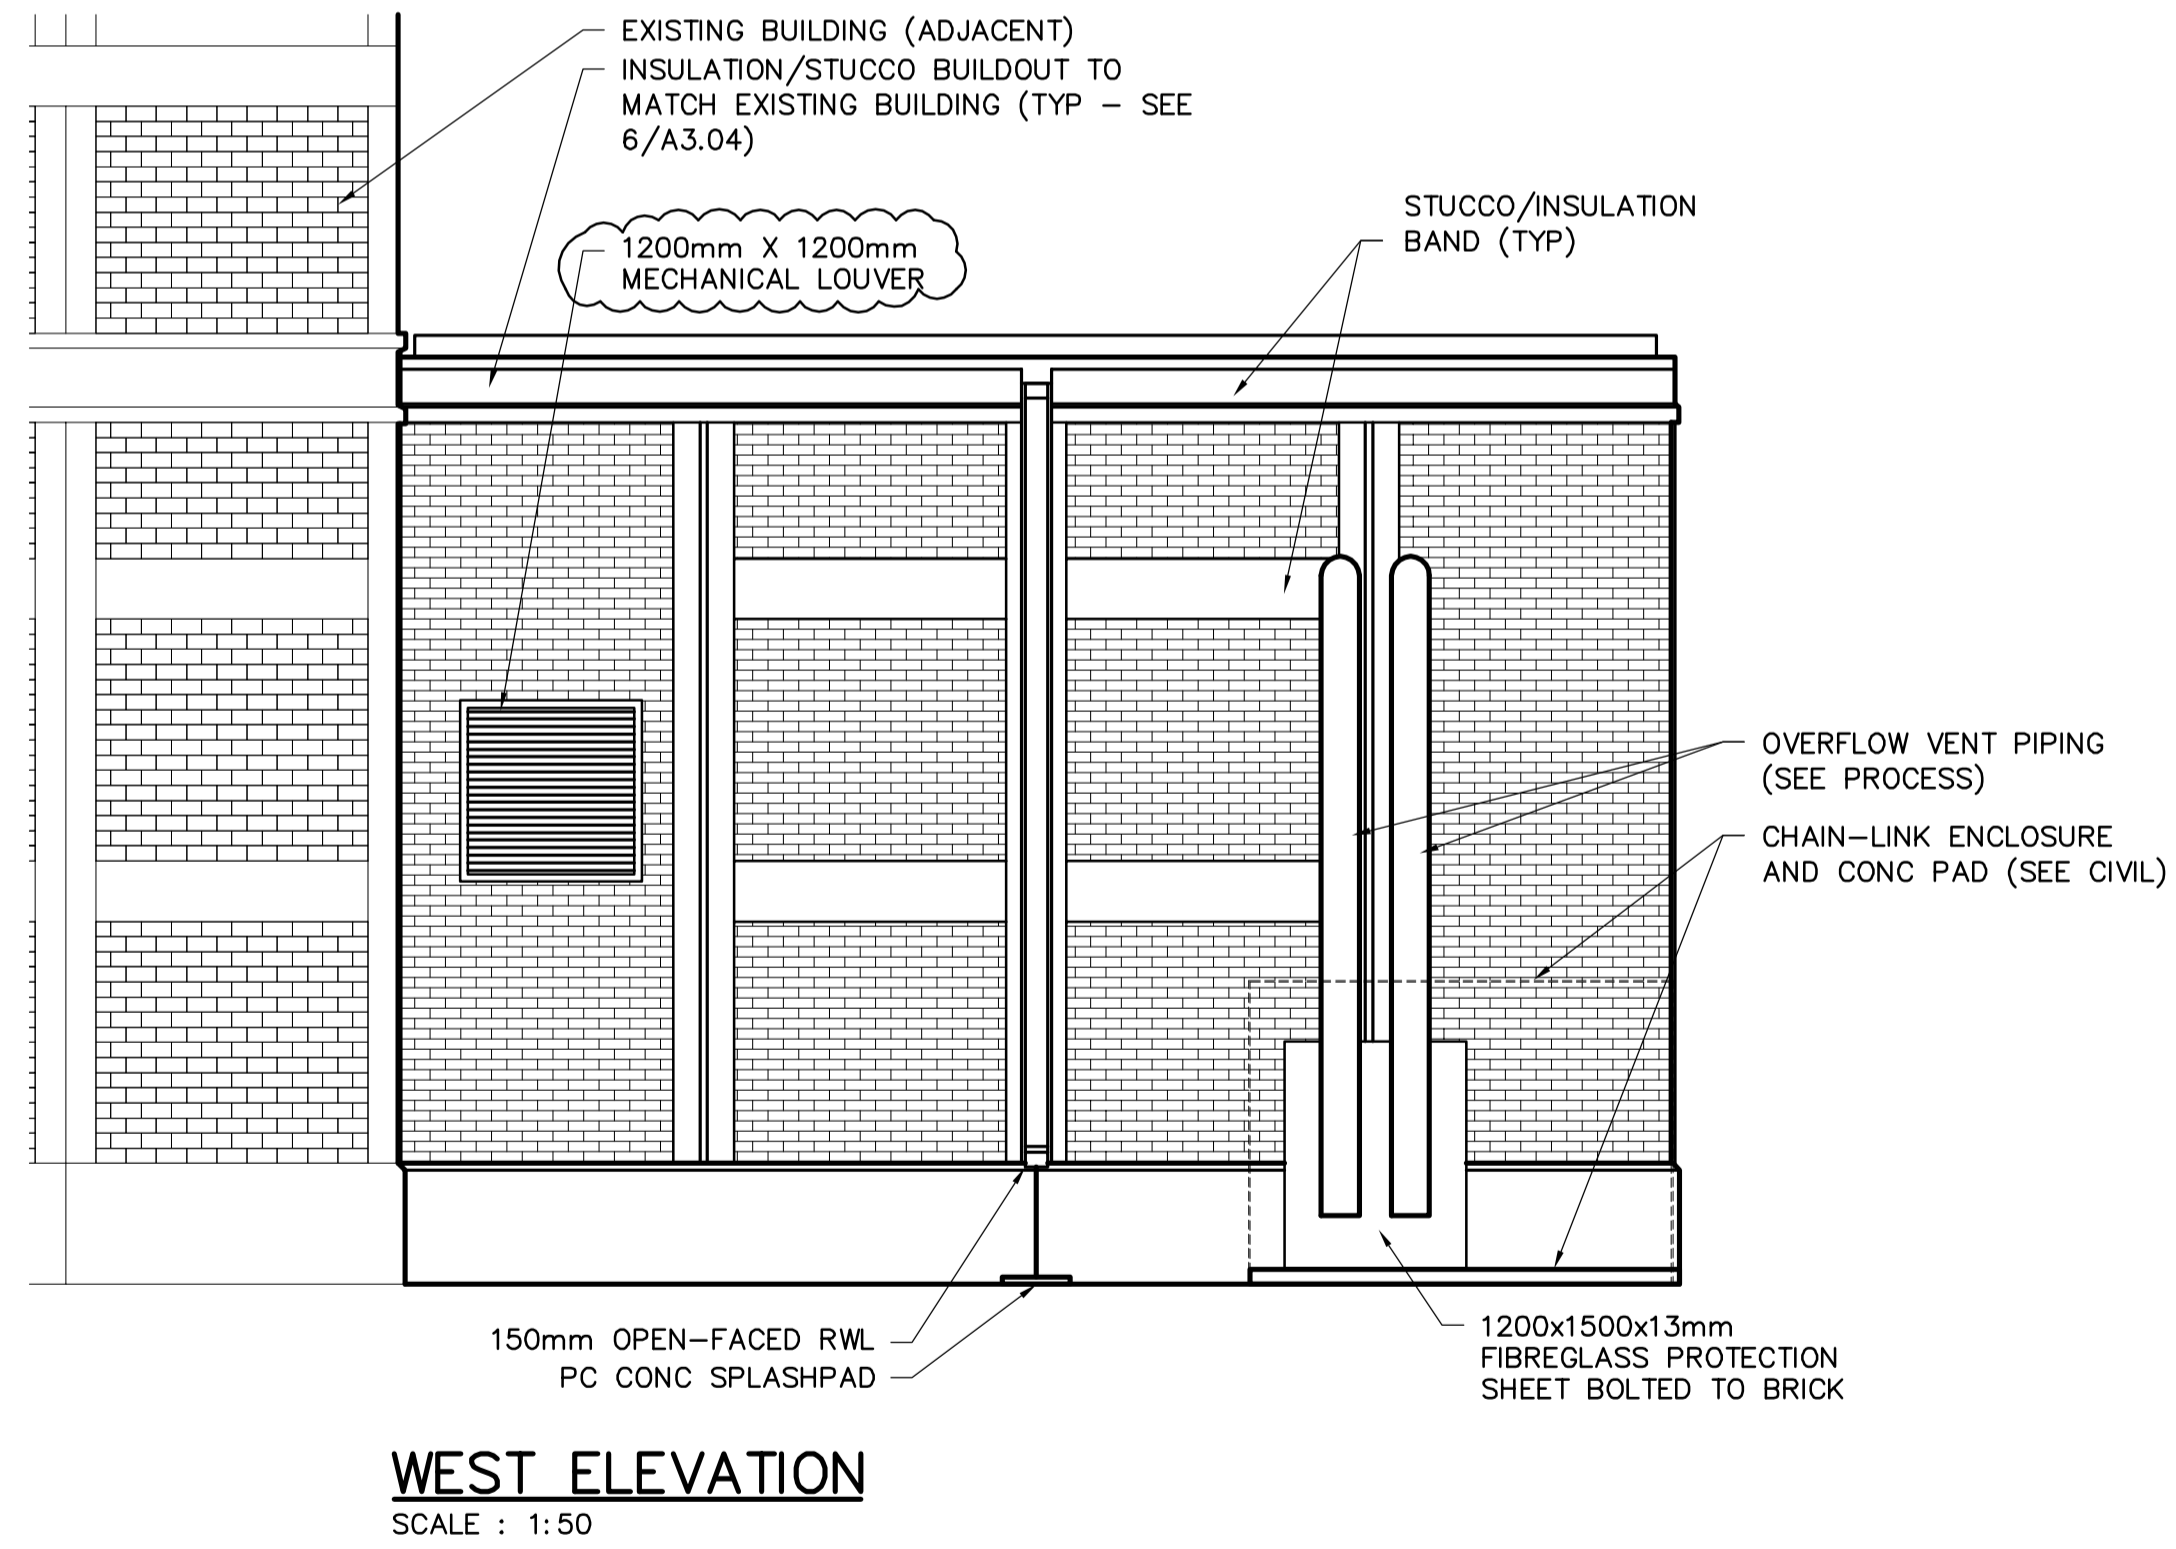

**WEST ELEVATION**  
SCALE : 1:50



NO.	REVISIONS	DATE	BY
01	611-2005 ADDENDUM 1	06/01/13	LK
00	ISSUED FOR TENDER	05/12/2	LK

**EarthTech**  
A Tyco International Ltd. Company

DESIGNED BY: NC	CHECKED BY: NC
DRAWN BY: LK	APPROVED BY: D. TANIGUCHI
SCALE: AS SHOWN	RELEASED FOR CONSTRUCTION BY: K. MARTENS
DATE: 2005/09/16	DATE: 05/12/02



**THE CITY OF WINNIPEG**  
WATER AND WASTE DEPARTMENT  
ENGINEERING DIVISION

NEWPCC CENTRATE NUTRIENT TREATMENT  
PHOSPHORUS REMOVAL FACILITY  
CONTRACT No. 1

ARCHITECTURAL  
CHEMICAL STORAGE BUILDING  
EXTERIOR ELEVATIONS

CITY FILE NUMBER  
SHEET 2 OF 4  
CITY DRAWING NUMBER  
1-010F-A-B0006-001-01-D