




1 TYPICAL WALL SECTION
 A3.03/A3.04 SCALE 1:10

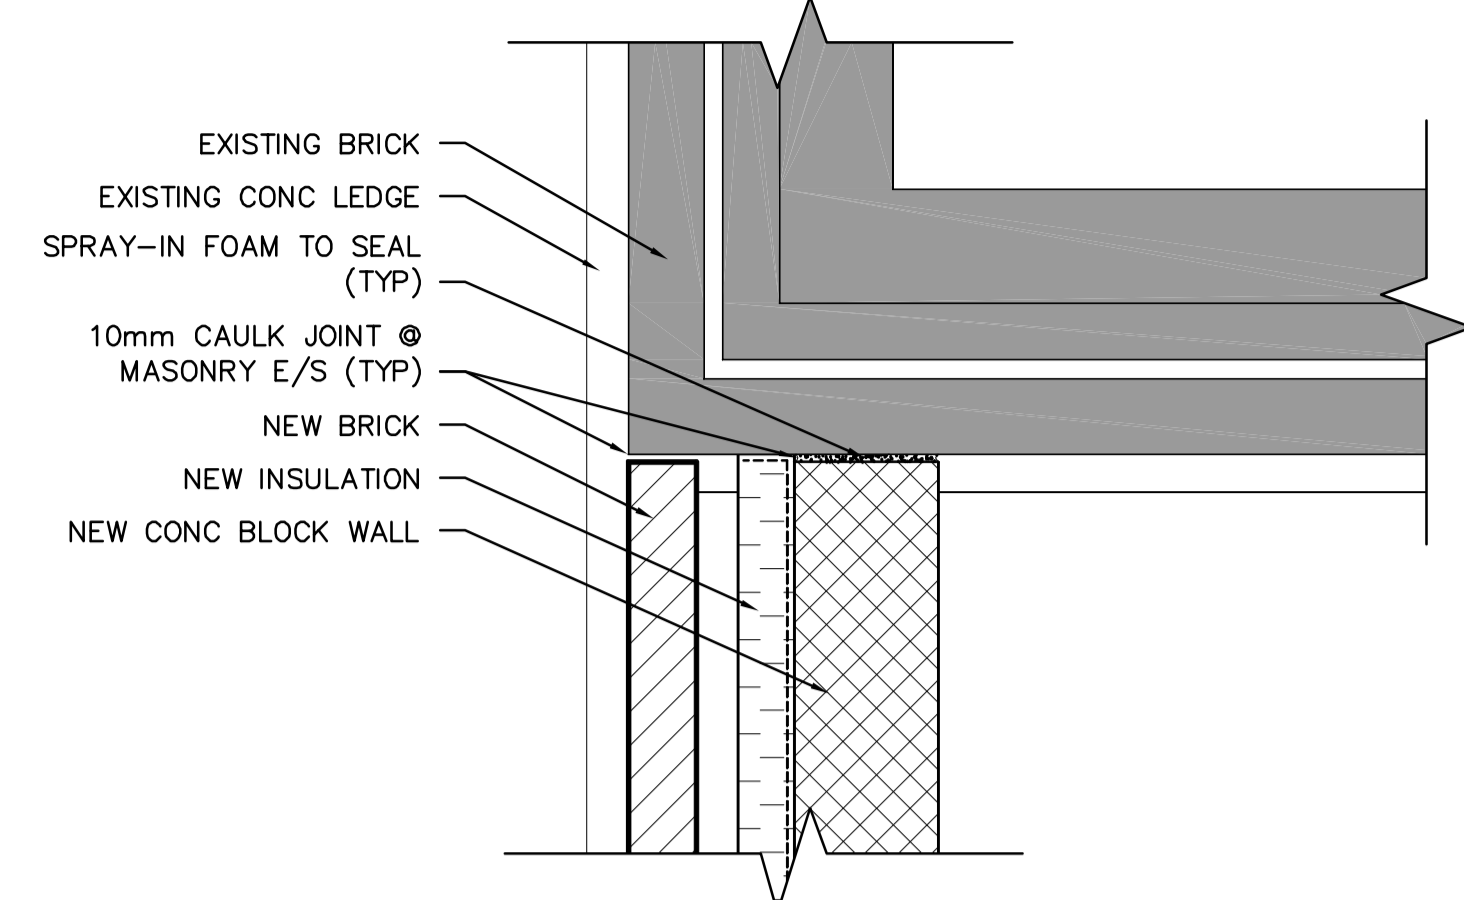


2 WEST BUILDING CONNECTION DETAIL
 A3.01/A3.04 SCALE 1:10

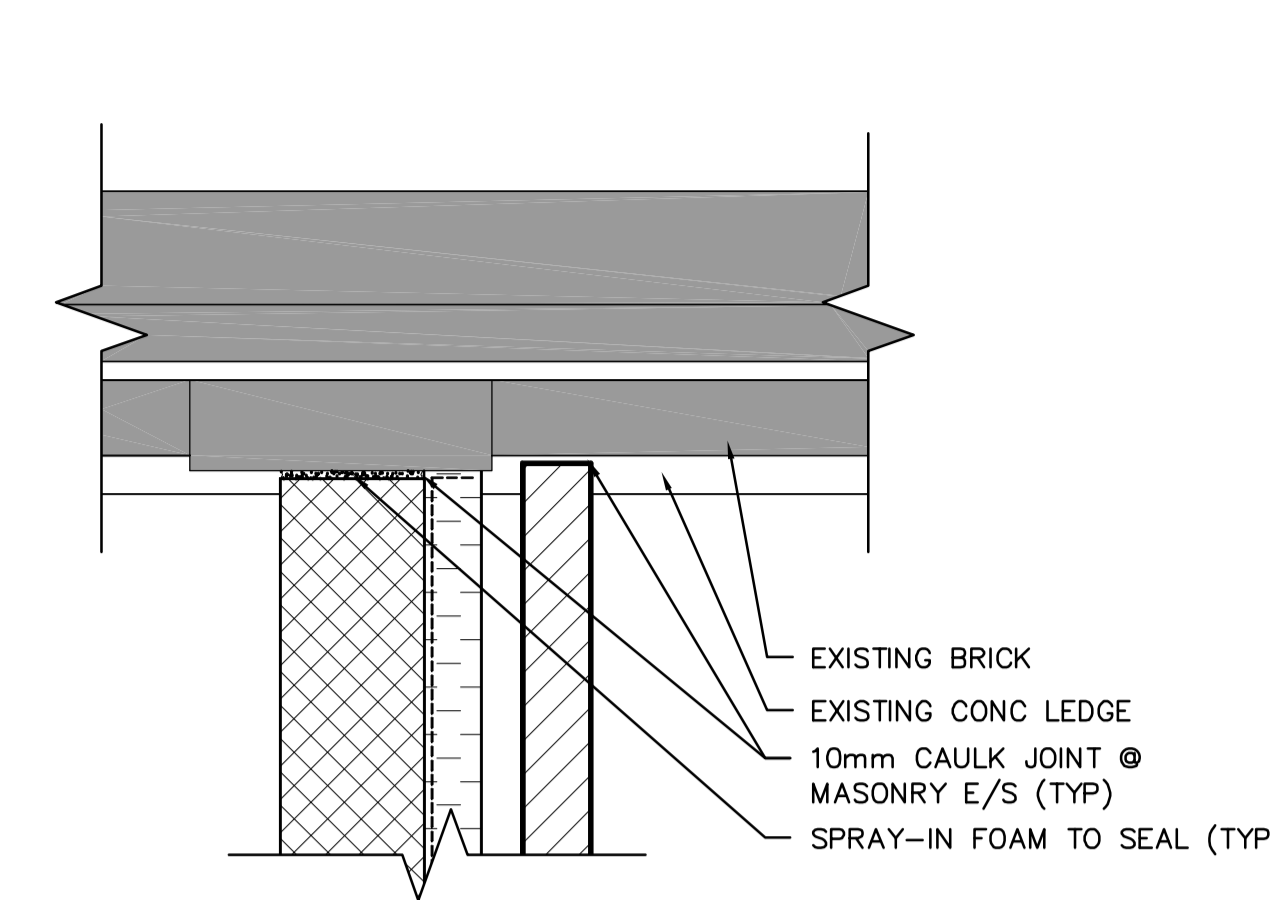


3 EAST BUILDING CONNECTION DETAIL
 A3.01/A3.04 SCALE 1:10

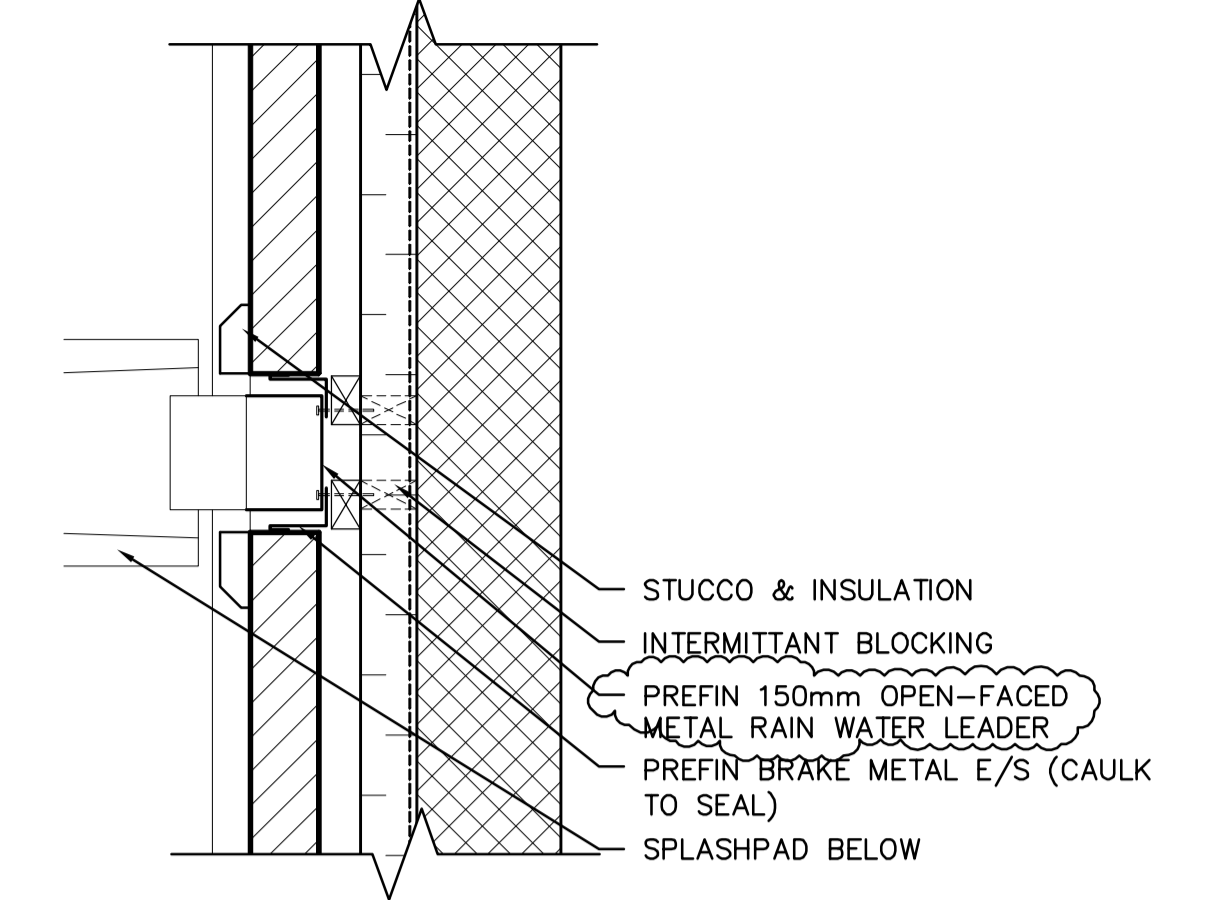


4 RAIN WATER LDR PLAN DETAIL
 A3.01/A3.04 SCALE 1:10

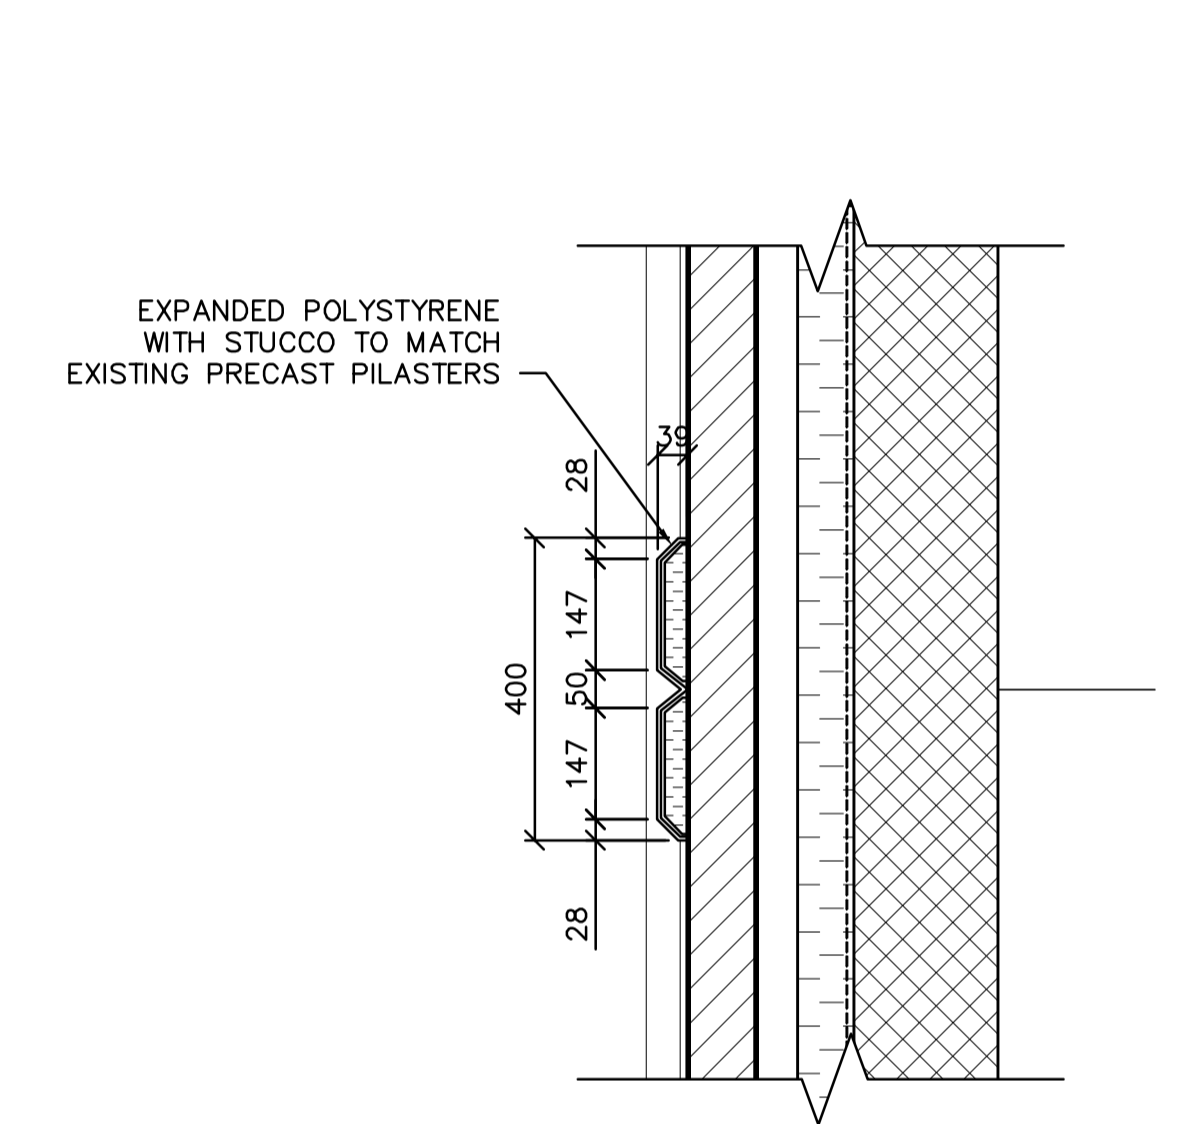


5 TYP STUCCO PILASTER PLAN DETAIL
 A3.01/A3.04 SCALE 1:10

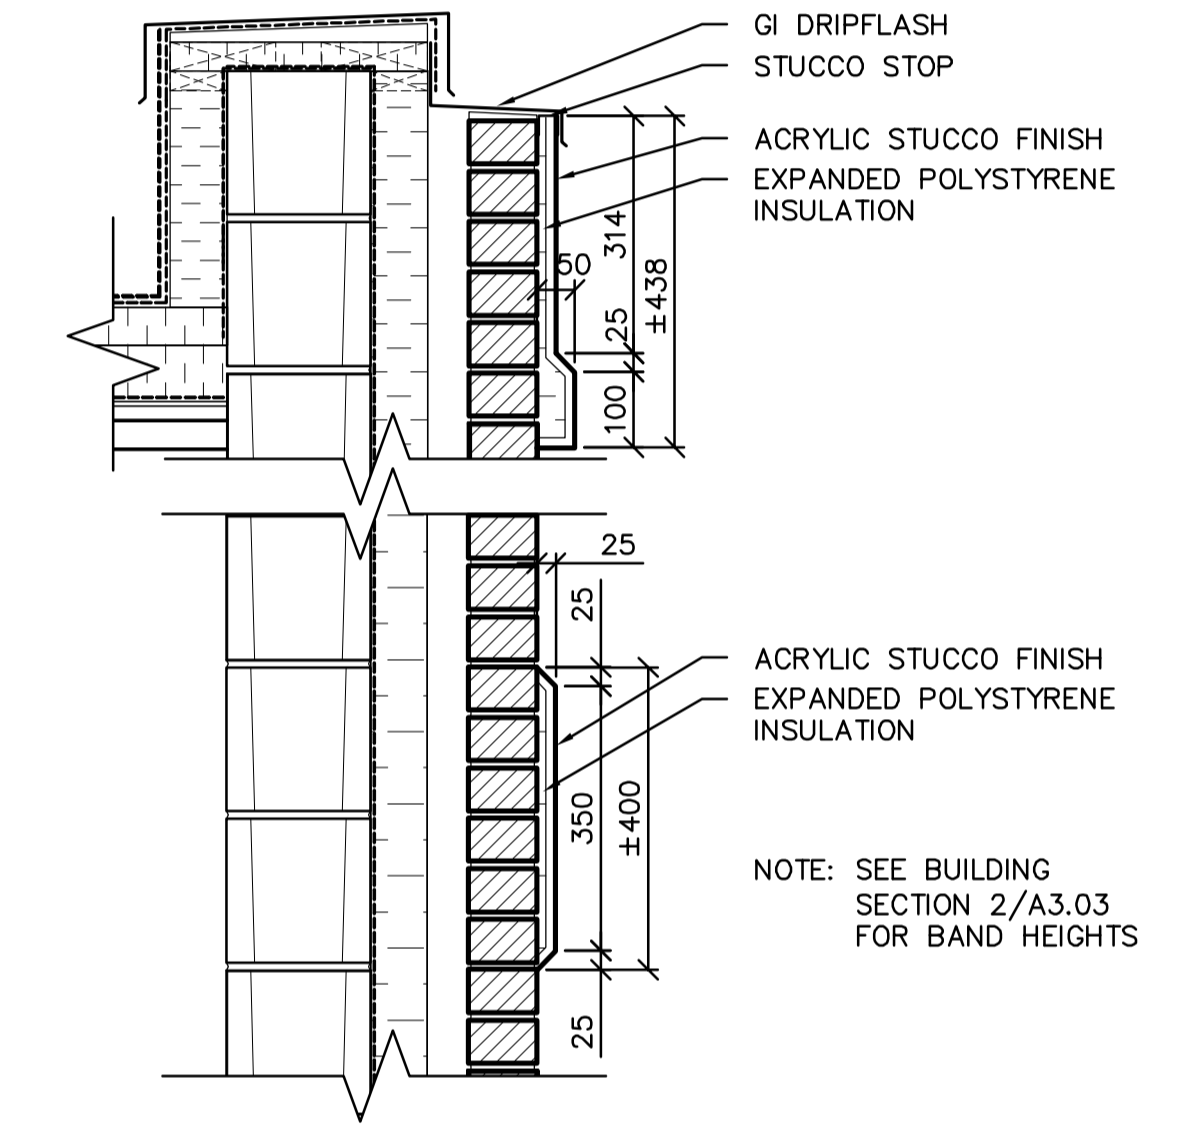


6 TYP STUCCO BAND SECTION DETAIL
 A3.03/A3.04 SCALE 1:10

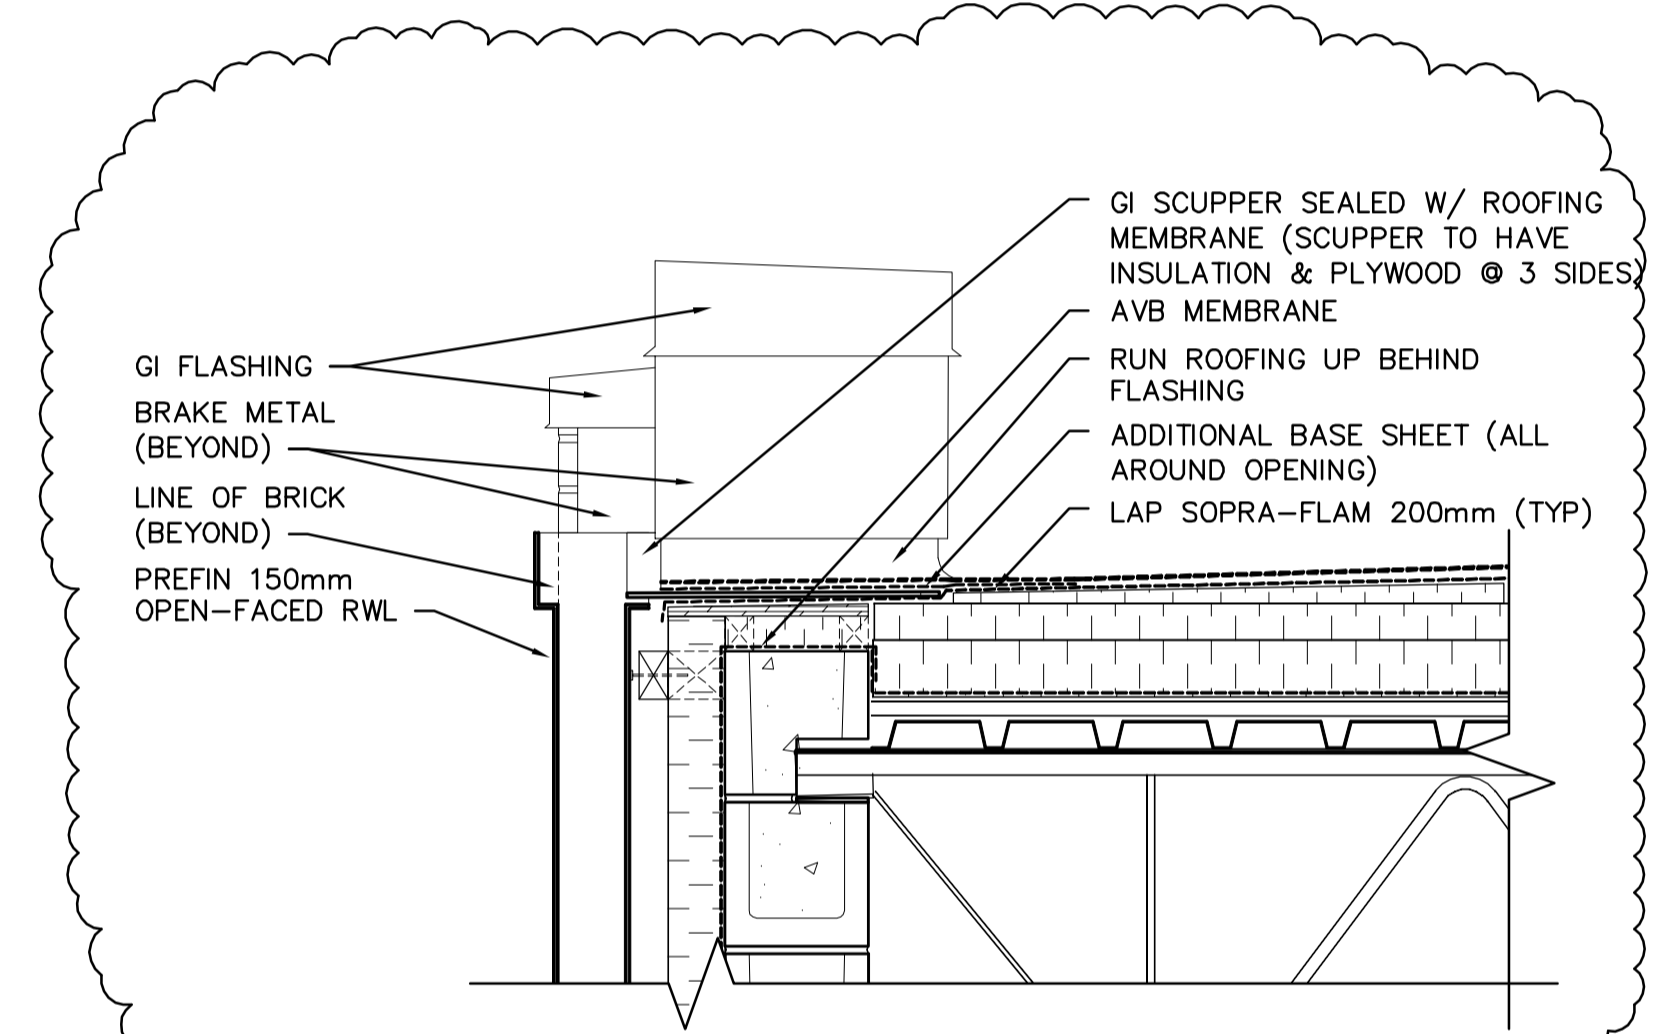

7 SCUPPER DETAIL
 A3.03/A3.04 SCALE 1:10

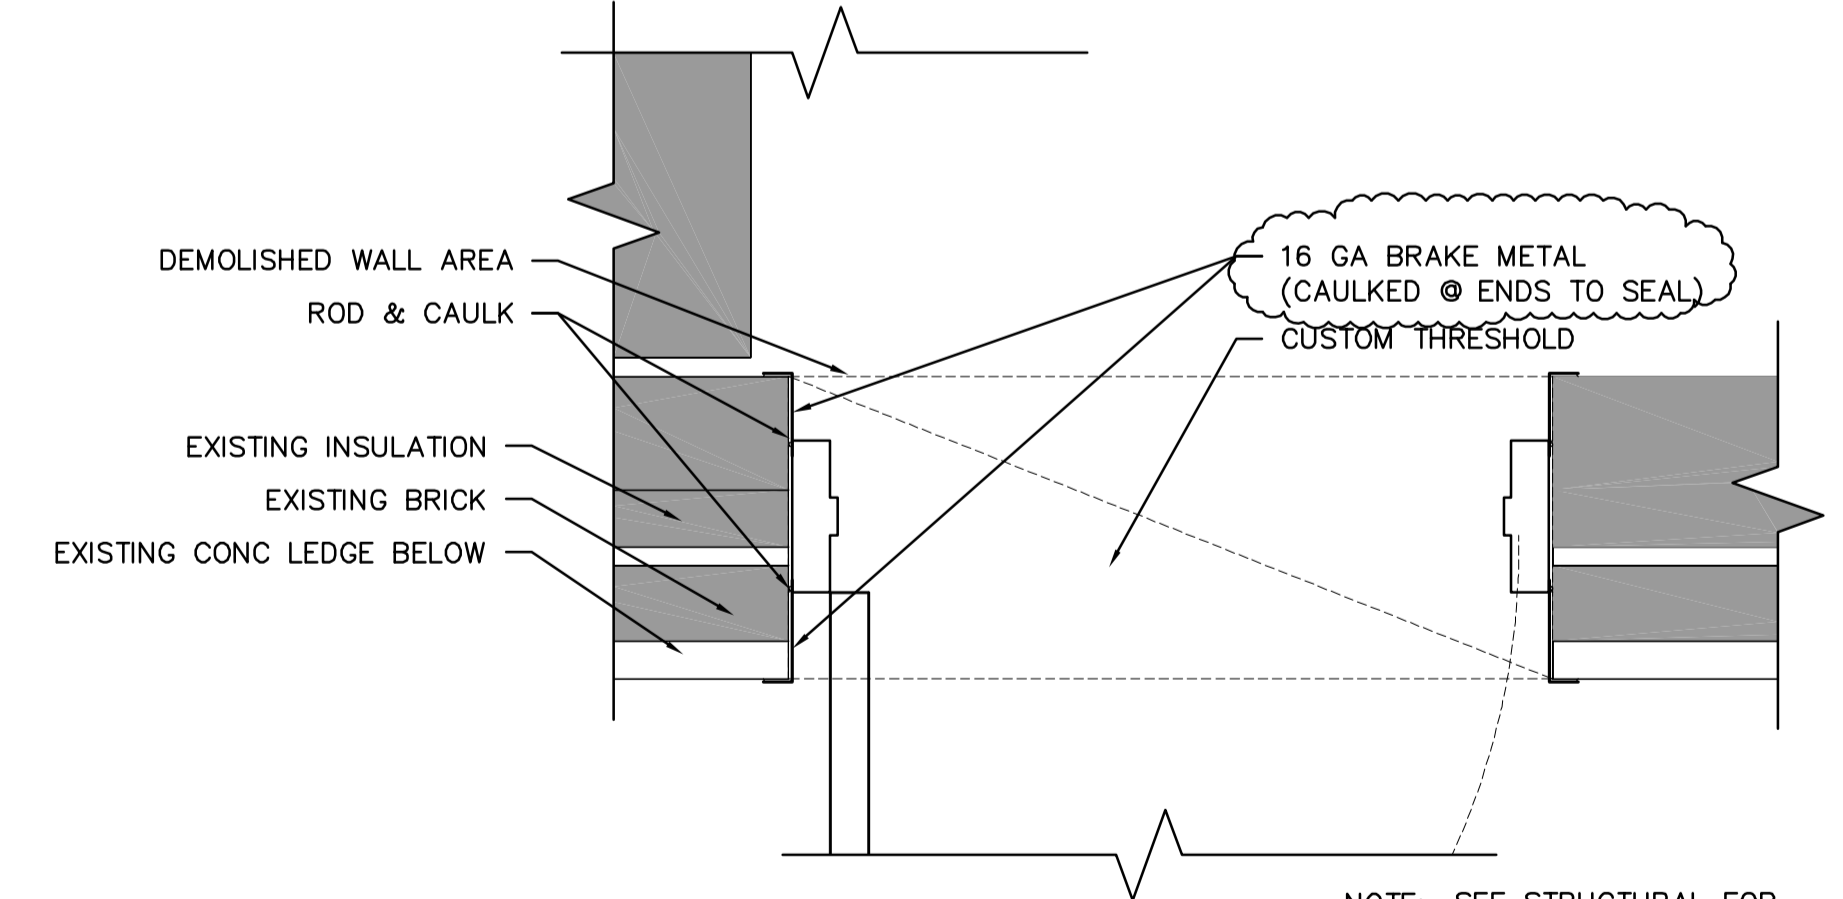

8 DOOR FRAME DETAIL
 A3.01/A3.04 SCALE 1:10

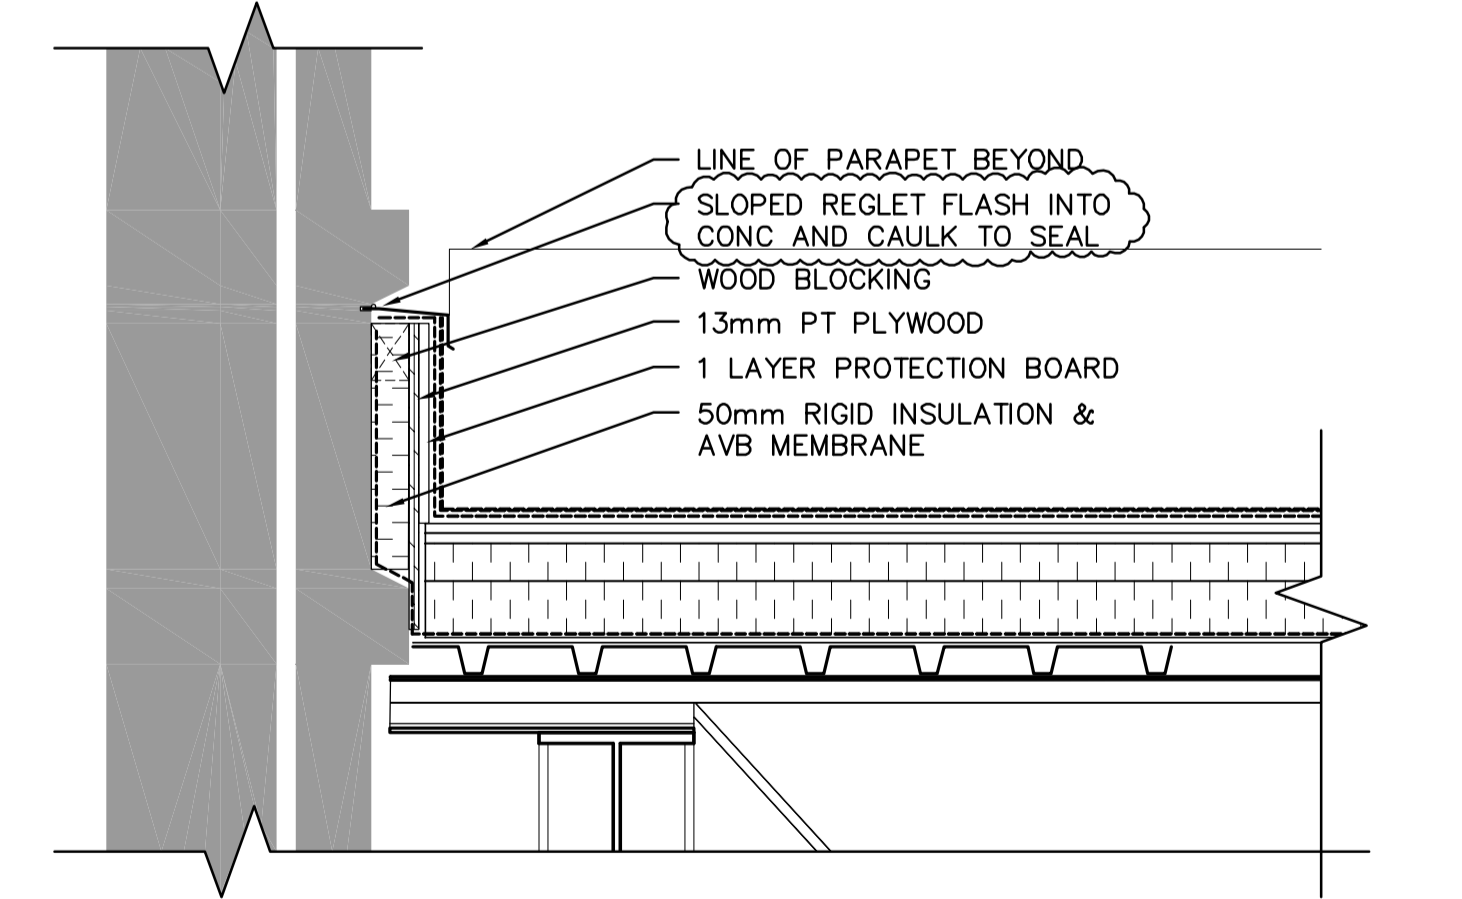

9 ROOF TIE-IN DETAIL
 A3.03/A3.04 SCALE 1:10



| | | | | | |
|-------------|---------------------|---------------------------------------|----|--|----------|
| B.M. ELEV. | | A Tyco International Ltd. Company | | ENGINEER'S SEAL | |
| DESIGNED BY | NC | CHECKED BY | NC | DESIGNED BY: NC CHECKED BY: NC DRAWN BY: LK APPROVED BY: D. TANIGUCHI SCALE: AS SHOWN RELEASED FOR CONSTRUCTION BY: K. MARTENS NO. REVISIONS DATE BY DATE DATE DATE | |
| 0 | 611-2005 ADDENDUM 1 | 06/01/13 | LK | 2005/10/05 | 05/12/02 |
| 00 | ISSUED FOR TENDER | 05/12/2 | LK | 2005/10/05 | 05/12/02 |

THE CITY OF WINNIPEG
WATER AND WASTE DEPARTMENT
ENGINEERING DIVISION

NEWPCC CENTRATE NUTRIENT TREATMENT
 PHOSPHORUS REMOVAL FACILITY
 CONTRACT No. 1

ARCHITECTURAL
 CHEMICAL STORAGE BUILDING
 SECTIONS & DETAILS

CITY FILE NUMBER
 SHEET 4 OF 4
 CITY DRAWING NUMBER
 1-001F-A-B0008-001-01-D