

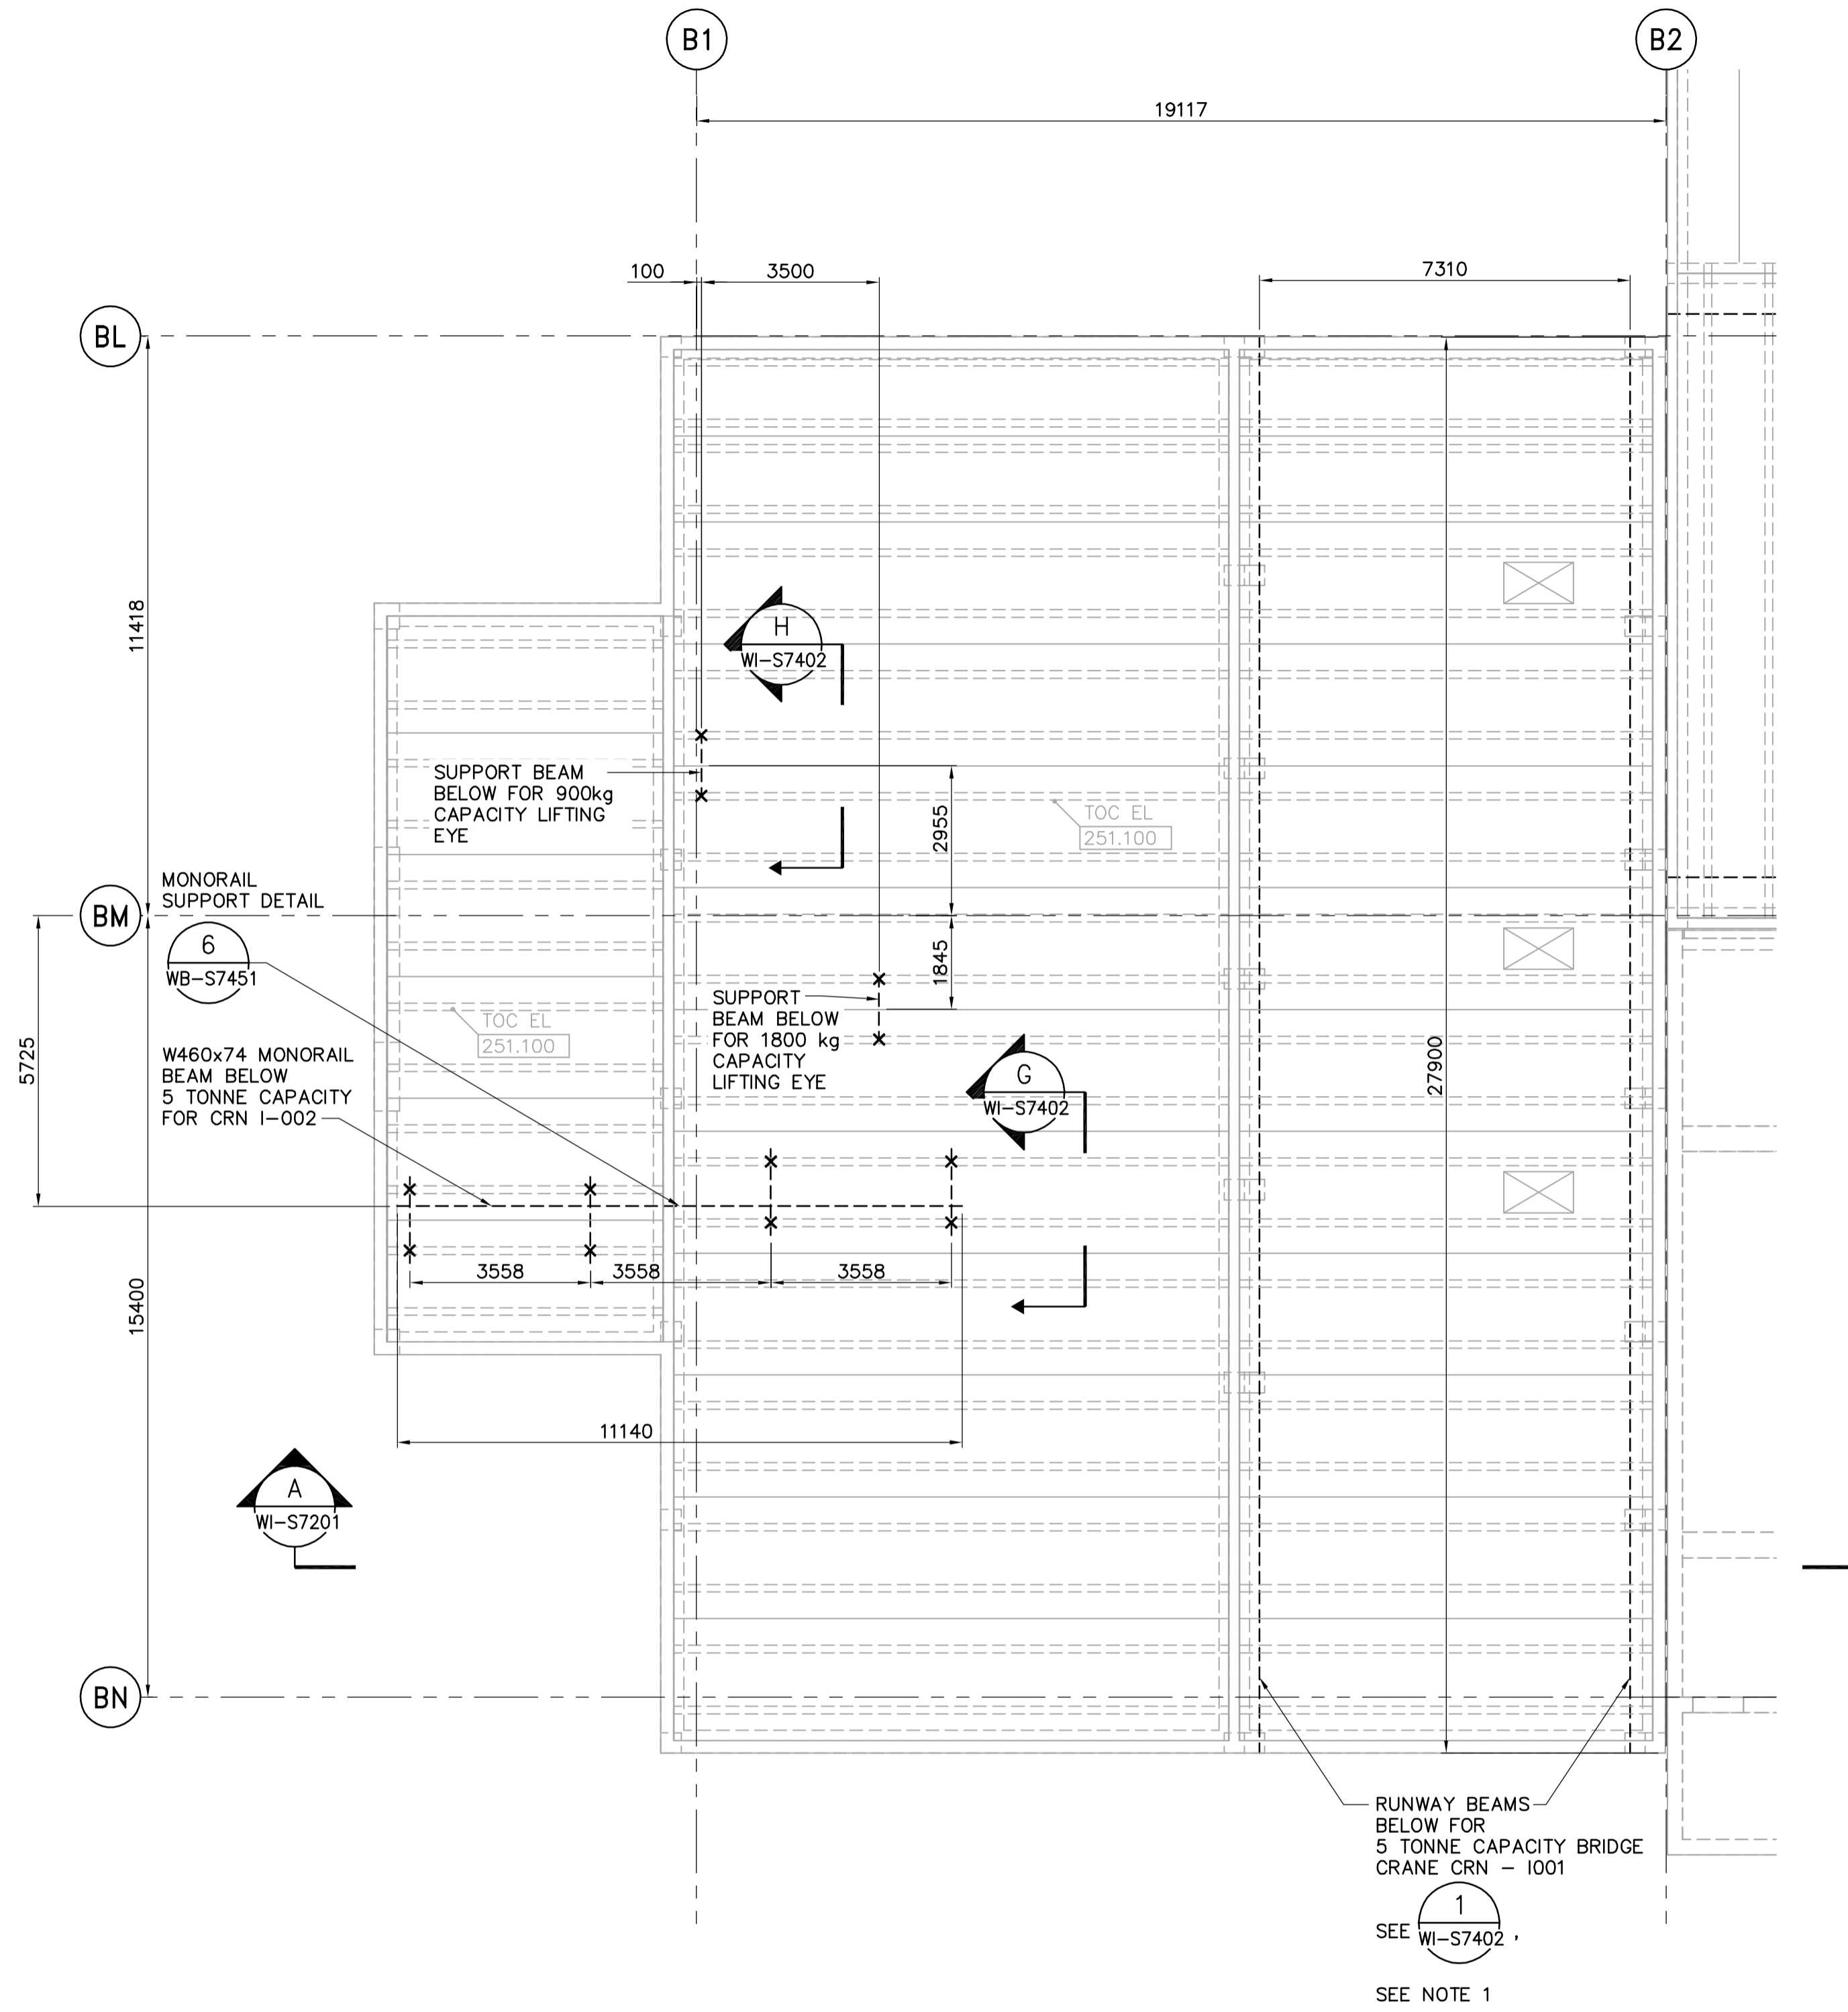


NOTE:

- SPLICE RUNWAY BEAMS AT SUPPORT LOCATIONS ONLY, SEE 2 WI-S7402

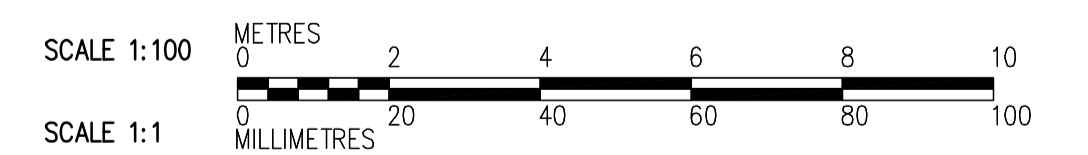

ROOF PLAN
1:100

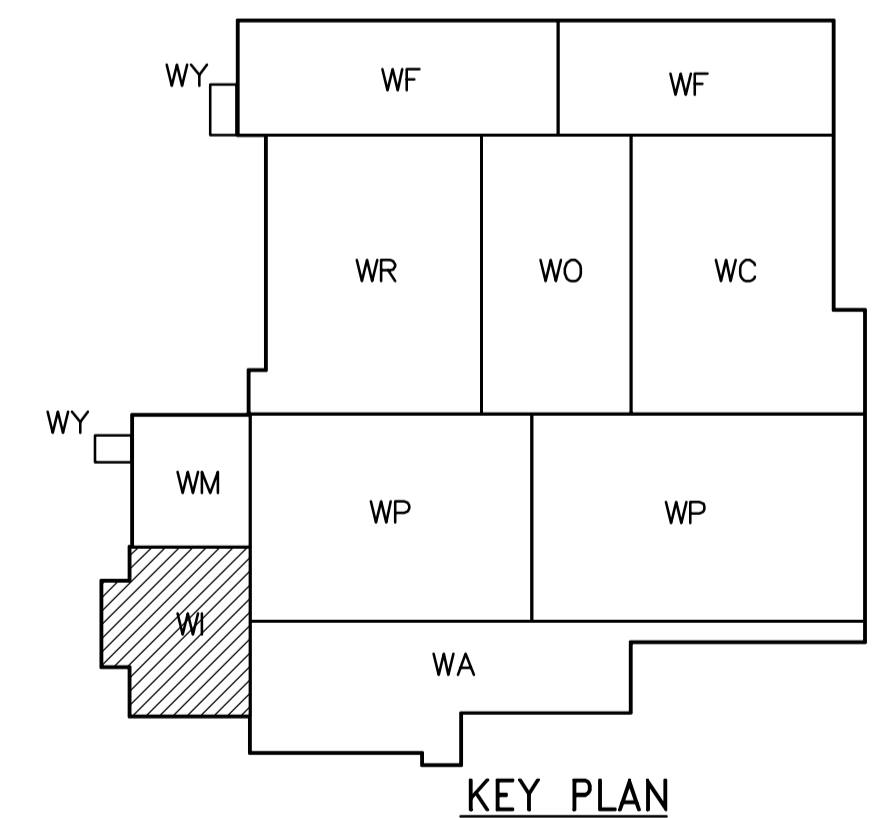

<p>APEGN Certificate of Authorization CH2M HILL Canada Ltd. No. 1441 Expiry: April 30, 2006</p>	<p>Frederickson Cooper ARCHITECTS</p>	<p>A Geo International Ltd. Company</p>	ENGINEER'S SEAL	<p>THE CITY OF WINNIPEG WATER AND WASTE DEPARTMENT ENGINEERING DIVISION</p>			
			DESIGNED BY: EL CHECKED BY: AP DRAWN BY: CA APPROVED BY: AHL		ORIGINAL SIGNED BY: D. KRUGER 2006/04/21	WATER TREATMENT PLANT INLET WORKS AND RAW WATER PUMPING MECHANICAL AND ELECTRICAL	CITY FILE NUMBER SHEET OF
			SCALE: 1:100 RELEASED FOR CONSTRUCTION BY: R. SOROKOWSKI		CONSULTANT DRAWING NO. WI-S7146	STRUCTURAL RAW WATER PUMP STATION AREA ROOF PLAN	CITY DRAWING NUMBER 1-06011-A-S7146-001-000
B.M. ELEV.		NO. REVISIONS DATE BY		DATE 2005/12/19 DATE 2006/04/21			