


ROOF PLAN
1:100

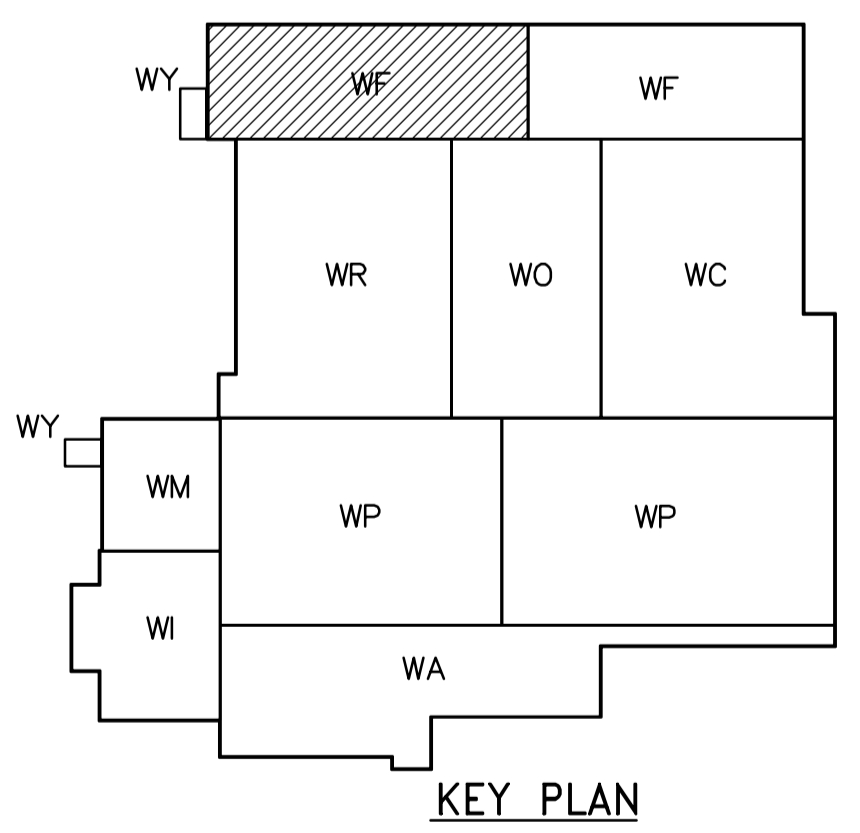

 APEGN Certificate of Authorization CH2M HILL Canada Ltd. No. 1441 Expiry: April 30, 2007	B.M. ELEV.	 Frederickson Cooper ARCHITECTS	 A Terra International Ltd. Company	ENGINEER'S SEAL	 THE CITY OF WINNIPEG WATER AND WASTE DEPARTMENT ENGINEERING DIVISION		
				DESIGNED BY: KA CHECKED BY: AP DRAWN BY: PM APPROVED BY: AHL		ORIGINAL SIGNED BY D. KRUGER 2006/04/28	WATER TREATMENT PLANT FILTRATION MECHANICAL AND ELECTRICAL
	00 742-2005 ADDENDUM 2 06/04/28 DK NO. REVISIONS DATE BY			SCALE: 1:100 RELEASED FOR CONSTRUCTION BY: R. SOROKOWSKI DATE: 2005/08/10 DATE: 2006/04/28		CONSULTANT DRAWING NO. WF-S7146	CITY FILE NUMBER SHEET OF CITY DRAWING NUMBER 1-0601F-A-S7146-001-000