

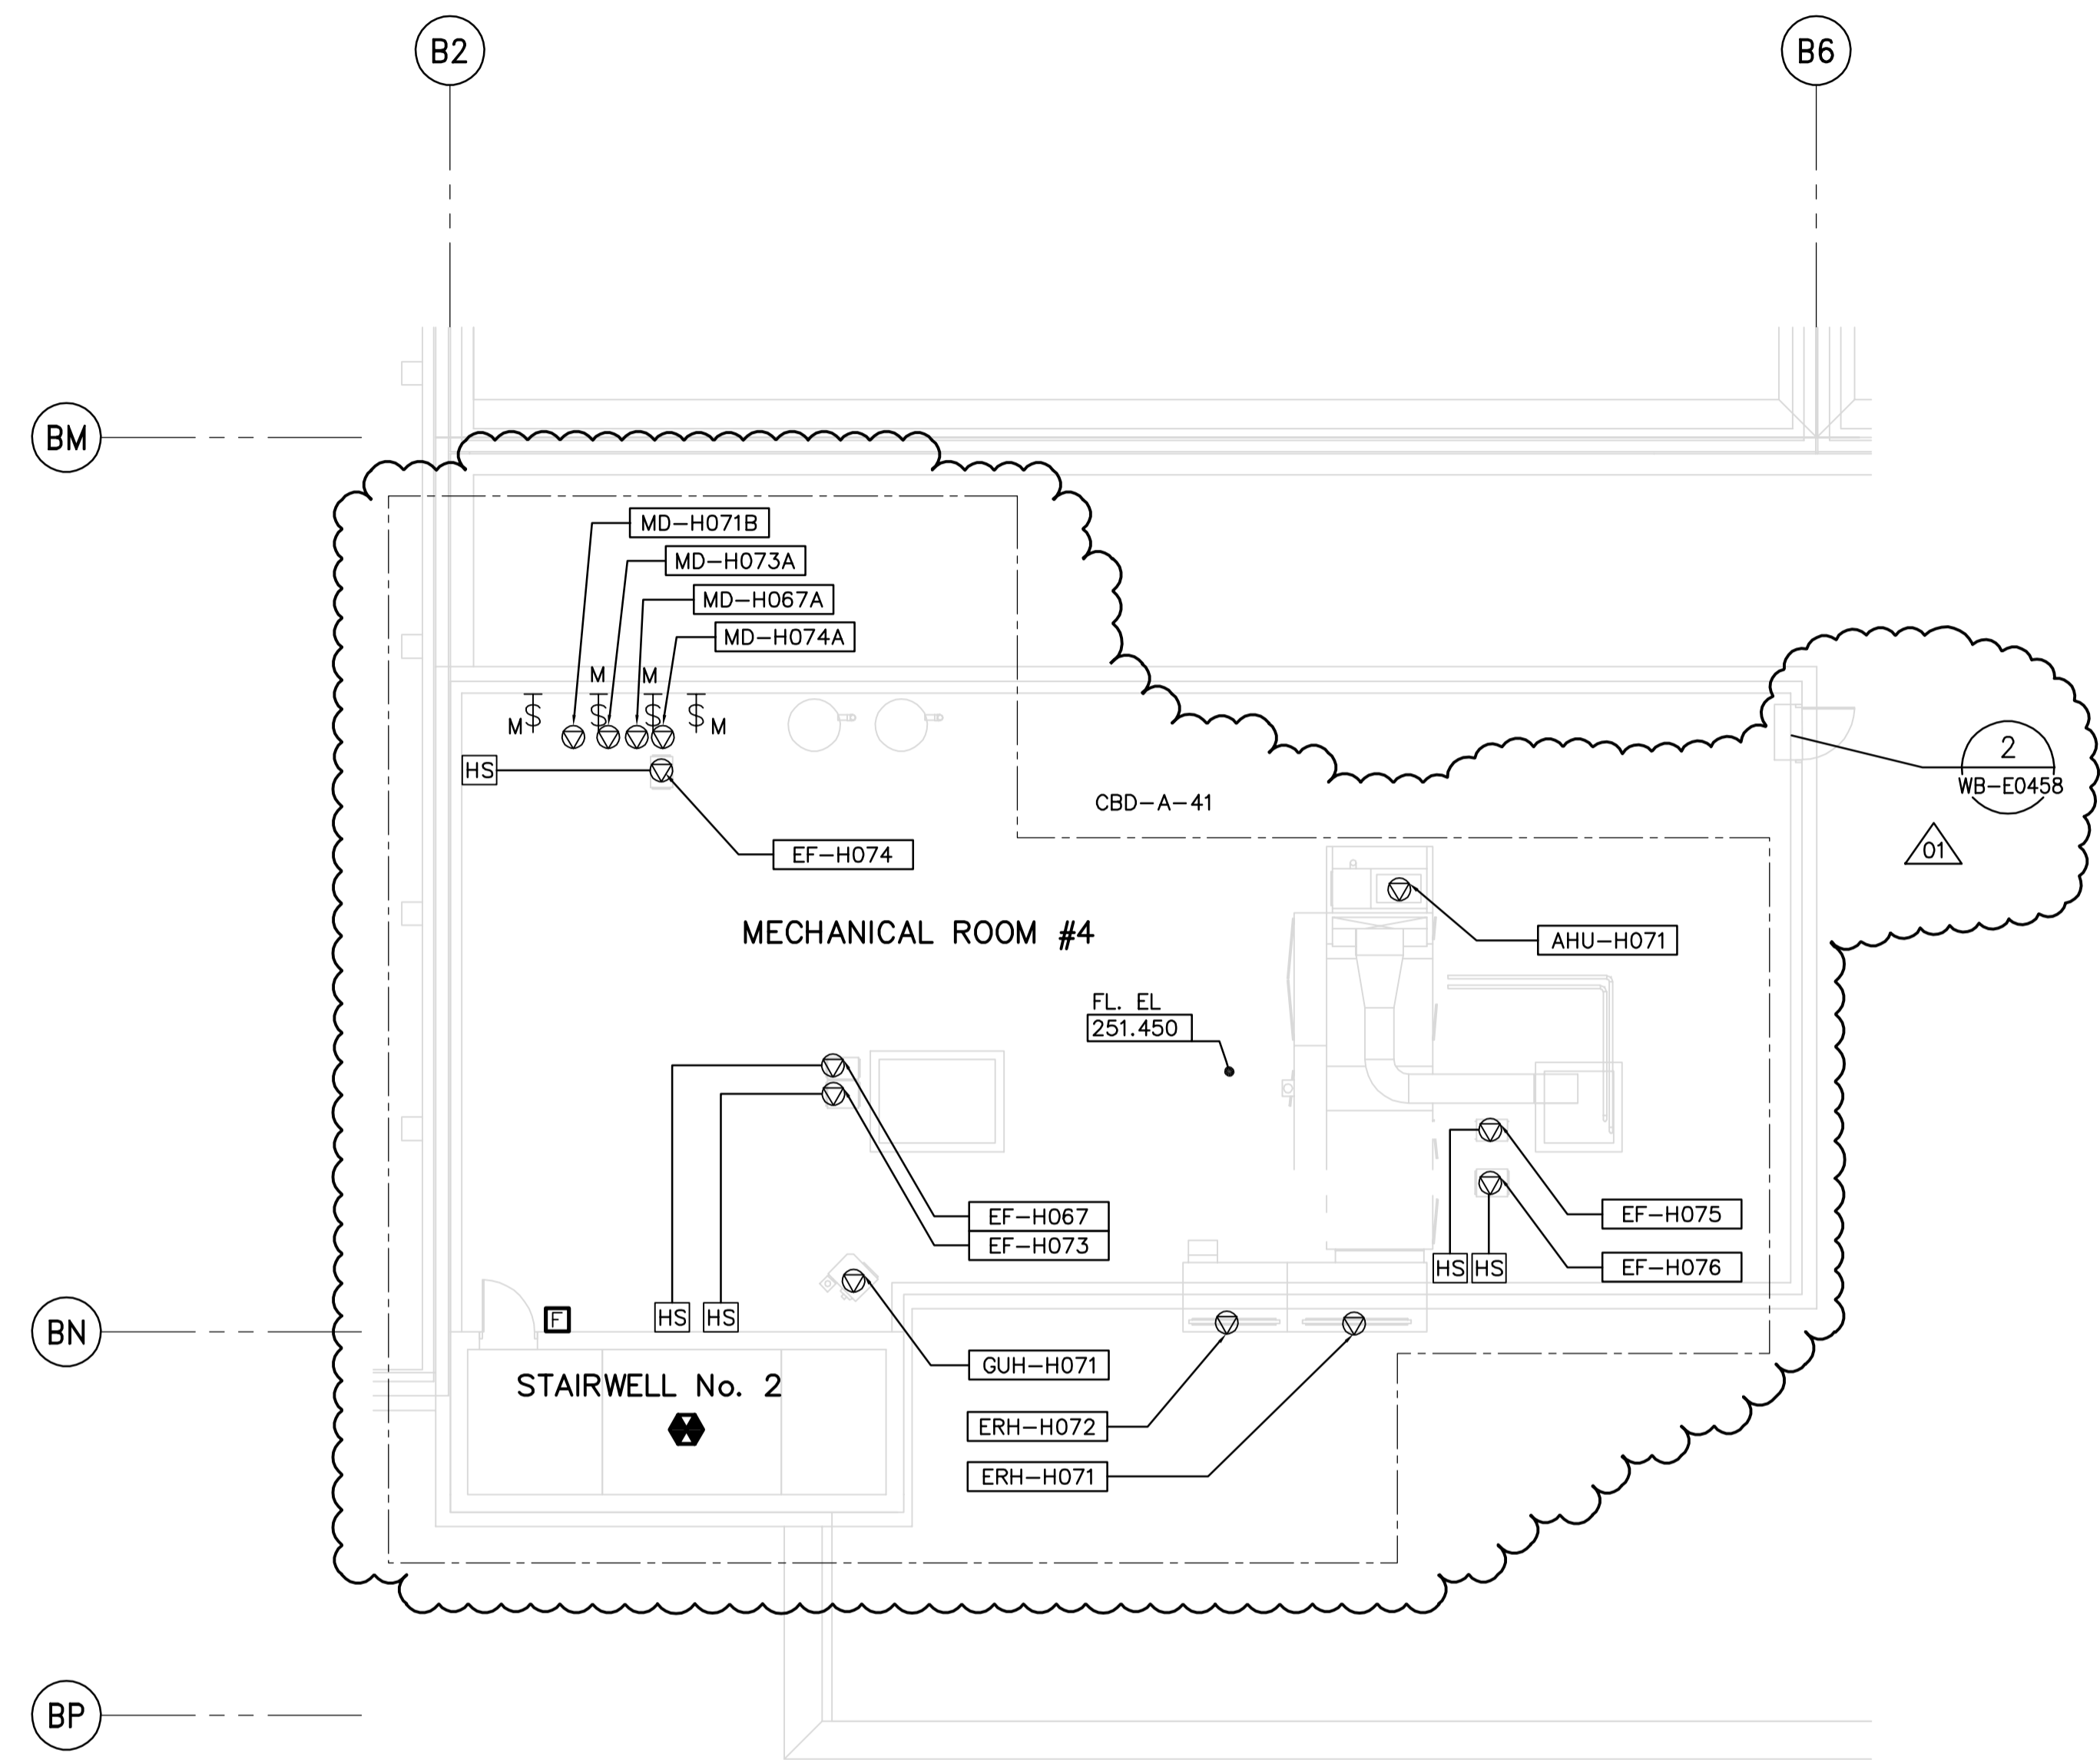


- NOTES:**
1. PROVIDE STAIRWELL SMOKE DETECTORS AS SHOWN ON FIRE PROTECTION DRAWINGS.
 2. SEE MCC 4A SINGLE LINE DIAGRAM FOR 600V POWER DISTRIBUTION. 01
 3. ALL 120V AND 208V LOADS ARE FED FROM LP-A31

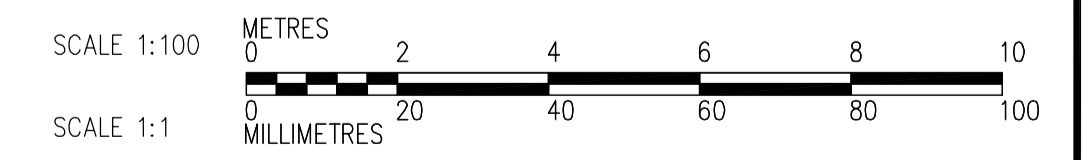

01
MECHANICAL ROOM #4 FACILITY PLAN
 1:100

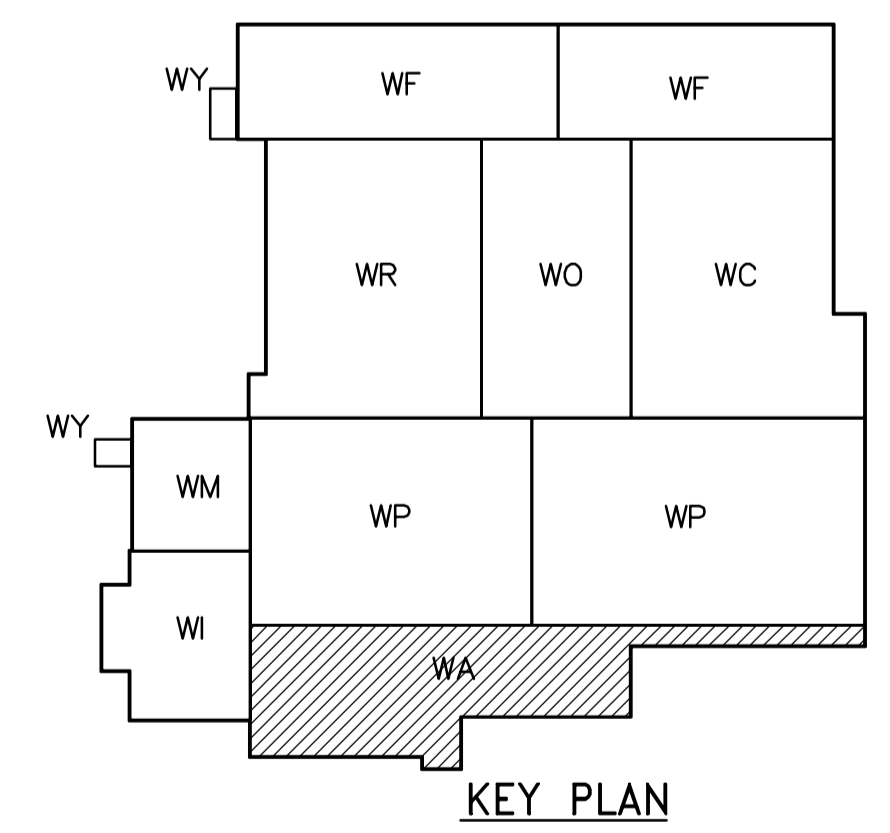

| | | | | | | |
|--|--|---|--|---|--|------------------|
| APEGN Certificate of Authorization CH2M HILL Canada Ltd. No. 1441 Expiry: April 30, 2007 | CH2MHILL Frederickson Cooper ARCHITECTS | EarthTech A Tyco International Ltd. Company | B.M. ELEV. | ENGINEER'S SEAL ORIGINAL SIGNED BY L.D. LLEWELLYN 2006/03/29 | THE CITY OF WINNIPEG WATER AND WASTE DEPARTMENT ENGINEERING DIVISION WATER TREATMENT PLANT ADMINISTRATION MECHANICAL AND ELECTRICAL ELECTRICAL ADMINISTRATION AREA ROOF FACILITY PLAN | CITY FILE NUMBER |
| | | | DESIGNED BY: LL CHECKED BY: ND DRAWN BY: TL APPROVED BY: AHL | CONSULTANT DRAWING NO. WA-E0145 | | SHEET OF |
| | | | SCALE: 1:100 RELEASED FOR CONSTRUCTION BY: R. SOROKOWSKI DATE: 2006/03/29 | CITY DRAWING NUMBER 1-0601A-A-E0145-001-01D | | |
| NO. REVISIONS DATE BY | | DATE: 2005/08/18 DATE: 2006/03/29 | | | | |