




**LOWER LEVEL PLAN**  
1:100

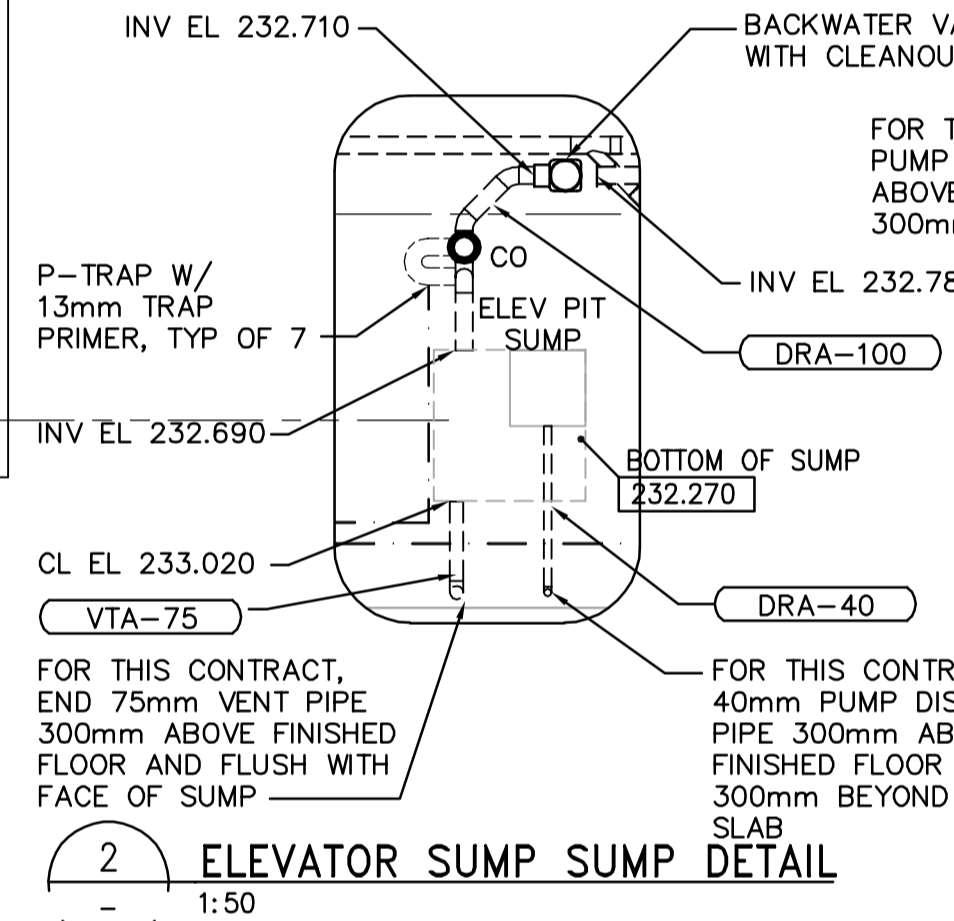


**ELEVATOR SUMP SUMP DETAIL**  
1:50

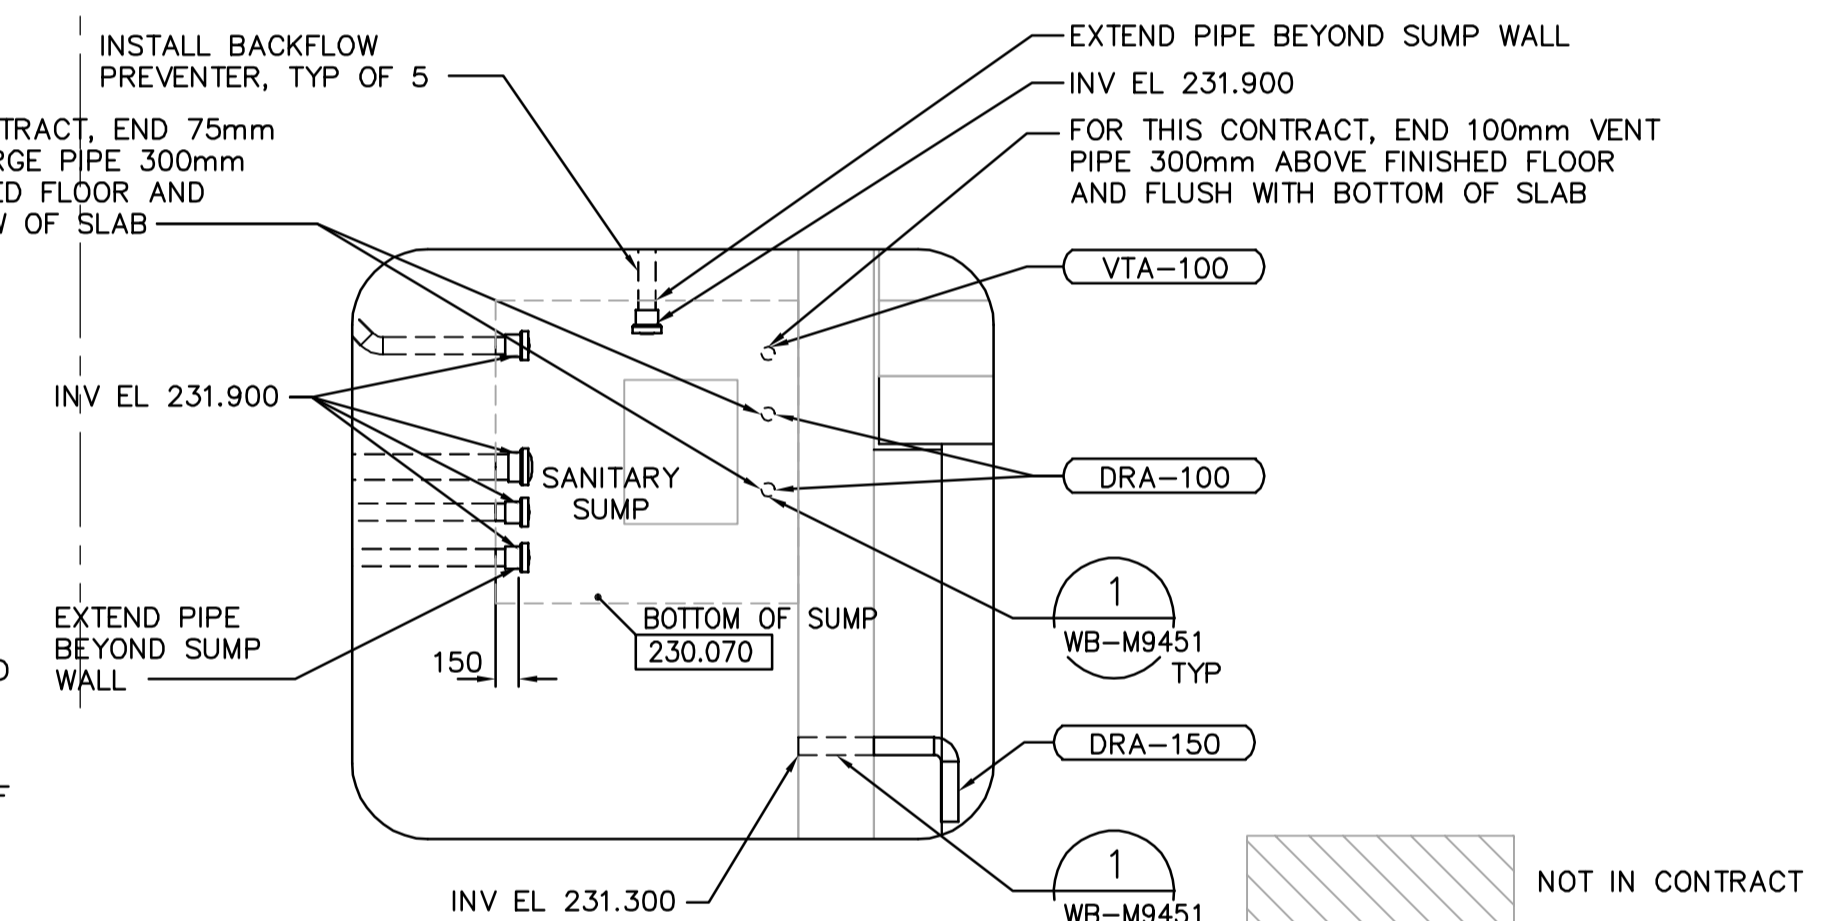


**SOUTH SUMP DETAIL**  
1:50

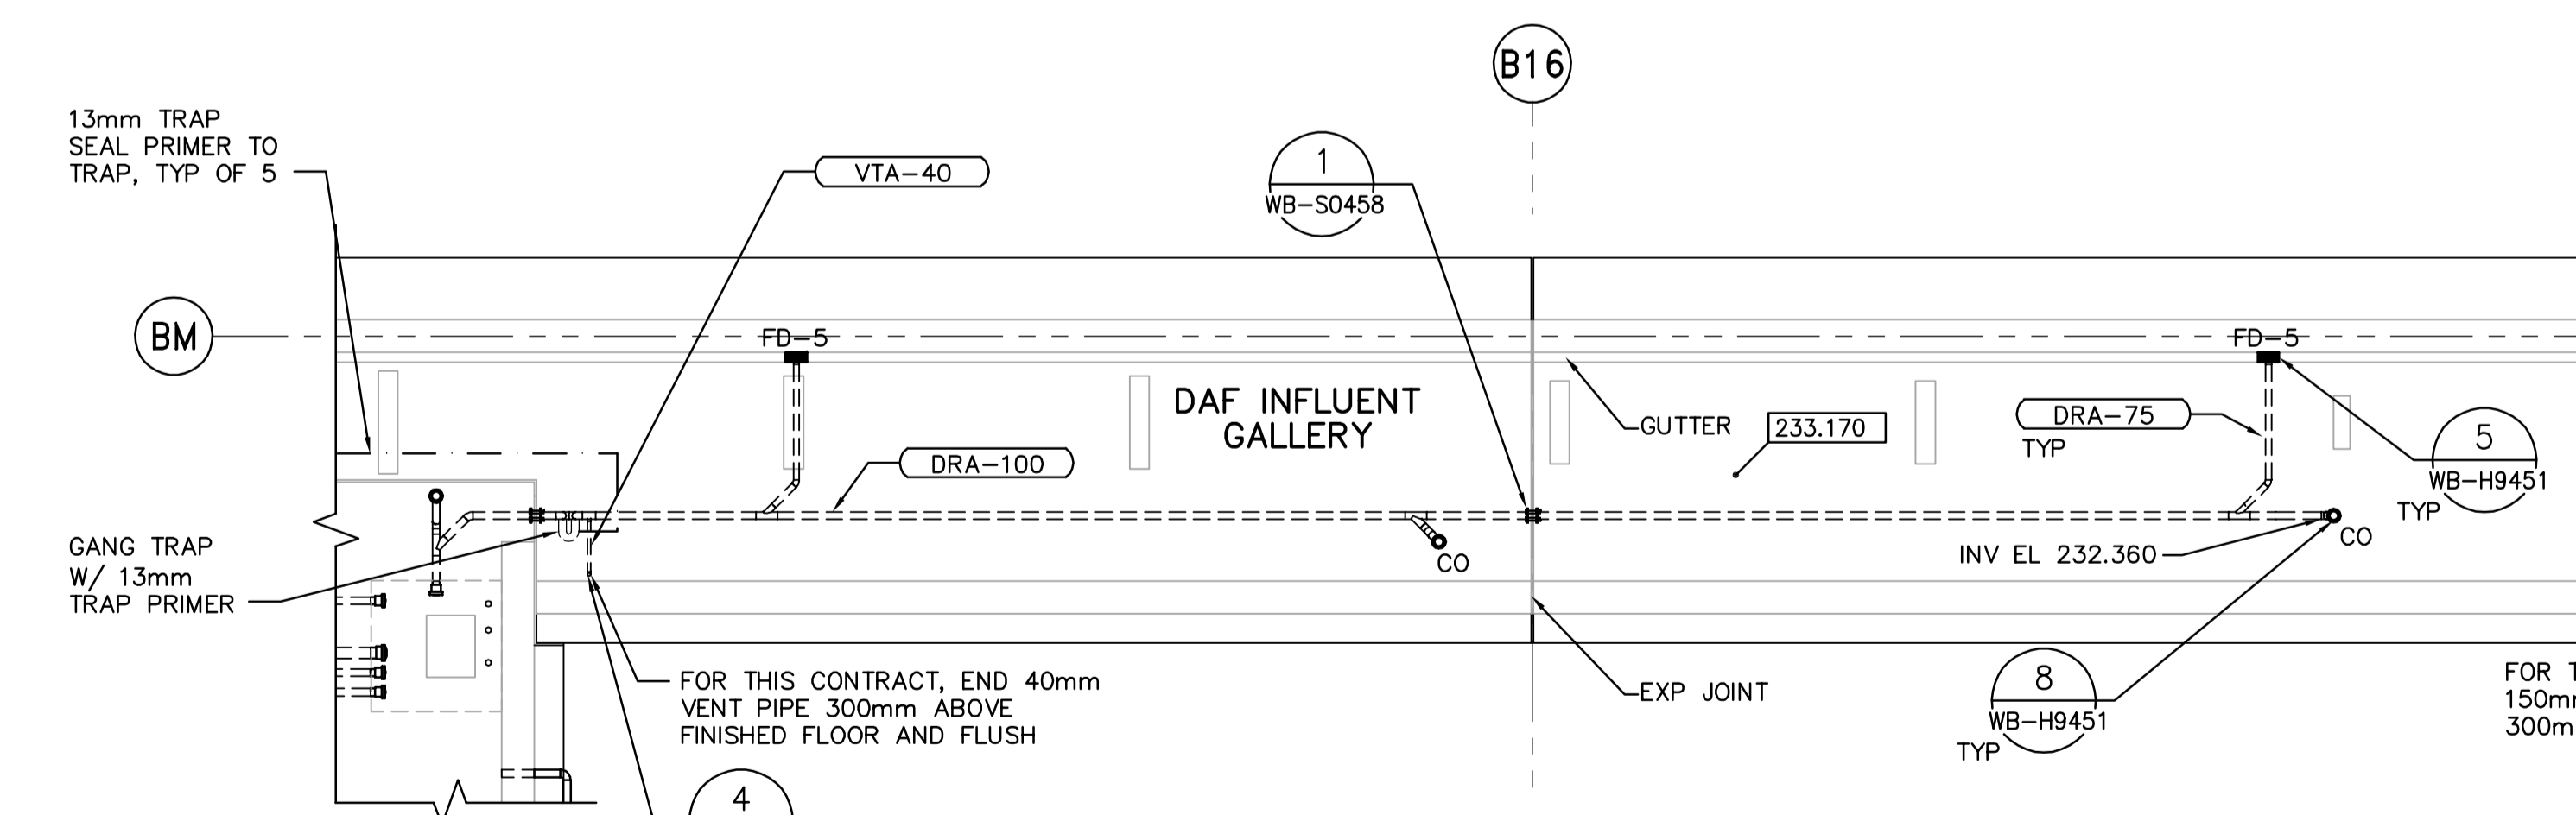


**LOWER LEVEL PLAN (CONTINUATION)**  
1:100

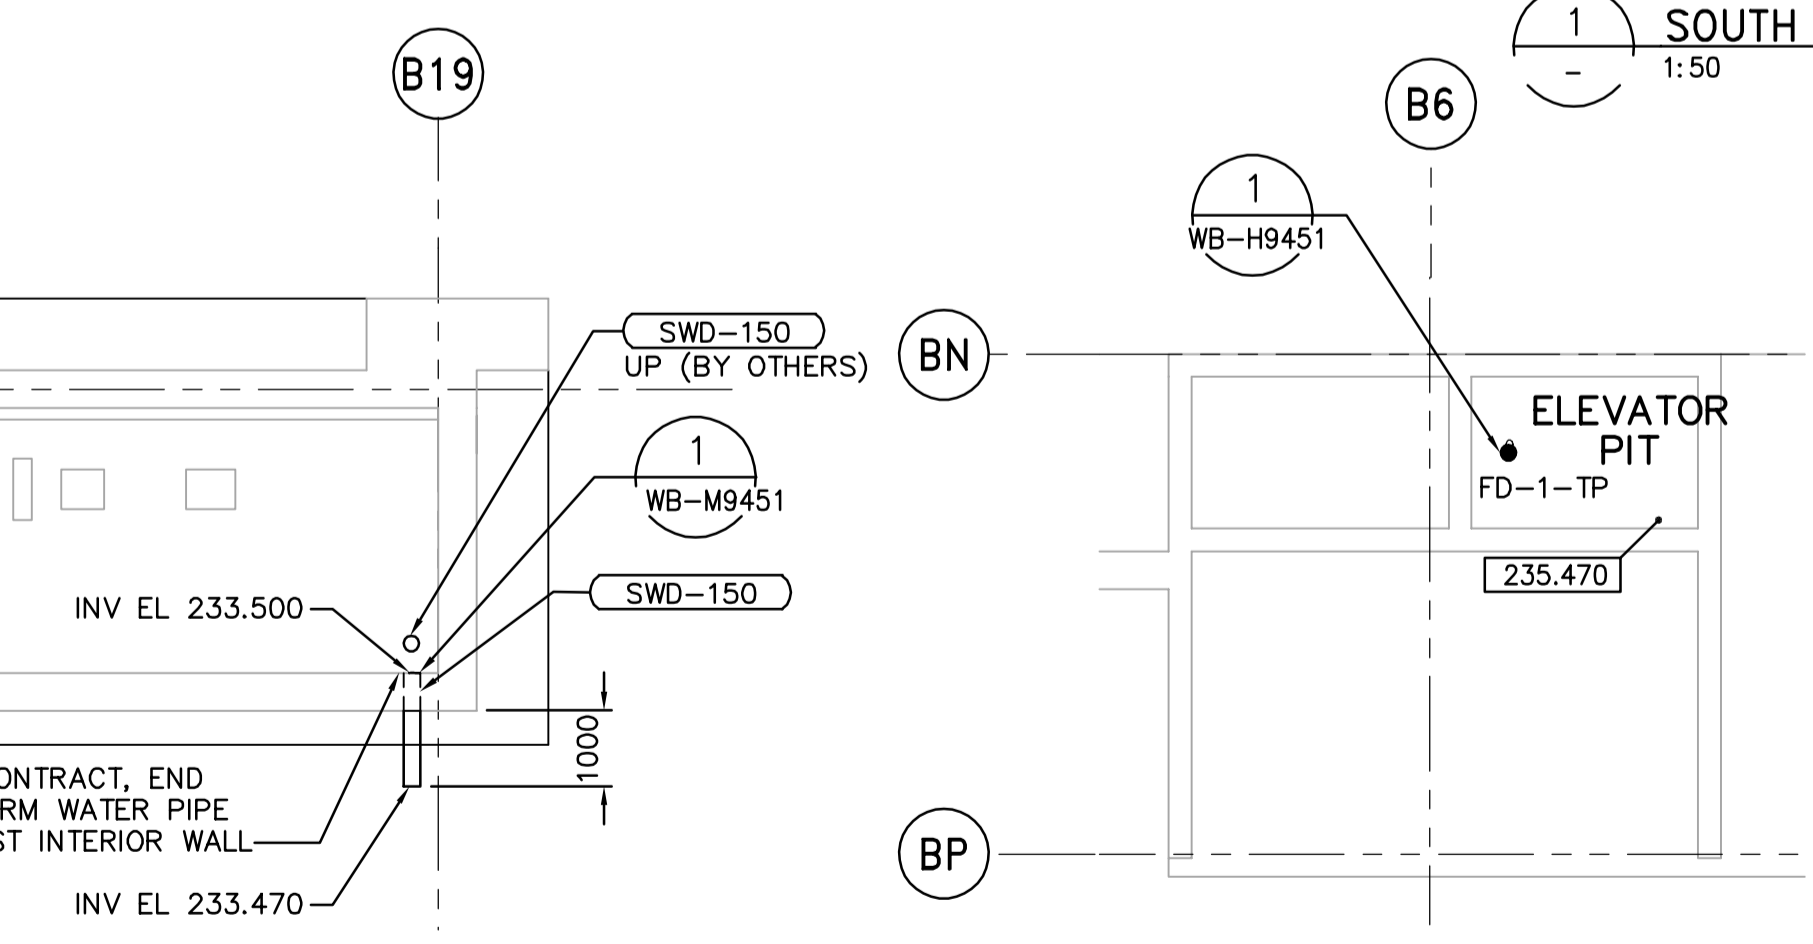

**PARTIAL FIRST FLOOR PLAN**  
1:100

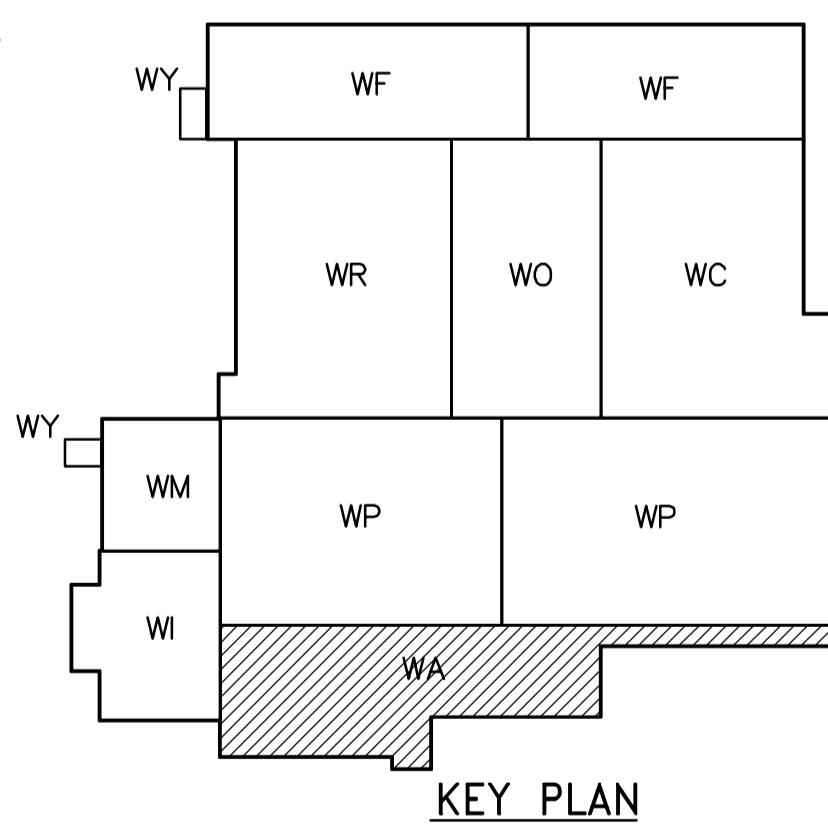

**KEY PLAN**

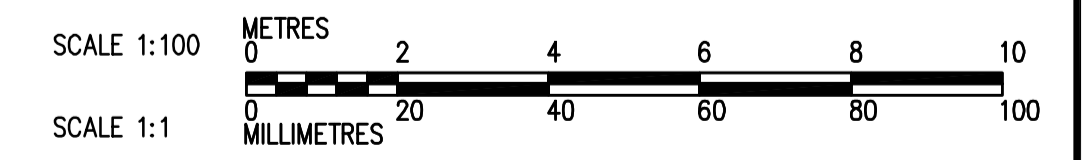

<p><b>Certificate of Authorization</b> CH2M HILL Canada Ltd. No. 1441 Expiry: April 30, 2007</p>	B.M. ELEV.	<p>Frederickson Cooper ARCHITECTS</p>	<p>A Yeo International Ltd. Company</p>	ENGINEER'S SEAL	<p><b>THE CITY OF WINNIPEG</b> WATER AND WASTE DEPARTMENT ENGINEERING DIVISION</p>				
				DESIGNED BY JZ/SW		CHECKED BY DL	ORIGINAL SIGNED BY D.K. CUDDINGTON		
		DRAWN BY JMcP	APPROVED BY DJT	2006/02/06		WATER TREATMENT PLANT ADMINISTRATION MECHANICAL AND ELECTRICAL			
		SCALE: 1:100	RELEASED FOR CONSTRUCTION BY: R. SOROKOWSKI	CONSULTANT DRAWING NO. WA-H9102		PLUMBING PIPE EMBEDS ADMINISTRATION AREA LOWER LEVEL PLAN			
	NO. REVISIONS	DATE	DATE	2005/07/15	DATE	2006/02/08	CITY FILE NUMBER	SHEET OF	CITY DRAWING NUMBER
	01	742-2005 ADDENDUM 3	06/05/05	SW					1-0601A-A-H9102-001-01D
	00	ISSUED FOR TENDER	2006/02/03	SW					