
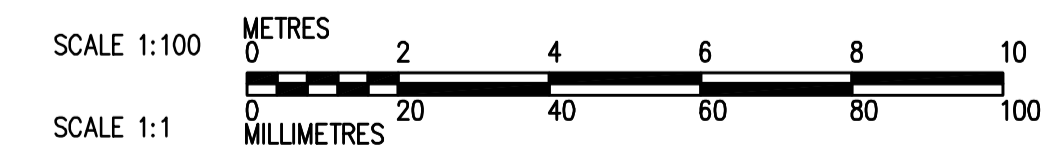


**SECOND FLOOR PLAN**  
1:100

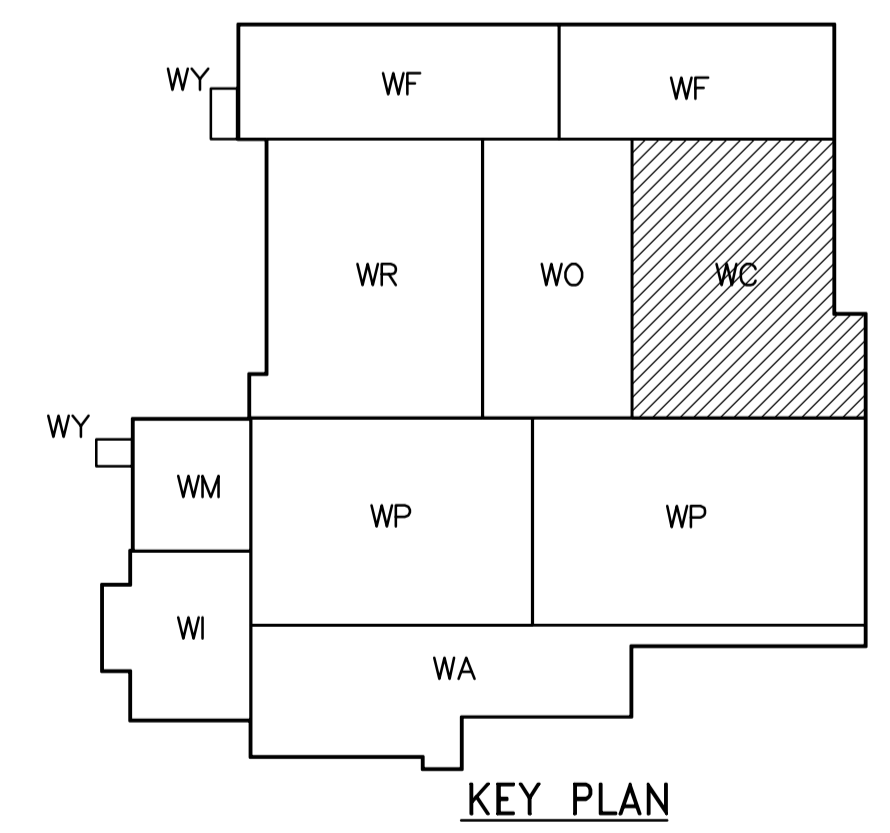

<p><b>APEGN</b> Certificate of Authorization CH2M HILL Canada Ltd. No. 1441 Expiry: April 30, 2007</p>	B.M. ELEV.	<p>Frederickson Cooper ARCHITECTS</p>	<p>EarthTech A Tyco International Ltd. Company</p>	ENGINEER'S SEAL	<p><b>THE CITY OF WINNIPEG</b> WATER AND WASTE DEPARTMENT ENGINEERING DIVISION</p>
	DESIGNED BY JZ/SW			CHECKED BY DL	
	DRAWN BY JMcP	APPROVED BY DJT	2006/02/06		
	SCALE: 1:100	RELEASED FOR CONSTRUCTION BY: R. SOROKOWSKI	CONSULTANT DRAWING NO. WC-H9122		
01 742-2005 ADDENDUM 3 06/05/05 SW	DATE 2005/08/02	DATE 2006/02/08			<p>WATER TREATMENT PLANT CHEMICAL FEED SYSTEMS MECHANICAL AND ELECTRICAL</p> <p>PLUMBING PIPE EMBEDS CHEMICAL AREA SECOND FLOOR PLAN</p>
00 ISSUED FOR TENDER 2006/02/03 SW					CITY FILE NUMBER
NO. REVISIONS	DATE	BY			SHEET OF
					CITY DRAWING NUMBER
					1-0601C-A-H9122-001-01D