
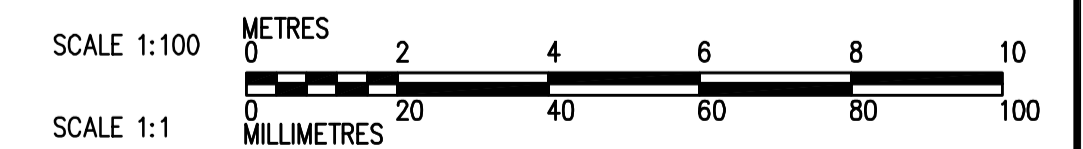


THIRD FLOOR PLAN
1:100

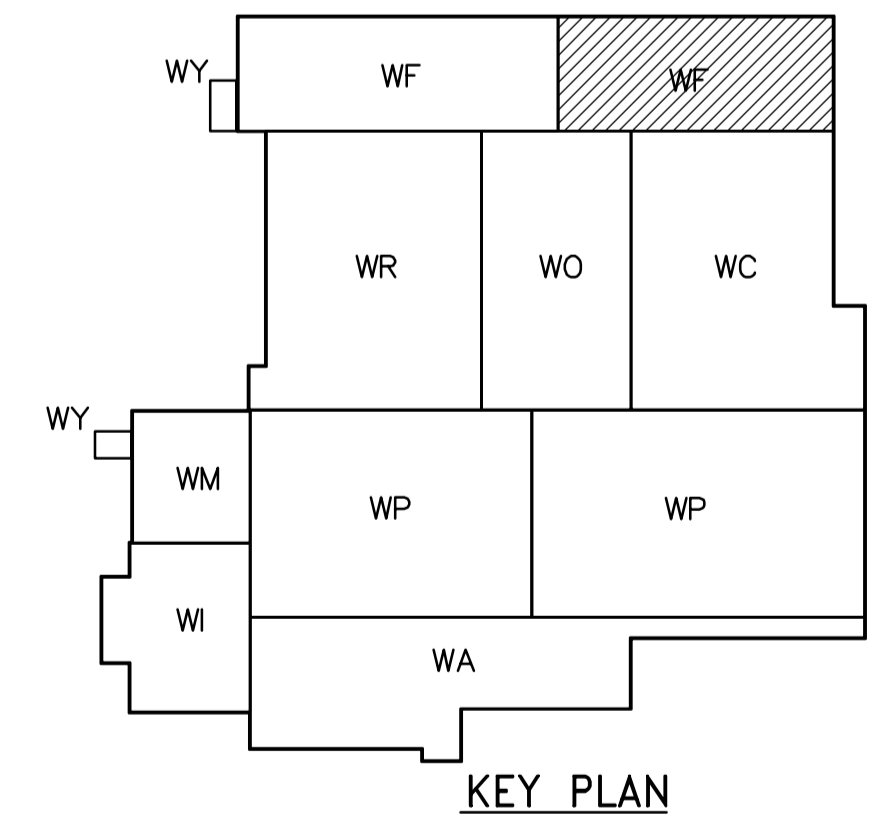

<p>APEGN Certificate of Authorization CH2M HILL Canada Ltd. No. 1441 Expiry: April 30, 2007</p>	<p>Frederickson Cooper ARCHITECTS</p>	<p>EarthTech A Tyco International Ltd. Company</p>	ENGINEER'S SEAL	<p>THE CITY OF WINNIPEG WATER AND WASTE DEPARTMENT ENGINEERING DIVISION</p>																												
			DESIGNED BY JZ/SW		CHECKED BY DL	ORIGINAL SIGNED BY D.K. CUDDINGTON																										
			DRAWN BY JMcP		APPROVED BY DJT	2006/02/06																										
			SCALE: 1:100		RELEASED FOR CONSTRUCTION BY: R. SOROKOWSKI	CONSULTANT DRAWING NO. WF-H9134																										
<table border="1"> <tr> <th>B.M.</th> <th>ELEV.</th> </tr> <tr> <td> </td> <td> </td> </tr> <tr> <td> </td> <td> </td> </tr> <tr> <td> </td> <td> </td> </tr> <tr> <td> </td> <td> </td> </tr> </table>	B.M.	ELEV.									<table border="1"> <tr> <th>NO.</th> <th>REVISIONS</th> <th>DATE</th> <th>BY</th> </tr> <tr> <td>01</td> <td>742-2005 ADDENDUM 3</td> <td>06/05/05</td> <td>SW</td> </tr> <tr> <td>00</td> <td>ISSUED FOR TENDER</td> <td>2006/02/03</td> <td>SW</td> </tr> </table>	NO.	REVISIONS	DATE	BY	01	742-2005 ADDENDUM 3	06/05/05	SW	00	ISSUED FOR TENDER	2006/02/03	SW	<table border="1"> <tr> <th>DATE</th> <th>BY</th> </tr> <tr> <td>2005/08/02</td> <td> </td> </tr> <tr> <td>2006/02/08</td> <td> </td> </tr> </table>	DATE	BY	2005/08/02		2006/02/08		<p>PLUMBING PIPE EMBEDS FILTRATION AREA 2 THIRD FLOOR PLAN</p>	<p>CITY FILE NUMBER SHEET OF CITY DRAWING NUMBER 1-0601F-A-H9134-001-01D</p>
B.M.	ELEV.																															
NO.	REVISIONS	DATE	BY																													
01	742-2005 ADDENDUM 3	06/05/05	SW																													
00	ISSUED FOR TENDER	2006/02/03	SW																													
DATE	BY																															
2005/08/02																																
2006/02/08																																