
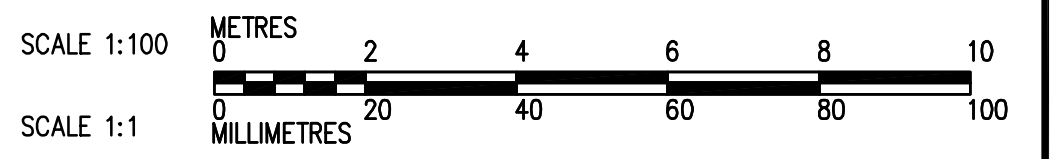


FIRST FLOOR PLAN  
1:100

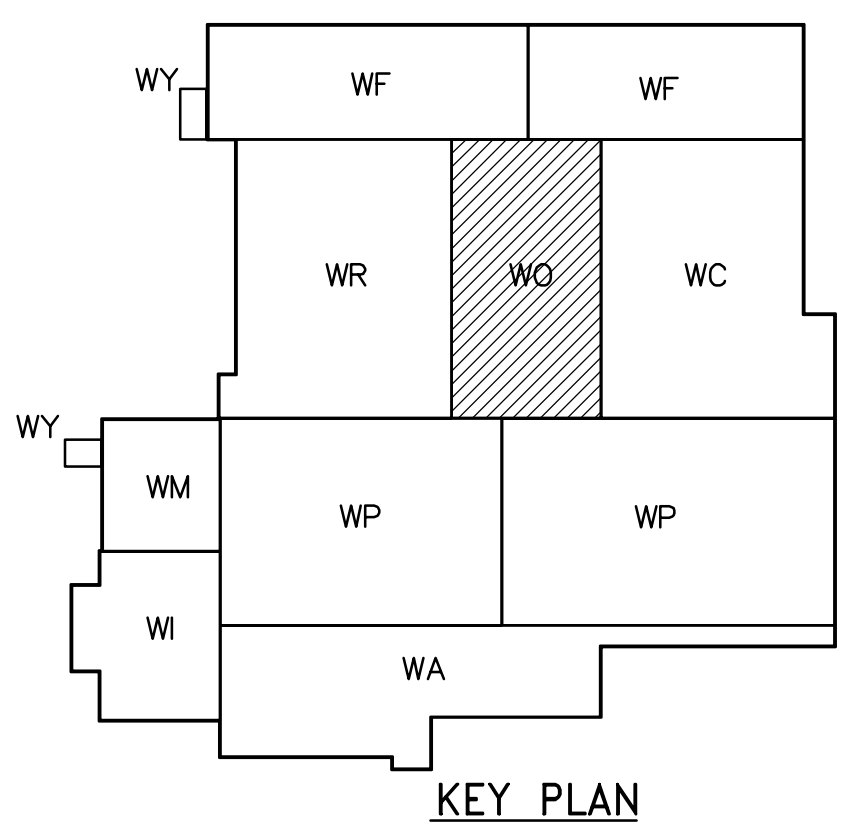

<p><b>APEGN</b> Certificate of Authorization CH2M HILL Canada Ltd. No. 1441 Expiry: April 30, 2007</p>	<p>B.M. ELEV.</p> <table border="1"> <tr><td> </td><td> </td><td> </td></tr> <tr><td> </td><td> </td><td> </td></tr> <tr><td> </td><td> </td><td> </td></tr> <tr><td> </td><td> </td><td> </td></tr> </table>													<p>Frederickson Cooper ARCHITECTS</p>	<p>EarthTech A Tyco International Ltd. Company</p>	ENGINEER'S SEAL	<p><b>THE CITY OF WINNIPEG</b> WATER AND WASTE DEPARTMENT ENGINEERING DIVISION</p>			
DESIGNED BY JZ/SW	CHECKED BY DL	ORIGINAL SIGNED BY D.K. CUDDINGTON																		
DRAWN BY JMcP	APPROVED BY DJT	2006/02/06																		
SCALE: 1:100	RELEASED FOR CONSTRUCTION BY: R. SOROKOWSKI	CONSULTANT DRAWING NO. WO-H9112																		
<table border="1"> <tr> <th>NO.</th> <th>REVISIONS</th> <th>DATE</th> <th>BY</th> </tr> <tr> <td>01</td> <td>742-2005 ADDENDUM 3</td> <td>06/05/05</td> <td>SW</td> </tr> <tr> <td>00</td> <td>ISSUED FOR TENDER</td> <td>2006/02/03</td> <td>SW</td> </tr> </table>	NO.	REVISIONS	DATE	BY	01	742-2005 ADDENDUM 3	06/05/05	SW	00	ISSUED FOR TENDER	2006/02/03	SW	<table border="1"> <tr> <th>DATE</th> <th>DATE</th> </tr> <tr> <td>2005/08/02</td> <td>2006/02/08</td> </tr> </table>	DATE	DATE	2005/08/02	2006/02/08	<p>PLUMBING PIPE EMBEDS OZONATION AREA FIRST FLOOR PLAN</p>		<p>CITY FILE NUMBER</p> <p>SHEET OF</p> <p>CITY DRAWING NUMBER 1-06010-A-H9112-001-01D</p>
NO.	REVISIONS	DATE	BY																	
01	742-2005 ADDENDUM 3	06/05/05	SW																	
00	ISSUED FOR TENDER	2006/02/03	SW																	
DATE	DATE																			
2005/08/02	2006/02/08																			