
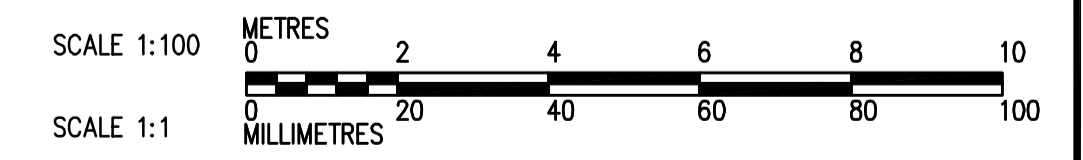


THIRD FLOOR PLAN
1:100

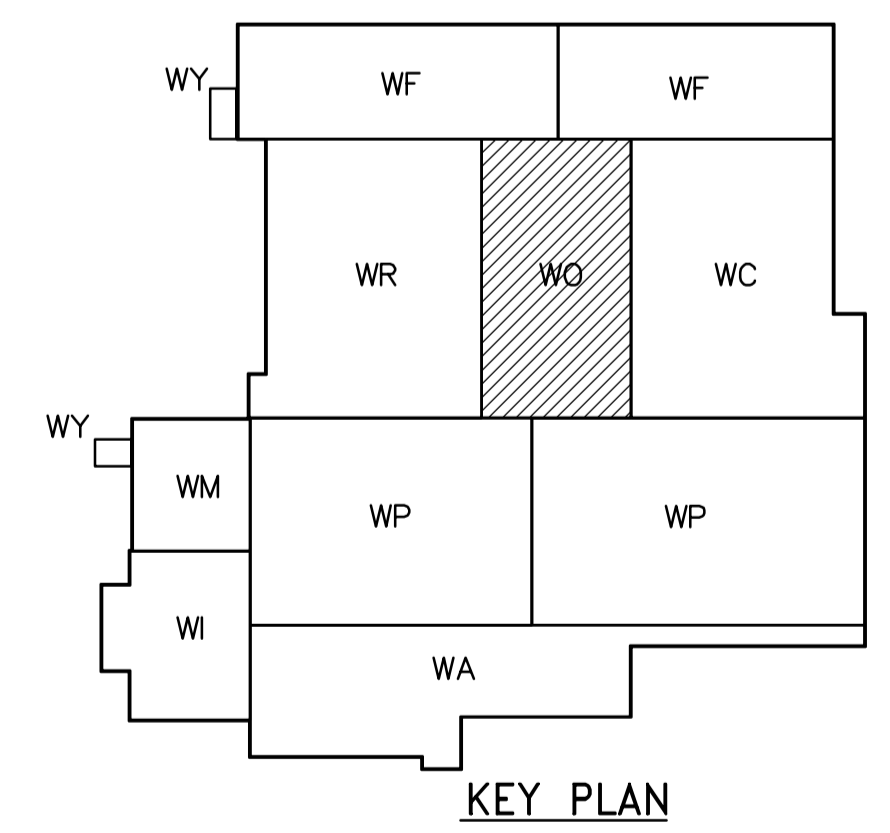

<p>APEGN Certificate of Authorization CH2M HILL Canada Ltd. No. 1441 Expiry: April 30, 2007</p>	<p>B.M. ELEV.</p> <table border="1"> <tr><td> </td><td> </td><td> </td></tr> <tr><td> </td><td> </td><td> </td></tr> <tr><td> </td><td> </td><td> </td></tr> <tr><td> </td><td> </td><td> </td></tr> </table>													<p>Frederickson Cooper ARCHITECTS</p>	<p>A Terra International Ltd. Company</p>	<p>ENGINEER'S SEAL</p> <p>ORIGINAL SIGNED BY D.K. CUDDINGTON 2006/02/06</p>	<p>THE CITY OF WINNIPEG WATER AND WASTE DEPARTMENT ENGINEERING DIVISION</p> <p>WATER TREATMENT PLANT OZONE MECHANICAL AND ELECTRICAL</p> <p>CITY FILE NUMBER SHEET OF CITY DRAWING NUMBER 1-06010-A-H9132-001-01D</p>		
<table border="1"> <tr><td>01</td><td>742-2005 ADDENDUM 3</td><td>06/05/05</td><td>SW</td></tr> <tr><td>00</td><td>ISSUED FOR TENDER</td><td>2006/02/03</td><td>SW</td></tr> </table>	01	742-2005 ADDENDUM 3	06/05/05	SW	00	ISSUED FOR TENDER	2006/02/03	SW	<table border="1"> <tr><td>DESIGNED BY</td><td>JZ/SW</td><td>CHECKED BY</td><td>DL</td></tr> <tr><td>DRAWN BY</td><td>JMcP</td><td>APPROVED BY</td><td>DJT</td></tr> </table>	DESIGNED BY	JZ/SW	CHECKED BY	DL	DRAWN BY	JMcP	APPROVED BY	DJT	<p>SCALE: 1:100</p> <p>RELEASED FOR CONSTRUCTION BY: R. SOROKOWSKI</p>	<p>CONSULTANT DRAWING NO. WO-H9132</p>
01	742-2005 ADDENDUM 3	06/05/05	SW																
00	ISSUED FOR TENDER	2006/02/03	SW																
DESIGNED BY	JZ/SW	CHECKED BY	DL																
DRAWN BY	JMcP	APPROVED BY	DJT																
<p>NO. REVISIONS</p>	<p>DATE BY</p>	<p>DATE 2005/08/02</p>	<p>DATE 2006/02/08</p>																
<p>PLUMBING PIPE EMBEDS OZONATION AREA THIRD FLOOR PLAN</p>				<p>WO-H9132</p>															