



THIRD FLOOR PROCESS PLAN
1:100

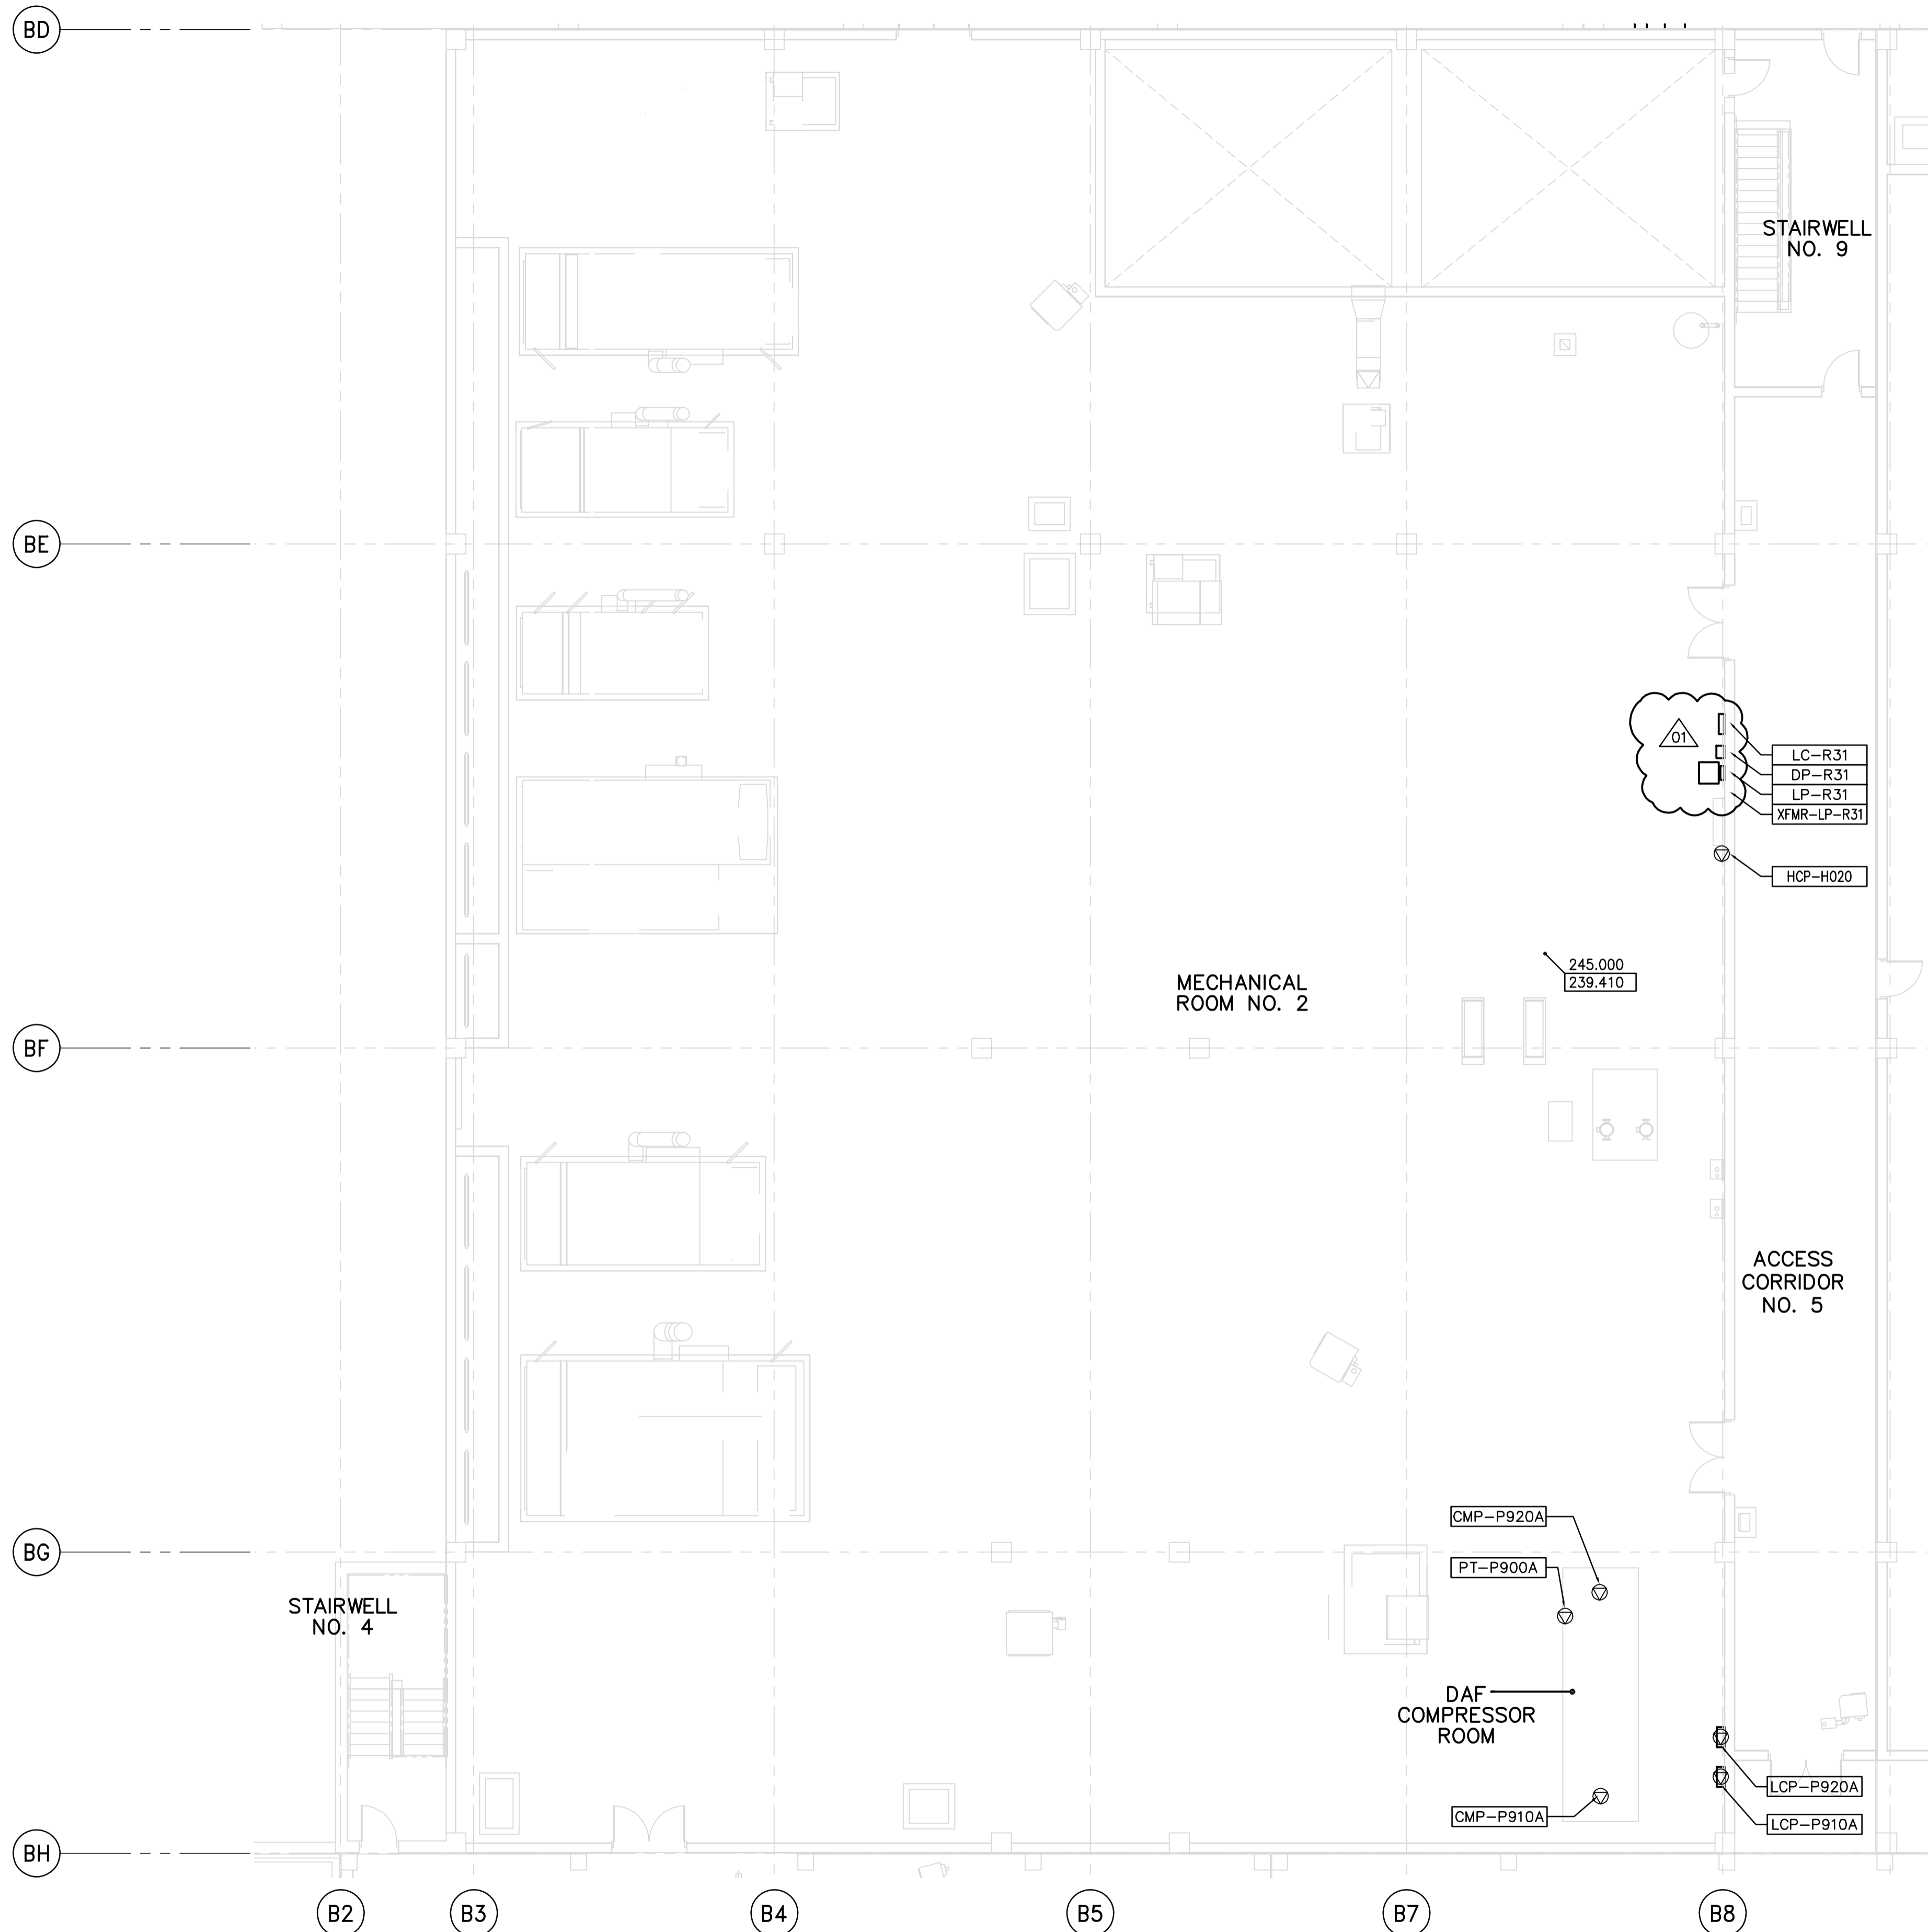

NOTES:

1. PROVIDE STAIRWELL SMOKE DETECTORS AS SHOWN ON FIRE PROTECTION DRAWINGS
2. SEE MCC 4A & 4B SINGLE LINE DIAGRAM AND PANEL SCHEDULES FOR DP-R31 FOR 600V POWER DISTRIBUTION

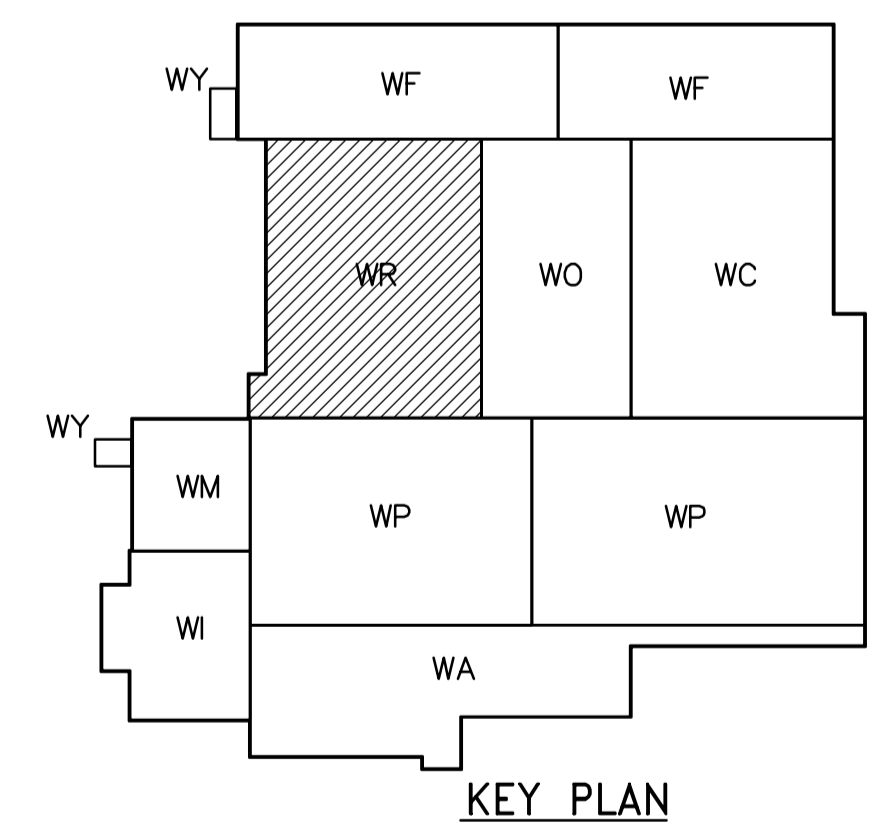

APECA
Certificate of Authorization
CH2M HILL Canada Ltd.
No. 1441 Expiry: April 30, 2007

B.M. ELEV.	DATE	BY
01	742-2005 ADDENDUM 3	06/05/05 LL
00	ISSUED FOR TENDER	06/03/29 LL
NO. REVISIONS	DATE	BY

CH2MHILL
Frederickson Cooper
ARCHITECTS

EarthTech
A Tyco International Ltd. Company

DESIGNED BY	LL	CHECKED BY	ND
DRAWN BY	TL	APPROVED BY	AHL
SCALE:	1:100	RELEASED FOR CONSTRUCTION BY:	R. SOROKOWSKI
DATE	2005/07/12	DATE	2006/03/29

ENGINEER'S SEAL
ORIGINAL SIGNED BY
L.D. LLEWELLYN
2006/03/29
CONSULTANT DRAWING NO.
WR-E0132

THE CITY OF WINNIPEG
WATER AND WASTE DEPARTMENT
ENGINEERING DIVISION

WATER TREATMENT PLANT
RESIDUALS HANDLING
MECHANICAL AND ELECTRICAL

ELECTRICAL
RESIDUALS HANDLING AREA
THIRD FLOOR PROCESS PLAN

CITY FILE NUMBER	
SHEET	OF
CITY DRAWING NUMBER	1-0601R-A-E0132-001-01D