
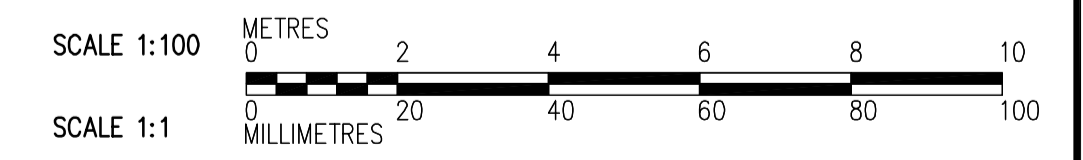


- NOTES:**
1. SEE MCC #1A, #1B SINGLE LINE DIAGRAM AND DP-A11 & DP-A12 POWER DISTRIBUTION FOR 600V POWER REQUIREMENT.
 2. ALL 120V AND 208V LOADS ARE FED FROM LP-A11
 3. PROVIDE STAIRWELL SMOKE DETECTORS AS SHOWN ON FIRE PROTECTION DRAWINGS.

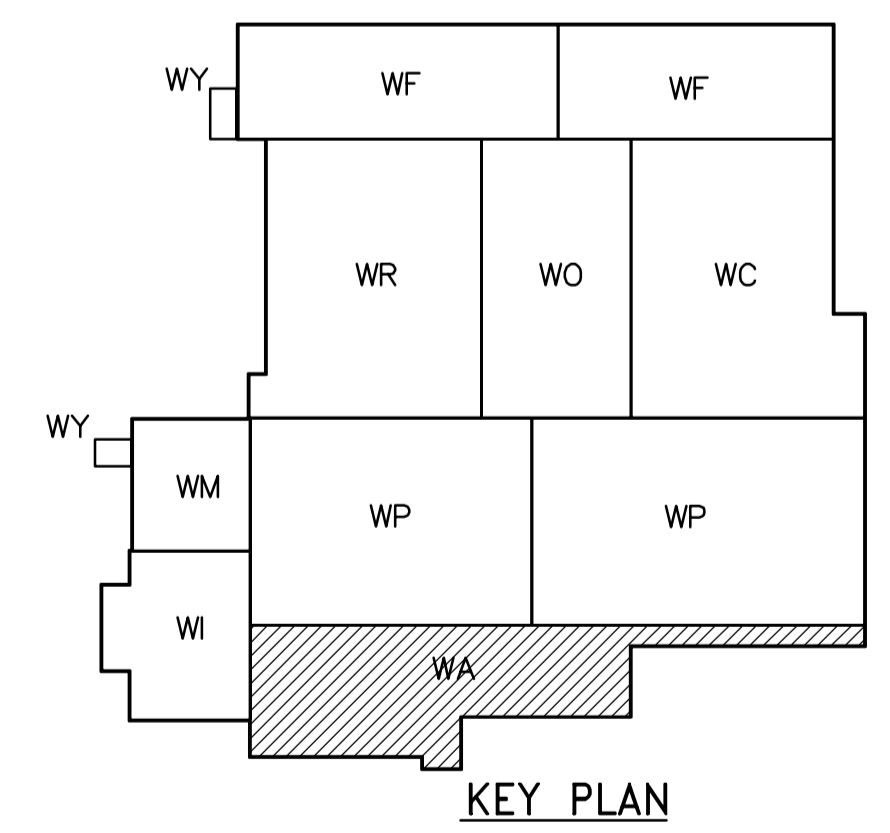

FIRST FLOOR FACILITY PLAN
1:100

CABLE TRAY TAGGING
SEE DETAIL
3
WB-E0455

<p>APEGN Certificate of Authorization CH2M HILL Canada Ltd. No. 1441 Expiry: April 30, 2007</p>	<p>B.M. ELEV.</p> <table border="1"> <tr><td> </td><td> </td><td> </td></tr> <tr><td> </td><td> </td><td> </td></tr> <tr><td> </td><td> </td><td> </td></tr> <tr><td> </td><td> </td><td> </td></tr> </table>													<p>Frederickson Cooper ARCHITECTS</p>	<p>A You International Ltd. Company</p>	<p>ENGINEER'S SEAL</p> <p>ORIGINAL SIGNED BY L.D. LLEWELLYN 2006/03/29</p>	<p>THE CITY OF WINNIPEG WATER AND WASTE DEPARTMENT ENGINEERING DIVISION</p> <p>WATER TREATMENT PLANT ADMINISTRATION MECHANICAL AND ELECTRICAL</p> <p>ELECTRICAL ADMINISTRATION AREA FIRST FLOOR FACILITY PLAN</p>	<p>CITY FILE NUMBER</p> <p>SHEET OF</p>									
<table border="1"> <tr> <td>DESIGNED BY</td> <td>JT</td> <td>CHECKED BY</td> <td>ND</td> </tr> <tr> <td>DRAWN BY</td> <td>KJ</td> <td>APPROVED BY</td> <td>AHL</td> </tr> </table>	DESIGNED BY	JT	CHECKED BY	ND	DRAWN BY	KJ	APPROVED BY	AHL	<p>SCALE: 1:100</p> <p>RELEASED FOR CONSTRUCTION BY: R. SOROKOWSKI</p>	<p>CONSULTANT DRAWING NO. WA-E0111</p>	<p>CITY DRAWING NUMBER 1-0601A-A-E0111-001-020</p>																
DESIGNED BY	JT	CHECKED BY	ND																								
DRAWN BY	KJ	APPROVED BY	AHL																								
<table border="1"> <tr> <th>NO.</th> <th>REVISIONS</th> <th>DATE</th> <th>BY</th> <th>DATE</th> <th>BY</th> </tr> <tr> <td>02</td> <td>742-2005 ADDENDUM 5</td> <td>06/05/19</td> <td>LL</td> <td> </td> <td> </td> </tr> <tr> <td>01</td> <td>742-2005 ADDENDUM 3</td> <td>06/05/05</td> <td>LL</td> <td> </td> <td> </td> </tr> <tr> <td>00</td> <td>ISSUED FOR TENDER</td> <td>06/03/29</td> <td>LL</td> <td> </td> <td> </td> </tr> </table>	NO.	REVISIONS	DATE	BY	DATE	BY	02	742-2005 ADDENDUM 5	06/05/19	LL			01	742-2005 ADDENDUM 3	06/05/05	LL			00	ISSUED FOR TENDER	06/03/29	LL			<p>DATE 2005/08/18</p> <p>DATE 2006/03/29</p>	<p>DATE 2006/03/29</p>	<p>DATE 2006/03/29</p>
NO.	REVISIONS	DATE	BY	DATE	BY																						
02	742-2005 ADDENDUM 5	06/05/19	LL																								
01	742-2005 ADDENDUM 3	06/05/05	LL																								
00	ISSUED FOR TENDER	06/03/29	LL																								
<p>DATE 2005/08/18</p>	<p>DATE 2006/03/29</p>	<p>DATE 2006/03/29</p>	<p>DATE 2006/03/29</p>																								