

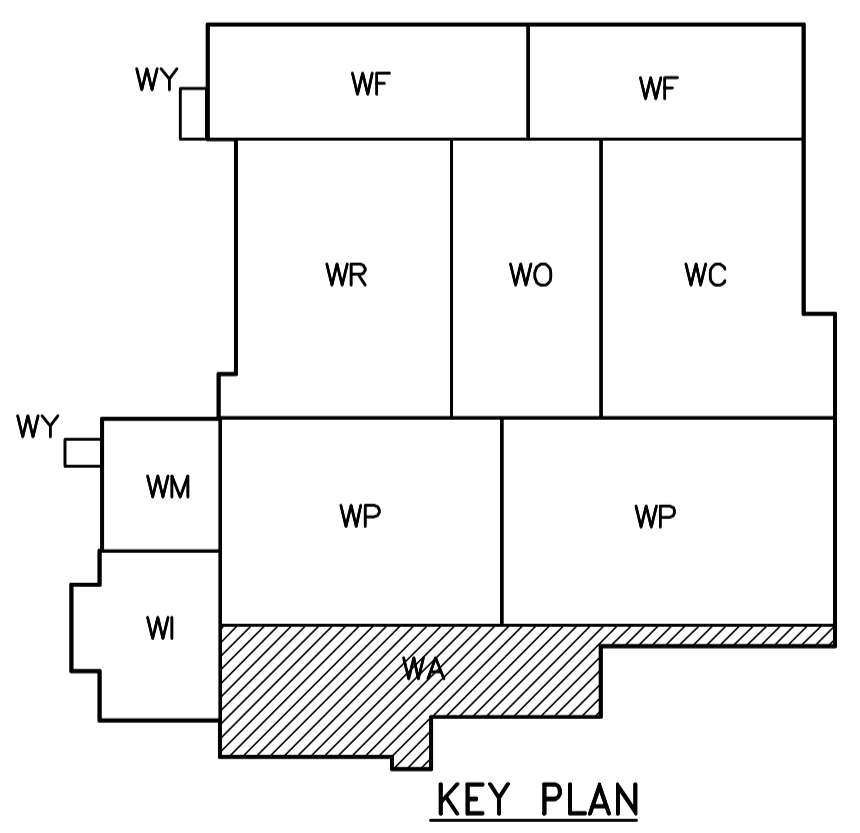


NOTES:
 1. ALL 120V AND 208V LOADS ARE FED FROM LP-A31.
 2. EMERGENCY LIGHTING EM-X-1 ARE FED FROM BATTERY PACK EM-X.

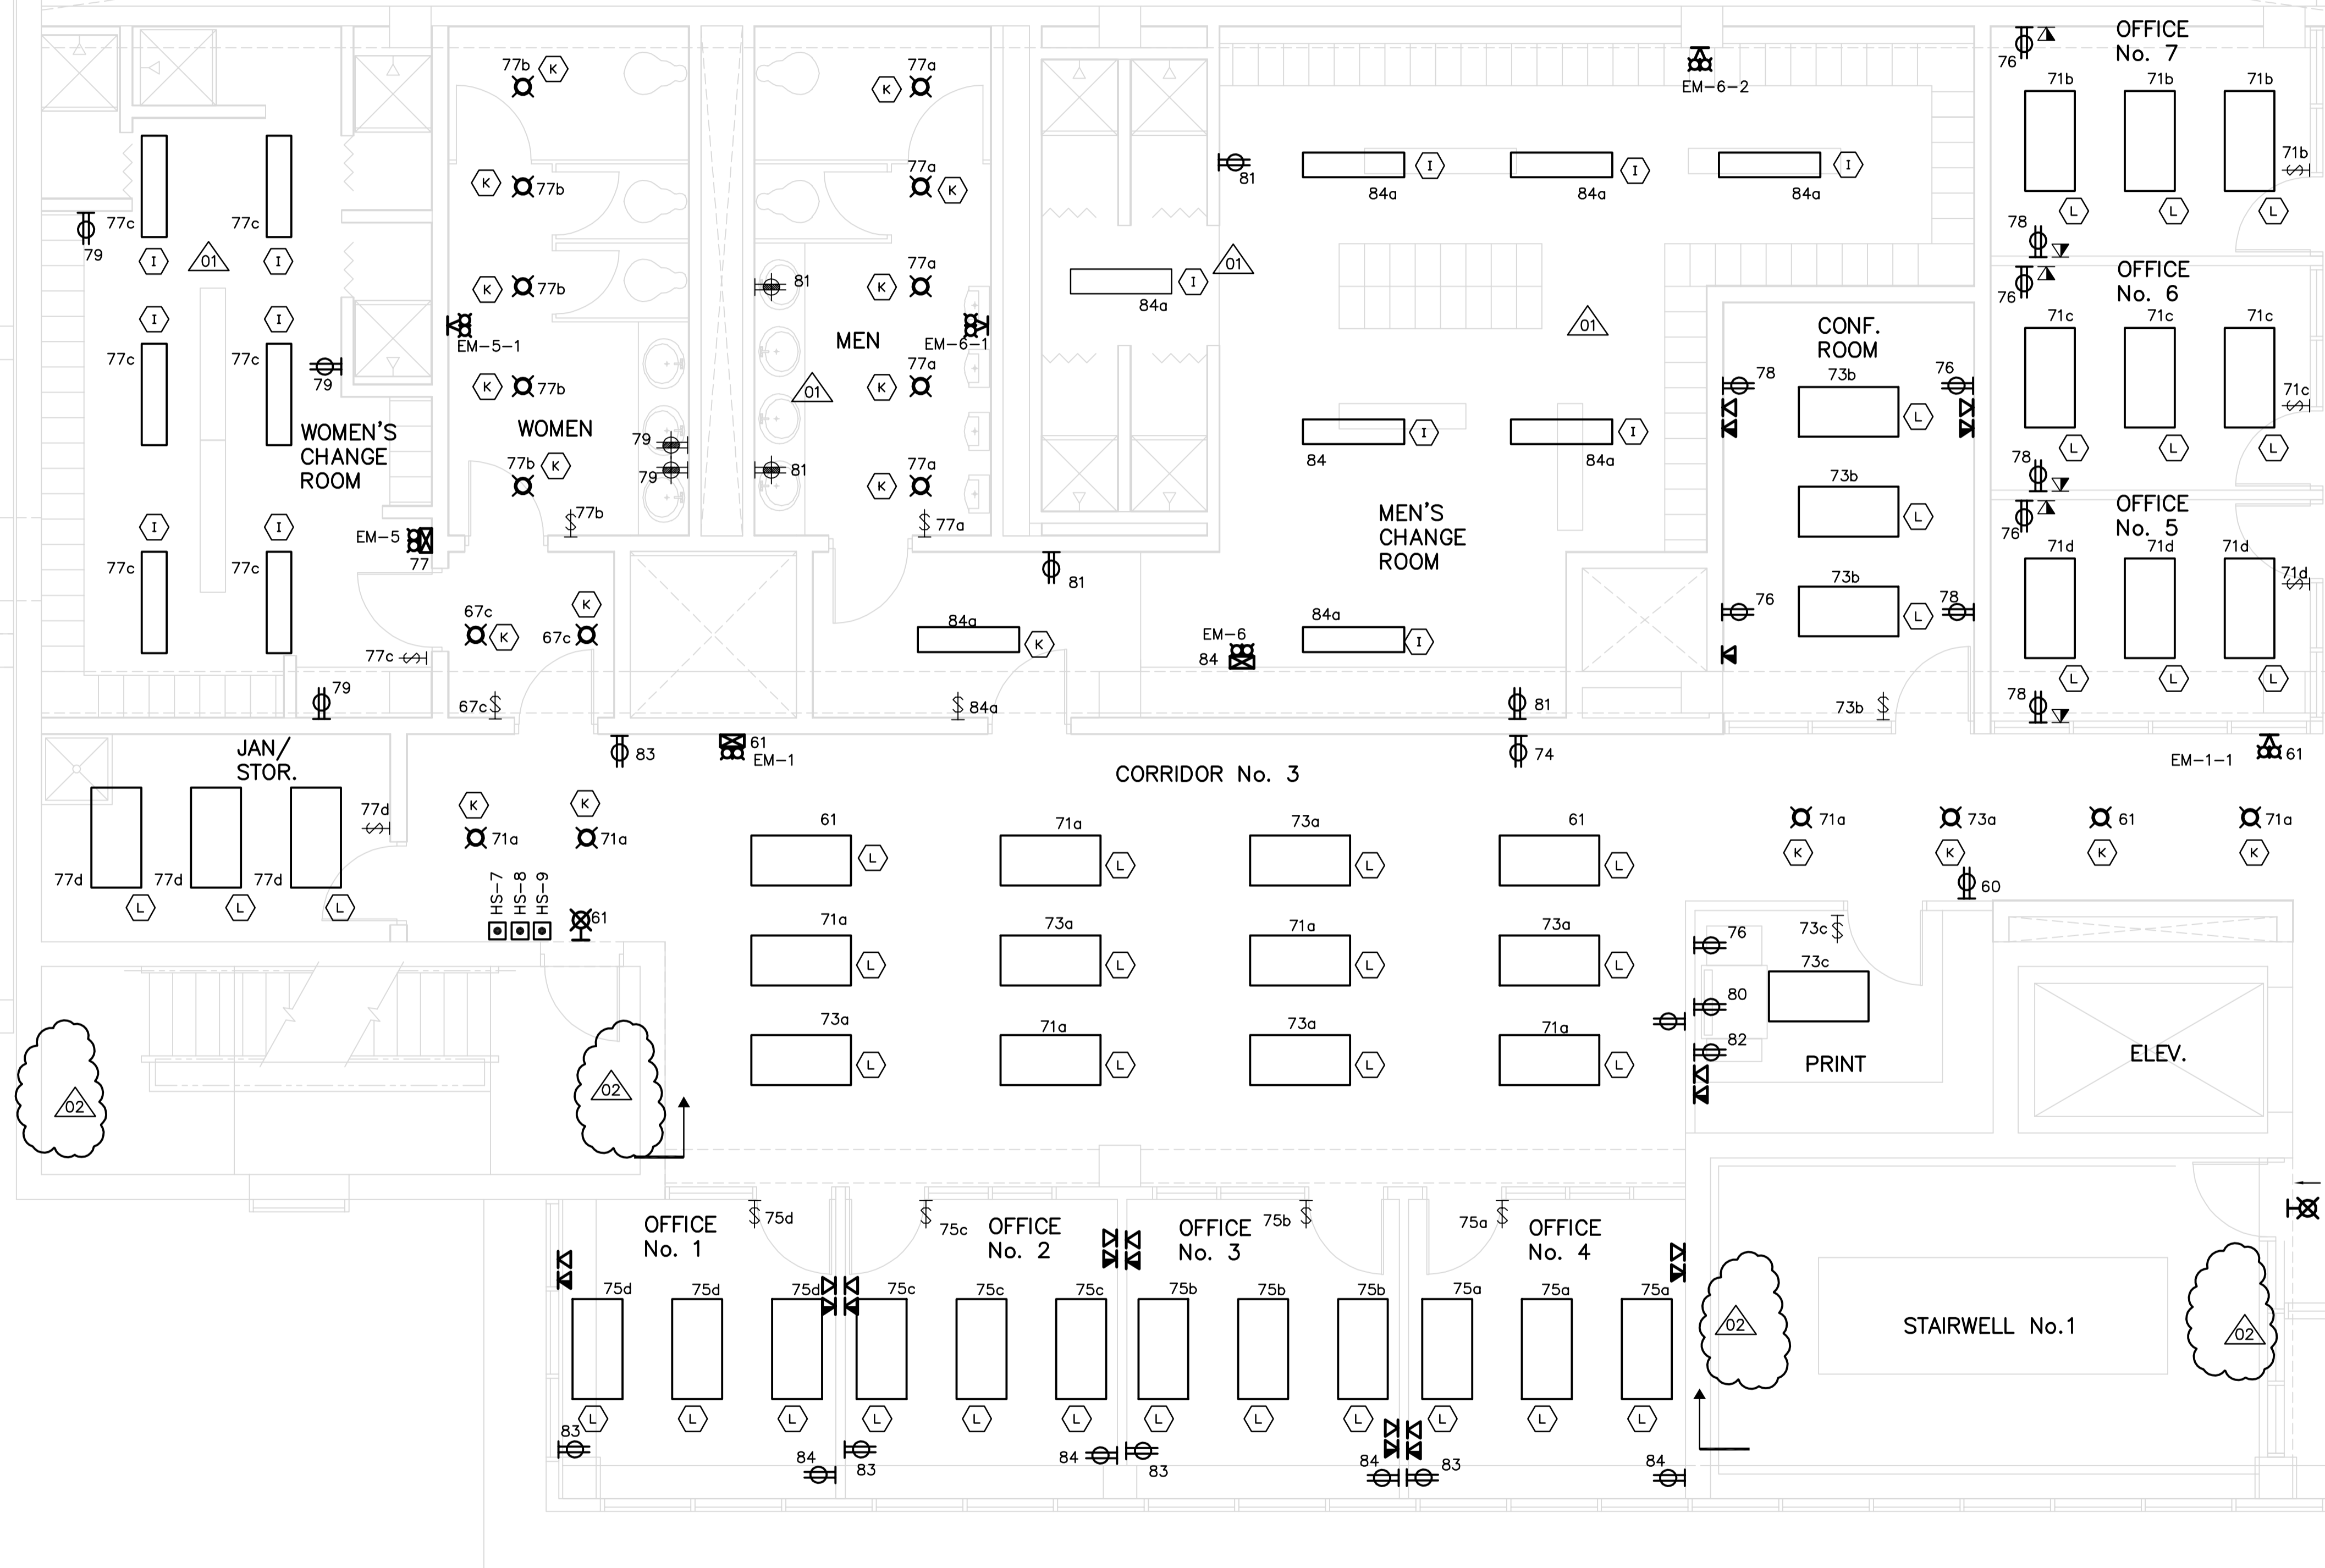

1 THIRD FLOOR POWER AND LIGHTING PLAN
 WA-E0133 N.T.S.

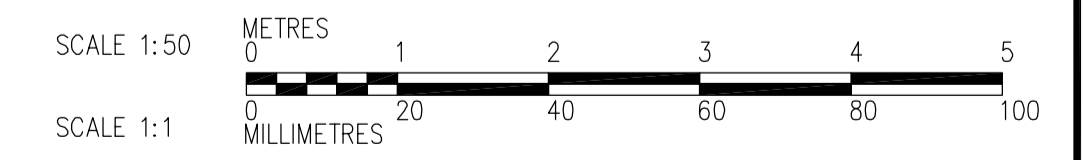

 Certificate of Authorization CH2M HILL Canada Ltd. No. 1441 Expiry: April 30, 2007	B.M. ELEV.	 Frederickson Cooper ARCHITECTS	 A Terra International Ltd. Company	ENGINEER'S SEAL ORIGINAL SIGNED BY L.D. LLEWELLYN 2006/03/29	 THE CITY OF WINNIPEG WATER AND WASTE DEPARTMENT ENGINEERING DIVISION WATER TREATMENT PLANT ADMINISTRATION MECHANICAL AND ELECTRICAL ELECTRICAL ADMINISTRATION AREA THIRD FLOOR POWER AND LIGHTING PLAN	CITY FILE NUMBER
	DESIGNED BY LL CHECKED BY ND			SHEET OF		
	DRAWN BY TL APPROVED BY AHL			CITY DRAWING NUMBER		
	SCALE: 1:50 RELEASED FOR CONSTRUCTION BY: R. SOROKOWSKI DATE 2006/03/10 DATE 2006/03/29			CONSULTANT DRAWING NO. WA-E0402		1-0601A-A-E0402-001-020