

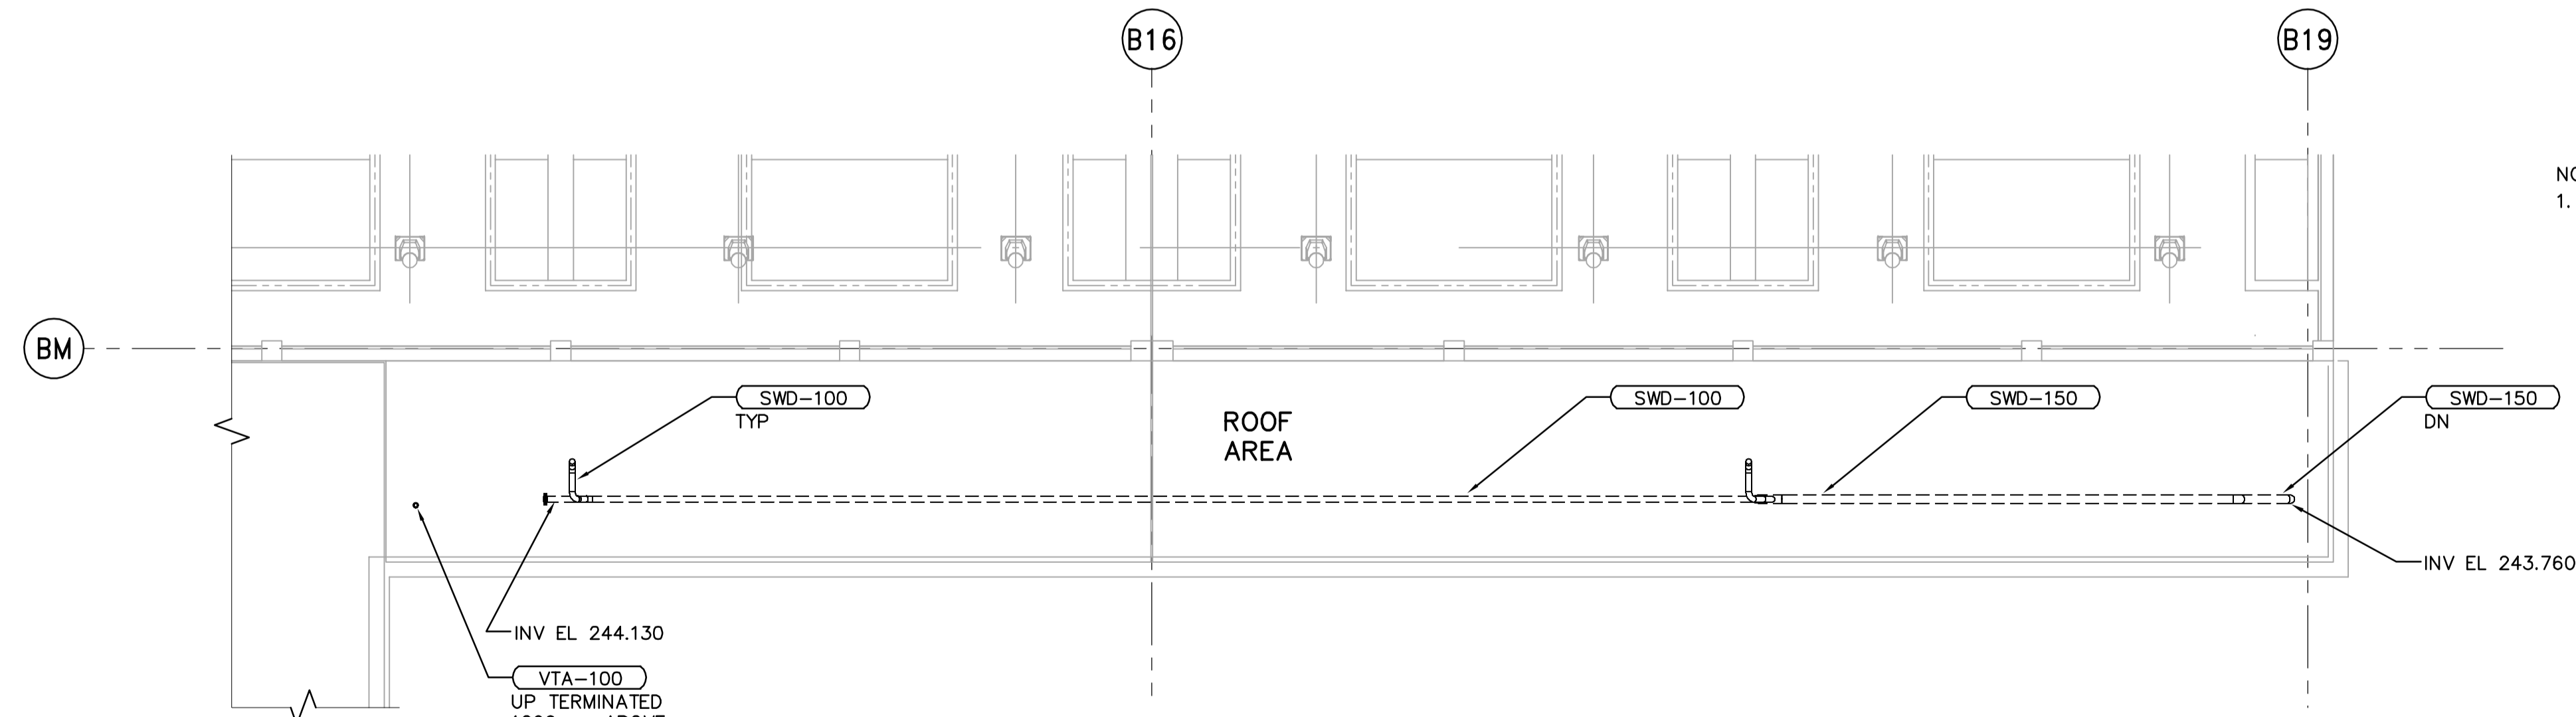


THIRD FLOOR PLAN
1:100

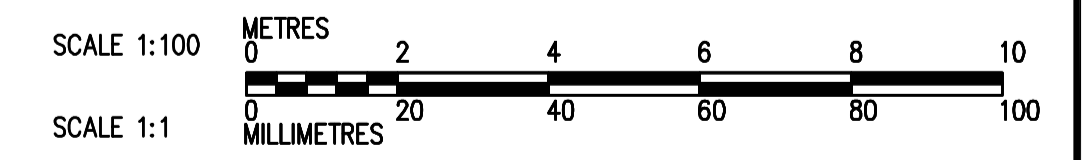

THIRD FLOOR PLAN (CONTINUATION)
1:100

NOTES
1. FOR PLUMBING FIXTURE CONNECTION SIZES, REFER TO FIXTURE CONNECTION SCHEDULE ON DWG. WB-H0533.

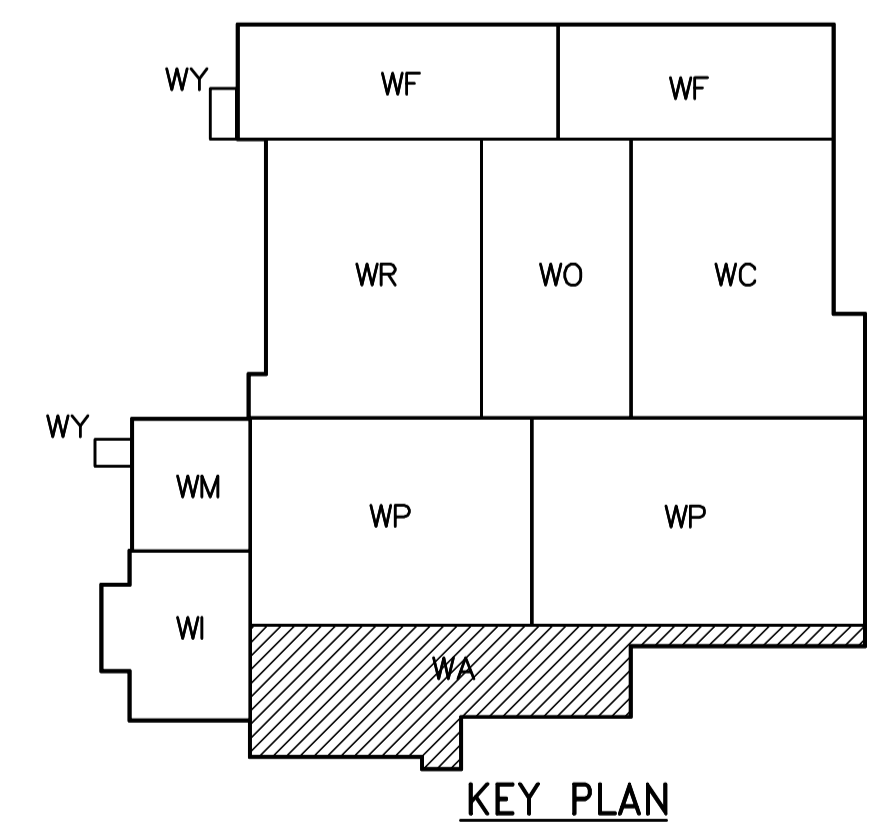

<p>APEGN Certificate of Authorization CH2M HILL Canada Ltd. No. 1441 Expiry: April 30, 2007</p>	B.M. ELEV.	<p>Frederickson Cooper ARCHITECTS</p>	<p>EarthTech A Tyco International Ltd. Company</p>	ENGINEER'S SEAL	<p>THE CITY OF WINNIPEG WATER AND WASTE DEPARTMENT ENGINEERING DIVISION</p>		
				DESIGNED BY JZ/SW		CHECKED BY DL	ORIGINAL SIGNED BY D.K. CUDDINGTON
		DRAWN BY JMcP	APPROVED BY AHL	2006/03/29		WATER TREATMENT PLANT ADMINISTRATION MECHANICAL AND ELECTRICAL	
		SCALE: 1:100	RELEASED FOR CONSTRUCTION BY: R. SOROKOWSKI	CONSULTANT DRAWING NO. WA-H0132		CITY FILE NUMBER SHEET OF CITY DRAWING NUMBER 1-0601A-A-H0132-001-01D	
	NO. REVISIONS	DATE	DATE	2005/07/15	DATE	2006/03/29	PLUMBING ADMINISTRATION AREA THIRD FLOOR PLAN