
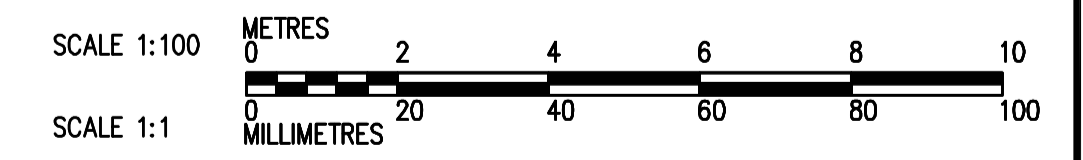


ROOF PLAN  
1:100

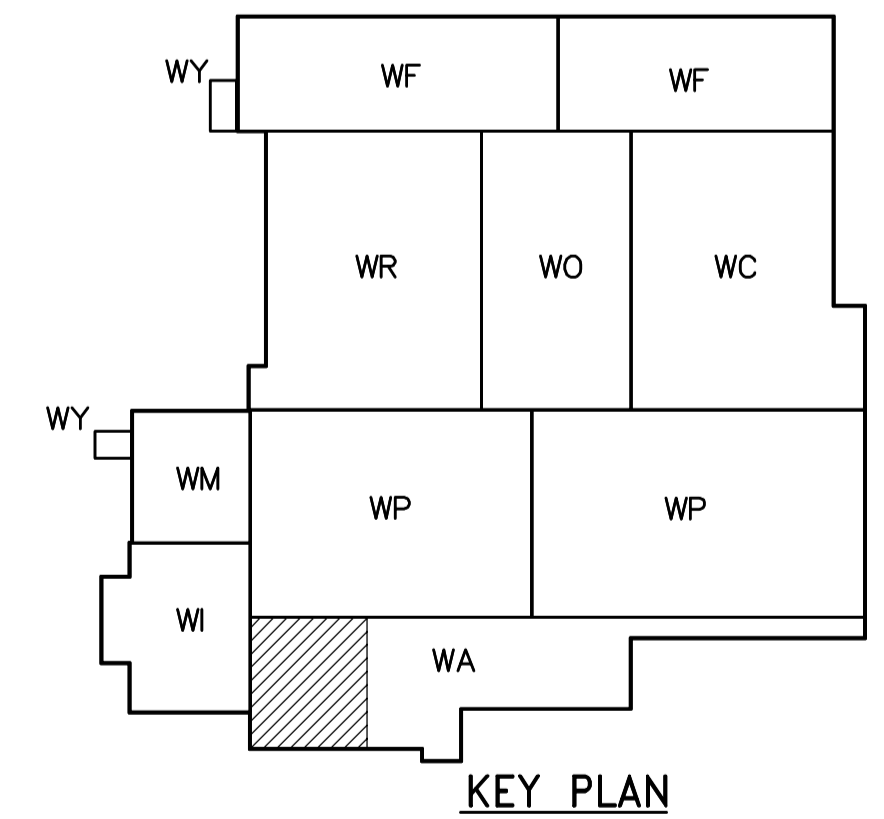

<p><b>APEGN</b> Certificate of Authorization CH2M HILL Canada Ltd. No. 1441 Expiry: April 30, 2007</p>	<p>Frederickson Cooper ARCHITECTS</p>		<p>A Terra International Ltd. Company</p>		ENGINEER'S SEAL  ORIGINAL SIGNED BY D.K. CUDDINGTON  2006/03/29	<p><b>THE CITY OF WINNIPEG</b> WATER AND WASTE DEPARTMENT ENGINEERING DIVISION</p>	WATER TREATMENT PLANT ADMINISTRATION MECHANICAL AND ELECTRICAL	CITY FILE NUMBER SHEET OF
	DESIGNED BY JZ/SW DRAWN BY JMcP		CHECKED BY DL APPROVED BY AHL		CONSULTANT DRAWING NO. WA-H0146		PLUMBING ADMINISTRATION AREA ROOF PLAN	CITY DRAWING NUMBER 1-0601A-A-H0146-001-01D
	SCALE: 1:100		RELEASED FOR CONSTRUCTION BY: R. SOROKOWSKI					
	NO. REVISIONS 01 742-2005 ADDENDUM 5 06/05/19 SW 00 ISSUED FOR TENDER 06/03/29 SW		DATE BY DATE 2005/07/15 DATE 2006/03/29					