



- NOTES:**
- REFER TO DWG WM-E0011 AND WM-H0001 FOR SYMBOL LEGENDS.
 - REFER TO HVAC DRAWINGS FOR DUCT MOUNTED SMOKE DETECTOR LOCATIONS.

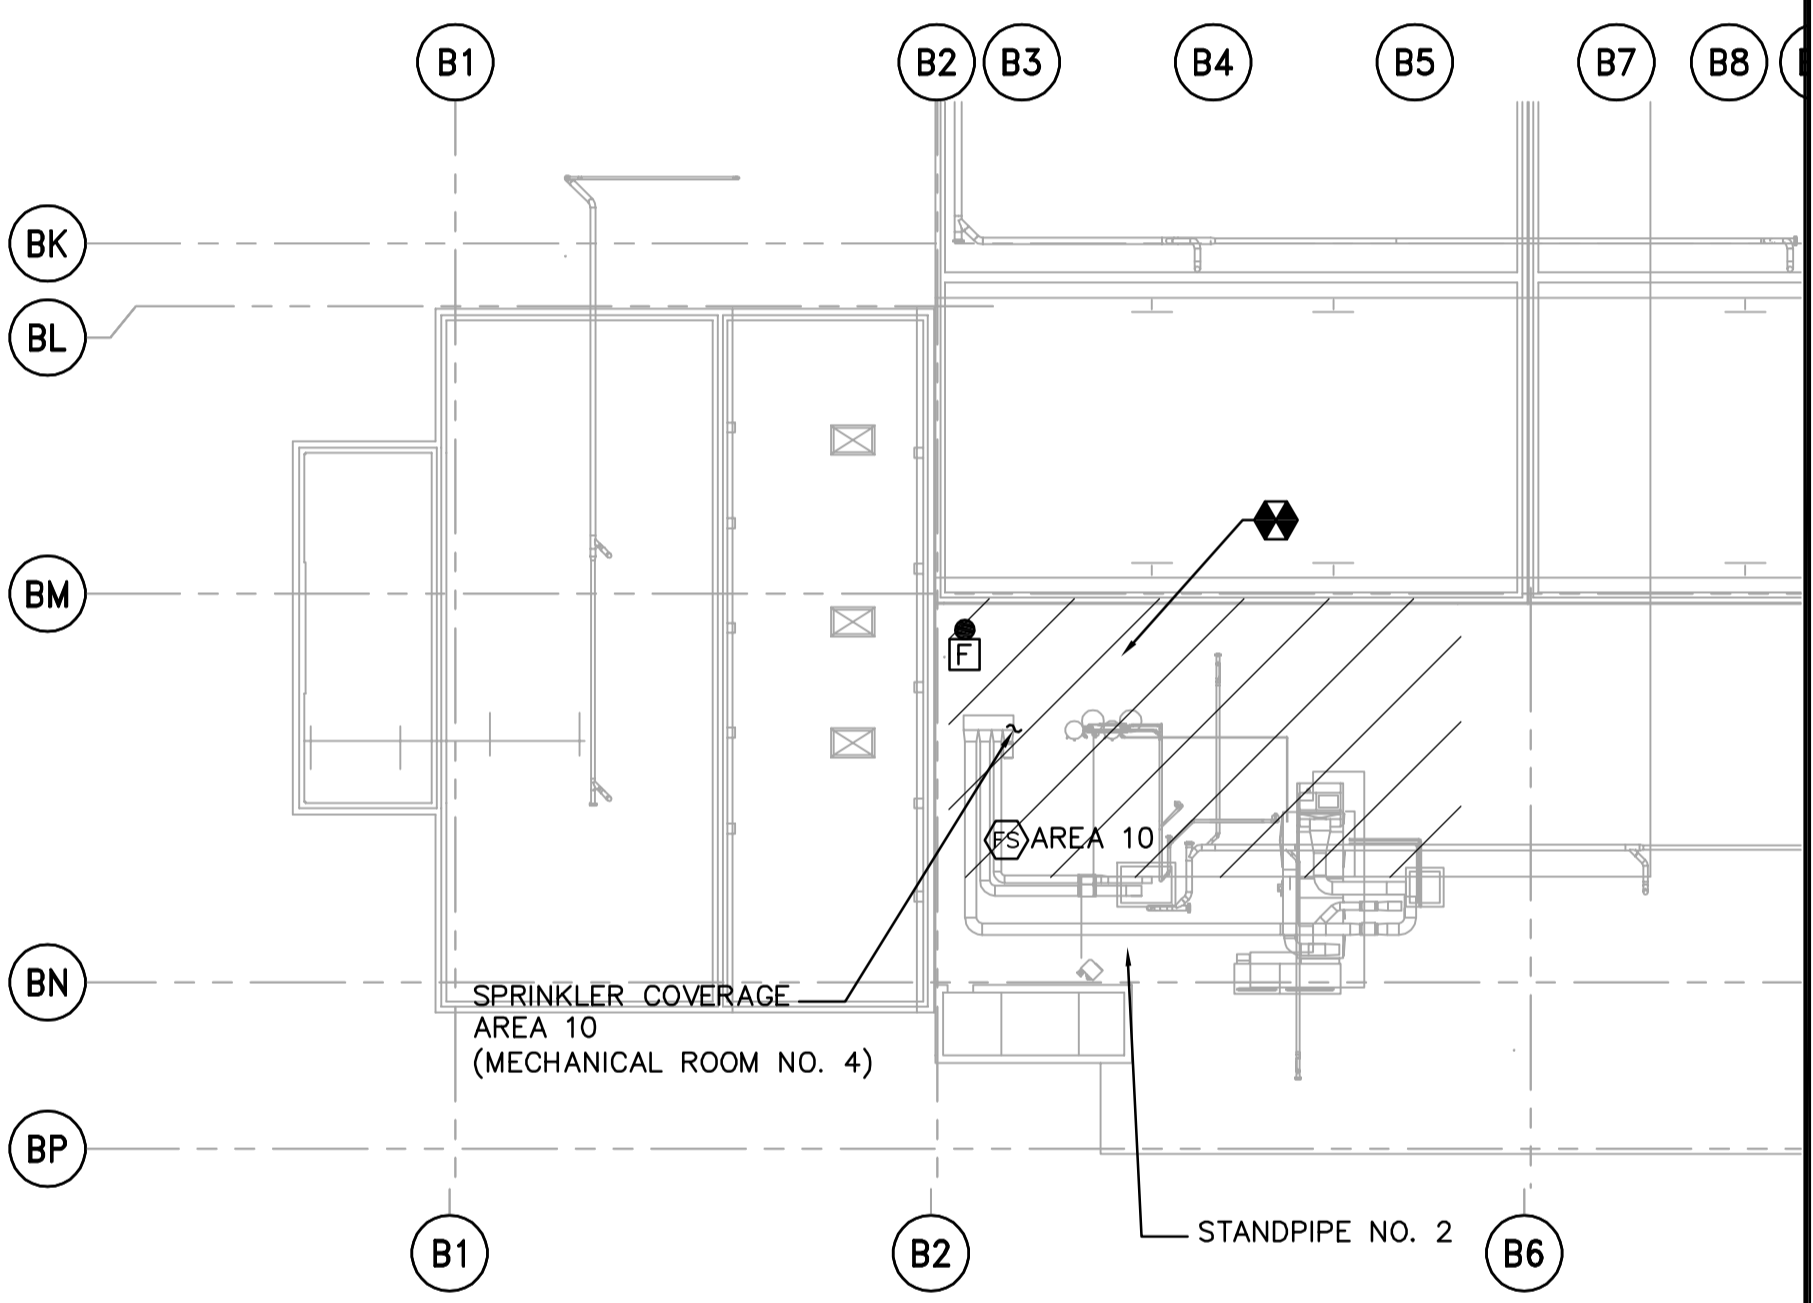

PARTIAL PLAN AT ELEVATION 251.450
1:300

THIRD FLOOR PLAN
1:300

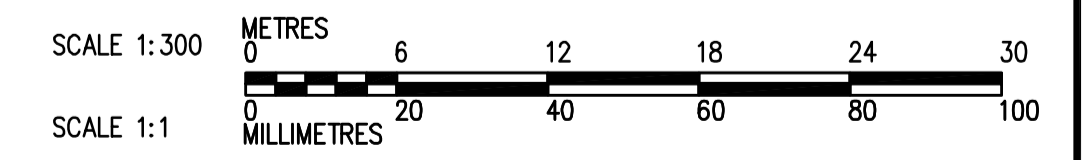

<p>APEGN Certificate of Authorization CH2M HILL Canada Ltd. No. 1441 Expiry: April 30, 2007</p>	<p>Frederickson Cooper ARCHITECTS</p>		<p>EarthTech A Tyco International Ltd. Company</p>		ENGINEER'S SEAL ORIGINAL SIGNED BY D.K. CUDDINGTON 2006/03/29	<p>THE CITY OF WINNIPEG WATER AND WASTE DEPARTMENT ENGINEERING DIVISION</p>	WATER TREATMENT PLANT MAIN BUILDING MECHANICAL AND ELECTRICAL	CITY FILE NUMBER SHEET OF
	DESIGNED BY DKC DRAWN BY JMCP		CHECKED BY SW APPROVED BY AHL		CONSULTANT DRAWING NO. WB-H0132		CITY DRAWING NUMBER 1-0601B-A-H0132-001-01D	
	SCALE: 1:300		RELEASED FOR CONSTRUCTION BY: R. SOROKOWSKI		FIRE PROTECTION OVERALL BUILDING THIRD FLOOR PLAN			
	NO. REVISIONS 01 742-2005 ADDENDUM 5 06/05/19 DKC 00 ISSUED FOR TENDER 06/03/29 DKC		DATE BY DATE 2006/01/06 DATE 2006/03/29					