


- NOTES:**
1. PROVIDE FIRE DAMPER AT ALL DUCT PENETRATION THRU FLOOR.

**THIRD FLOOR PLAN**  
1:100

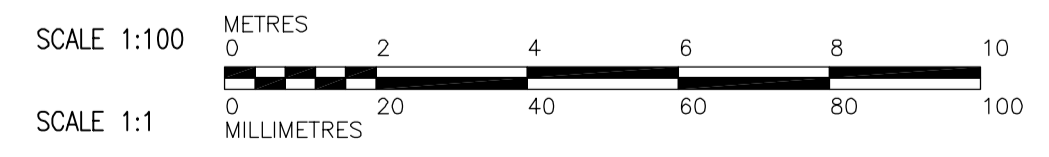

<p><b>APEGN</b> Certificate of Authorization CH2M HILL Canada Ltd. No. 1441 Expiry: April 30, 2007</p>	B.M. ELEV.	<p>Frederickson Cooper ARCHITECTS</p>	<p>EarthTech A Tyco International Ltd. Company</p>	ENGINEER'S SEAL	<p><b>THE CITY OF WINNIPEG</b> WATER AND WASTE DEPARTMENT ENGINEERING DIVISION</p>	
	DESIGNED BY TT			CHECKED BY DL		ORIGINAL SIGNED BY D.K. CUDDINGTON
	DRAWN BY AM			APPROVED BY AHL		2006/03/29
	SCALE: 1:100			RELEASED FOR CONSTRUCTION BY: R. SOROKOWSKI		CONSULTANT DRAWING NO. WF-H0131
NO. REVISIONS	DATE BY	DATE 2005/08/19	DATE 2006/03/29	HVAC FILTRATION AREA 1 THIRD FLOOR PLAN	CITY FILE NUMBER SHEET OF CITY DRAWING NUMBER 1-0601F-A-H0131-001-01D	