



SECTION A-A
1:50

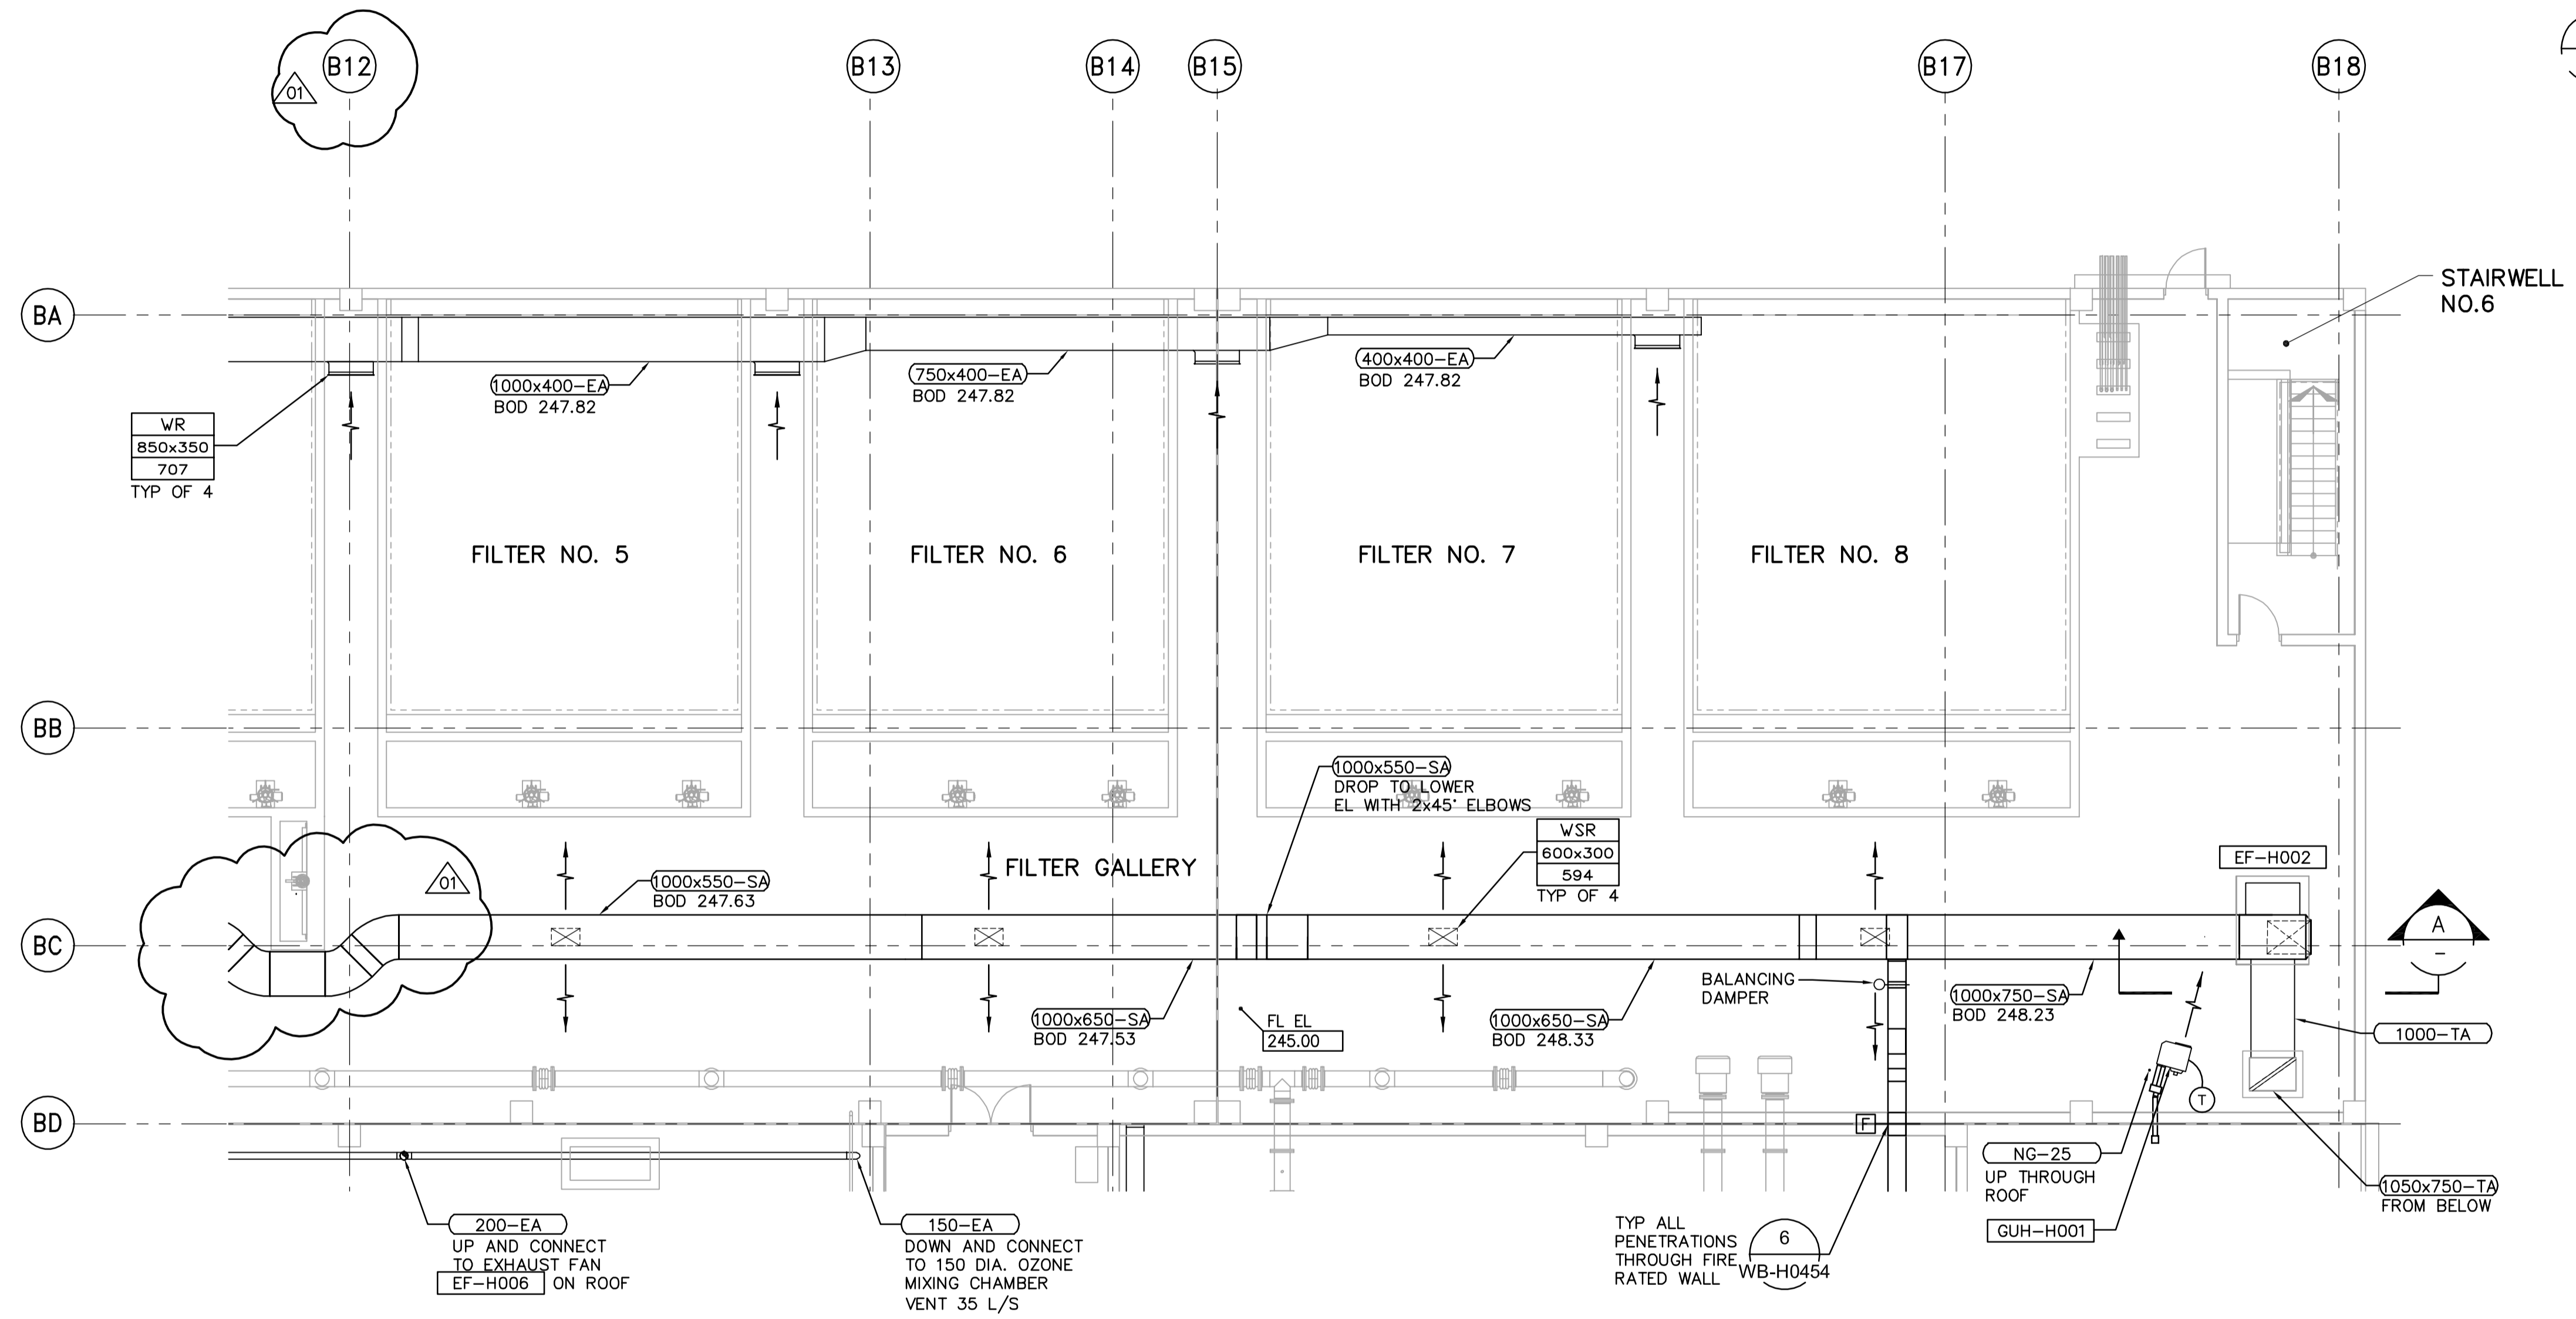


THIRD FLOOR PLAN
1:100

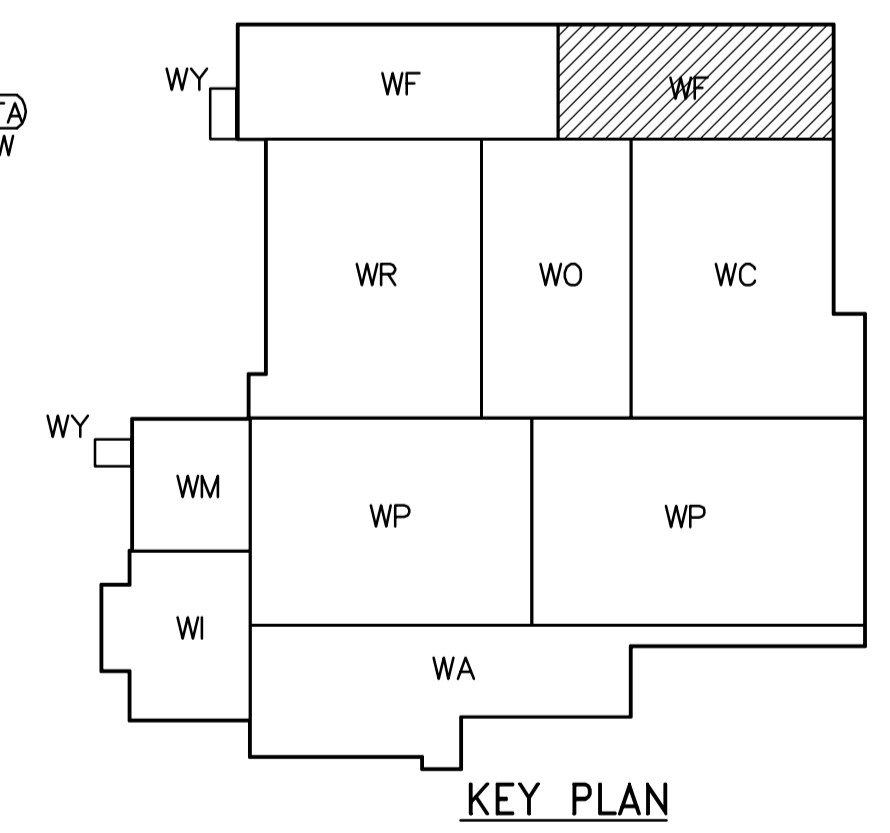

KEY PLAN

- NOTES:
1. PROVIDE FIRE DAMPER AT ALL DUCT PENETRATION THRU FLOOR.

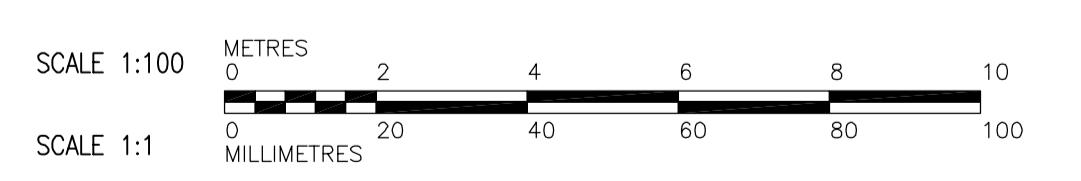

<p>APEGN Certificate of Authorization CH2M HILL Canada Ltd. No. 1441 Expiry: April 30, 2007</p>	<table border="1"> <tr><td>B.M. ELEV.</td><td></td><td></td><td></td></tr> <tr><td></td><td></td><td></td><td></td></tr> <tr><td></td><td></td><td></td><td></td></tr> <tr><td></td><td></td><td></td><td></td></tr> </table>	B.M. ELEV.																<p>Frederickson Cooper ARCHITECTS</p>	<p>EarthTech A Tyco International Ltd. Company</p>	ENGINEER'S SEAL	<p>THE CITY OF WINNIPEG WATER AND WASTE DEPARTMENT ENGINEERING DIVISION</p>
		B.M. ELEV.																			
DESIGNED BY TT	CHECKED BY DL	ORIGINAL SIGNED BY D.K. CUDDINGTON	CITY FILE NUMBER																		
DRAWN BY AM	APPROVED BY AHL	2006/03/29	SHEET OF																		
SCALE: 1:100	RELEASED FOR CONSTRUCTION BY: R. SOROKOWSKI	CONSULTANT DRAWING NO. WF-H0132	CITY DRAWING NUMBER 1-0601F-A-H0132-001-01D																		
NO. REVISIONS	DATE BY	DATE 2005/08/19	DATE 2006/03/29	<p>HVAC FILTRATION AREA 2 THIRD FLOOR PLAN</p>																	