


FIRST FLOOR PLAN
1:100

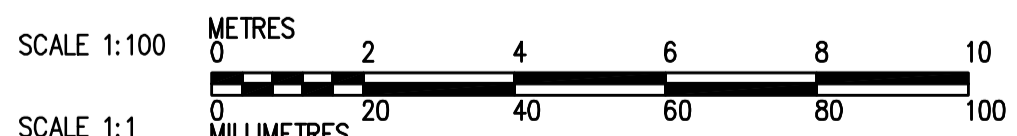

<p>Certificate of Authorization CH2M HILL Canada Ltd. No. 1441 Expiry: April 30, 2007</p>	B.M. ELEV.	<p>Frederickson Cooper ARCHITECTS</p>	<p>A You International Ltd. Company</p>	ENGINEER'S SEAL	<p>THE CITY OF WINNIPEG WATER AND WASTE DEPARTMENT ENGINEERING DIVISION</p>	
				DESIGNED BY JZ/SW		CHECKED BY DL
		DRAWN BY JMcP	APPROVED BY AHL	2006/03/29		WATER TREATMENT PLANT FLOCCULATION AND DAF MECHANICAL AND ELECTRICAL
		SCALE: 1:100	RELEASED FOR CONSTRUCTION BY: R. SOROKOWSKI	CONSULTANT DRAWING NO. WP-H0114		CITY FILE NUMBER
	01 742-2005 ADDENDUM 5 06/05/19 SW	DATE 2005/07/15	DATE 2006/03/29		SHEET OF	
	00 ISSUED FOR TENDER 06/03/29 SW				CITY DRAWING NUMBER	
	NO. REVISIONS	DATE	DATE		1-0601P-A-H0114-001-01D	
					PLUMBING FLOC/DAF AREA 2 FIRST FLOOR PLAN	