


ROOF PLAN
1:100

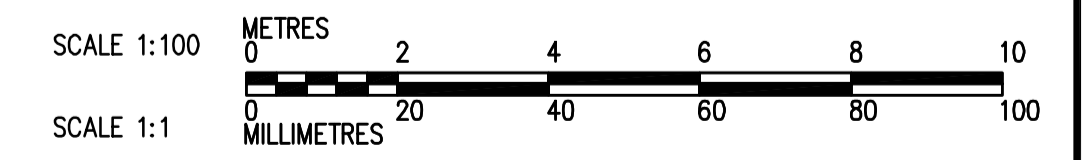

 Certificate of Authorization CH2M HILL Canada Ltd. No. 1441 Expiry: April 30, 2007	B.M. ELEV.	 Frederickson Cooper ARCHITECTS	 A Terra International Ltd. Company	ENGINEER'S SEAL ORIGINAL SIGNED BY D.K. CUDDINGTON 2006/03/29	 THE CITY OF WINNIPEG WATER AND WASTE DEPARTMENT ENGINEERING DIVISION WATER TREATMENT PLANT FLOCCULATION AND DAF MECHANICAL AND ELECTRICAL PLUMBING FLOC/DAF AREA 1 ROOF PLAN	CITY FILE NUMBER
	DESIGNED BY JZ/SW	CHECKED BY DL	CONSULTANT DRAWING NO. WP-H0143	SHEET OF		
	DRAWN BY JMcP	APPROVED BY AHL	RELEASED FOR CONSTRUCTION BY: R. SOROKOWSKI	CITY DRAWING NUMBER 1-0601P-A-H0143-001-01D		
	SCALE: 1:100	DATE 2005/07/15	DATE 2006/03/29			