


THIRD FLOOR PLAN
1:100

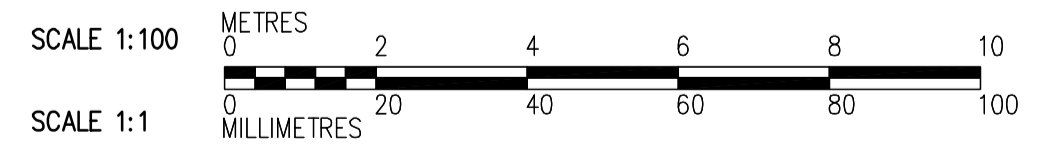

<p>Certificate of Authorization CH2M HILL Canada Ltd. No. 1441 Expiry: April 30, 2007</p>	B.M. ELEV.	<p>Frederickson Cooper ARCHITECTS</p>	<p>A Terra International Ltd. Company</p>	ENGINEER'S SEAL	<p>THE CITY OF WINNIPEG WATER AND WASTE DEPARTMENT ENGINEERING DIVISION</p>	
				DESIGNED BY TT		CHECKED BY DL
		DRAWN BY AM	APPROVED BY AHL	2006/03/29		WATER TREATMENT PLANT INLET WORKS AND RAW WATER PUMPING MECHANICAL AND ELECTRICAL
		SCALE: 1:100	RELEASED FOR CONSTRUCTION BY: R. SOROKOWSKI	CONSULTANT DRAWING NO. WI-H0131		CITY FILE NUMBER SHEET OF CITY DRAWING NUMBER 1-06011-A-H0131-001-01D
	NO. REVISIONS	DATE	DATE	DATE	HVAC RAW WATER PUMP STATION AREA THIRD FLOOR PLAN	