


TUNNEL VENTILATION PLAN
SCALE: 1:100

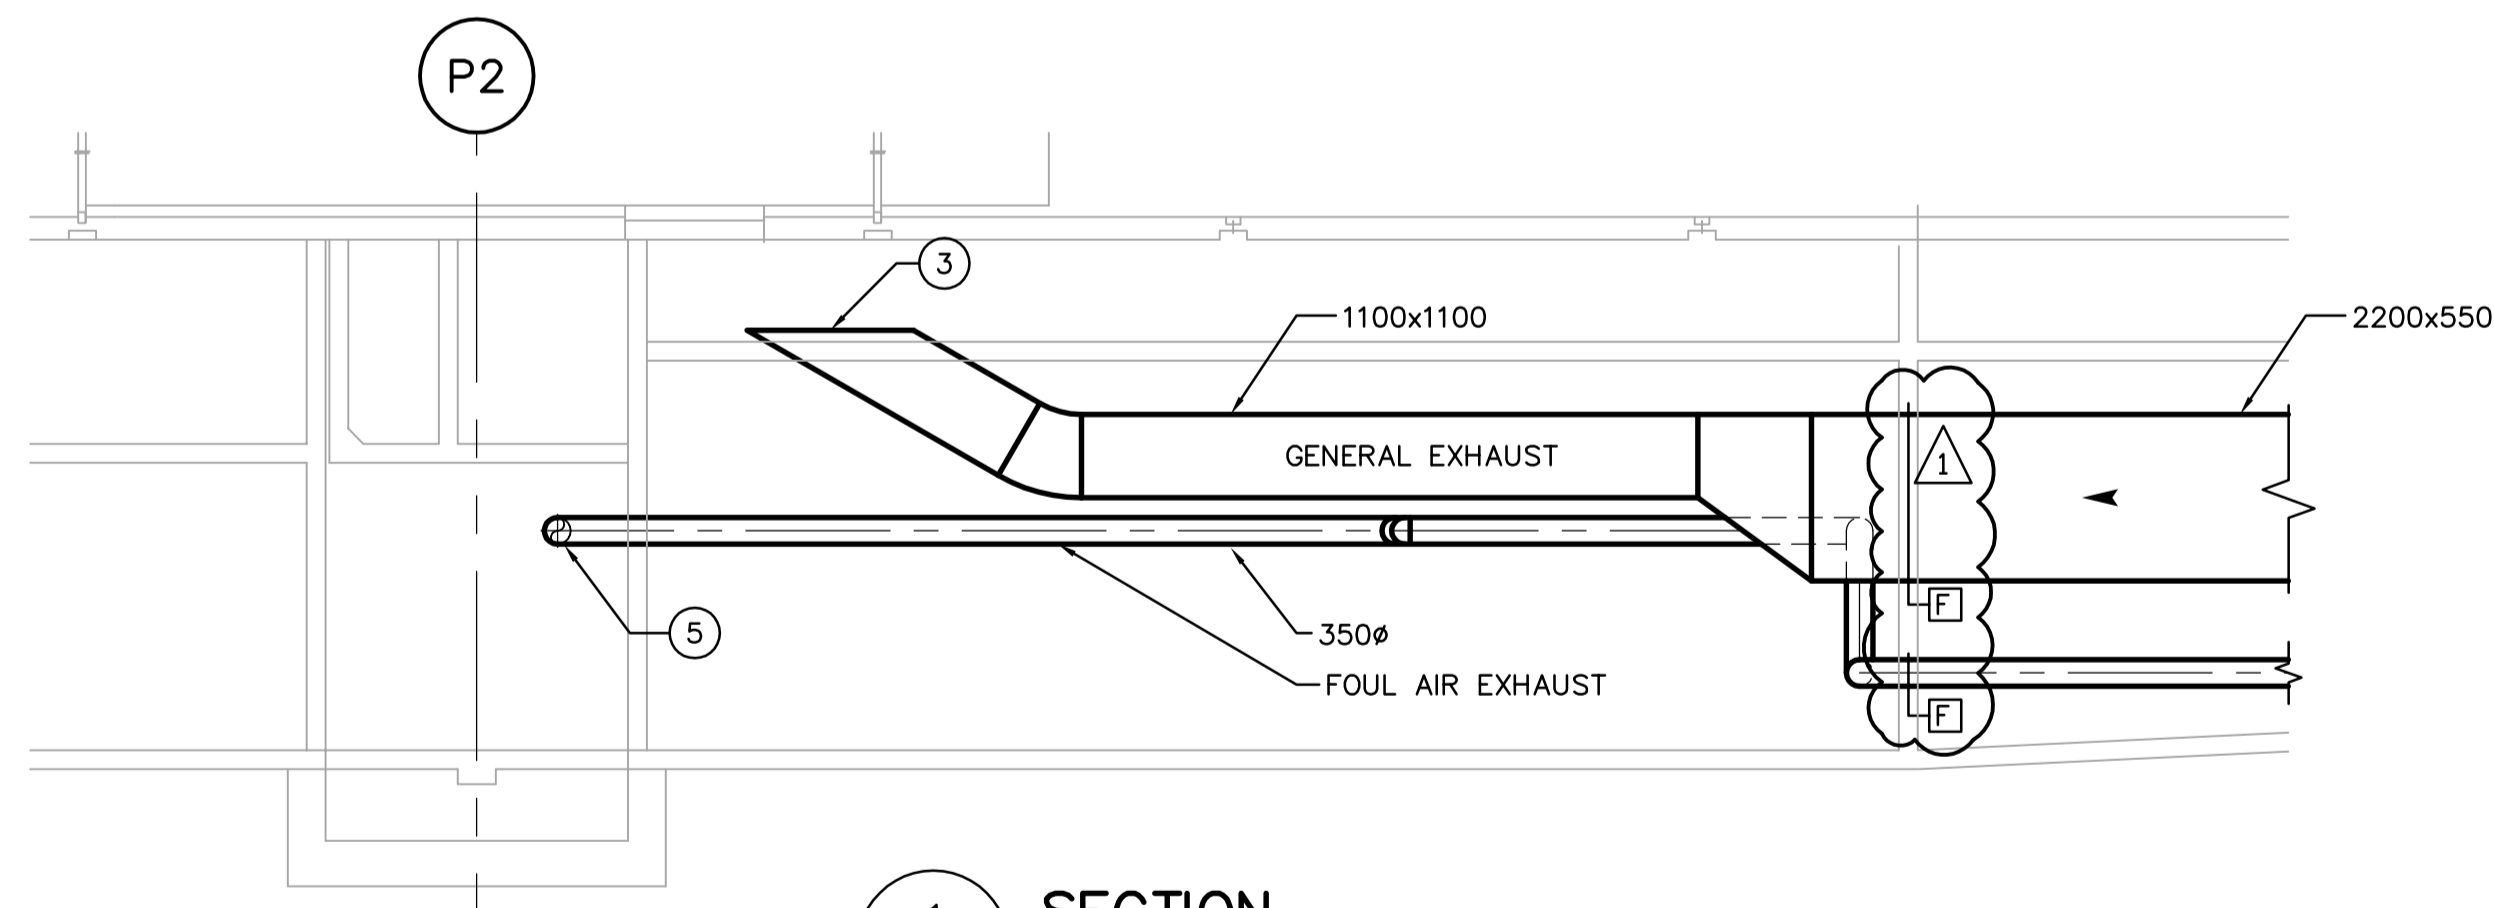

1 SECTION
PM2.01 SCALE 1:50

DRAWING NOTES

- ① EXHAUST FROM SLUDGE HOLDING TANKS AND DAF TANKS.
- ② TO THERMAL OXIDIZER. FOR CONTINUATION SEE DRAWING FM2.01.
- ③ TIE INTO EXISTING DUCT AT PRIMARY CLARIFIER.
- ④ FOR CONTINUATION SEE DRAWING HM2.02.
- ⑤ TO FERMENTER GALLERY.

GENERAL NOTES

- 1. COORDINATE WITH OTHER TRADES SO AS TO PREVENT CONFLICTS.
- 2. ALL DUCTWORK SHALL BE SUPPORTED AND SUSPENDED AS PER SPECIFICATIONS AND LOCAL CODES. (SEE DETAILS)



B.M. ELEV.				ENGINEER'S SEAL	
				ORIGINAL SIGNED BY	
DESIGNED BY	DC	CHECKED BY	PVL	A. BURACHYNSKY	
DRAWN BY	DC	APPROVED BY	JEH	2006/04/26	
HOR. SCALE: AS NOTED		RELEASED FOR CONSTRUCTION BY:		CONSULTANT DRAWING NO.	
00 ISSUED FOR TENDER		J. VEILLEUX		PM2.01	
NO. REVISIONS	DATE	BY	DATE	2006/01/02	
				2006/04/26	

THE CITY OF WINNIPEG
 WATER AND WASTE DEPARTMENT
 ENGINEERING DIVISION

WEWPC
BIOLOGICAL NUTRIENT REMOVAL UPGRADE
CONTRACT 3

MECHANICAL
 AREA P - PRIMARY CLARIFIERS
 TUNNEL VENTILATION PLAN

CITY FILE NUMBER
 SHEET OF
 CITY DRAWING NUMBER