


1 NEW MAIN FLOOR PLAN
SS6.01 SCALE 1:50

NOTE:


1. DIMENSIONS NOTED ARE APPROXIMATE. SITE CONFIRM ALL DIMENSIONS PRIOR TO CONSTRUCTION.
2. SHORE EXISTING STRUCTURE AS REQUIRED TO SUIT NEW CONSTRUCTION

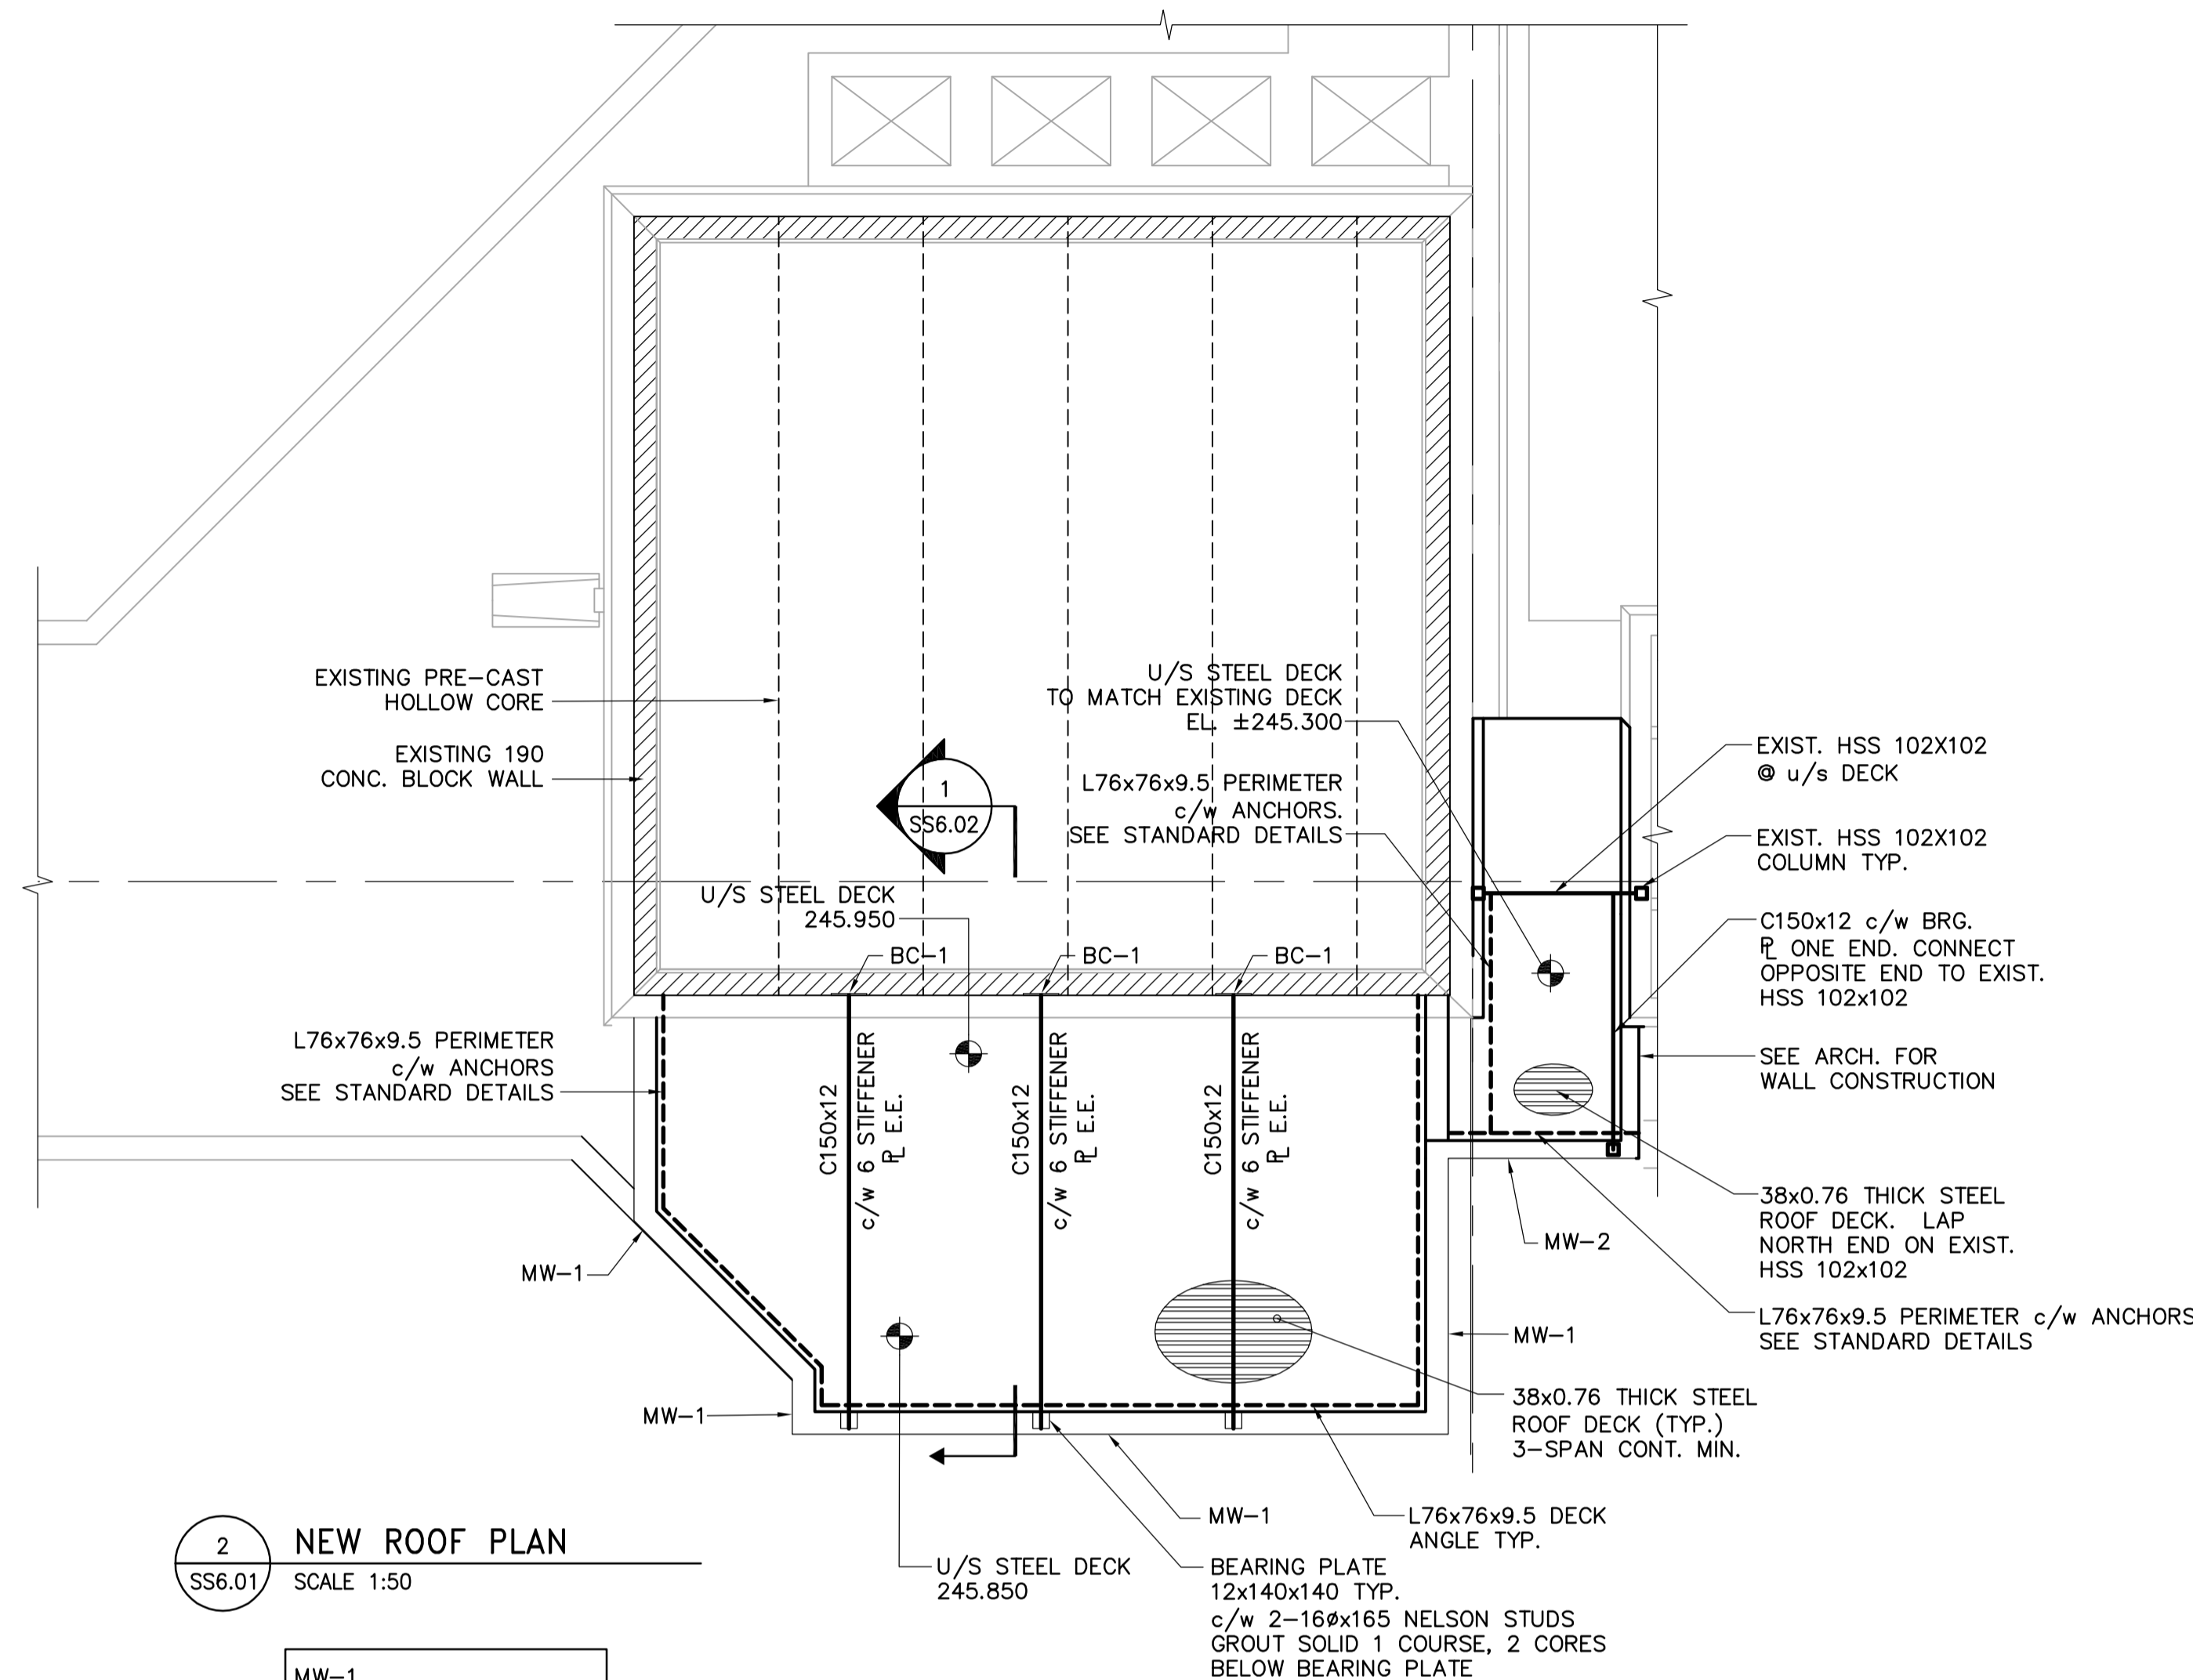

2 NEW ROOF PLAN
SS6.01 SCALE 1:50

MW-1
190 CONC. BLOCK
1-15M VERT. @ 1000 o/c

MW-2
140 CONC. BLOCK
1-10M VERT. @ 1000 o/c

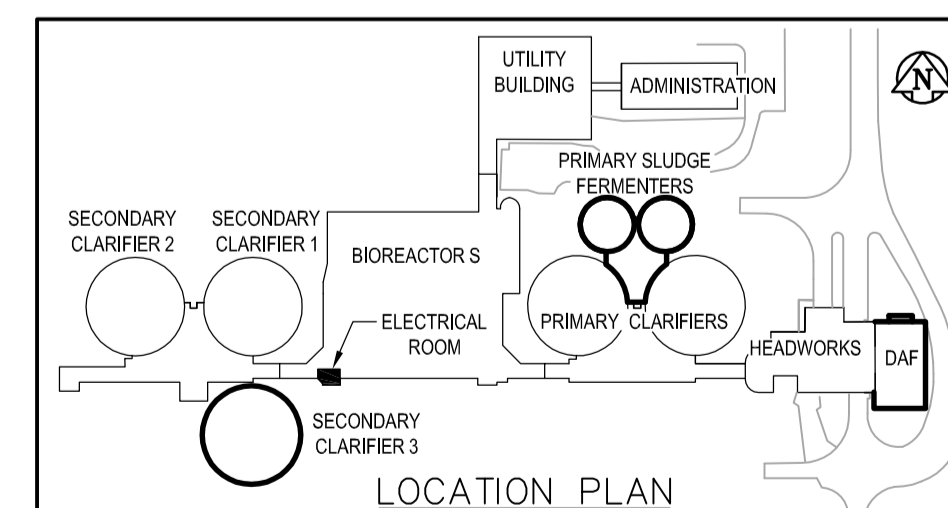

APEGM
Certificate of Authorization
Earth Tech Canada Inc.
No. 730 Expiry: April 30, 2006

<p>EarthTech A Tyco International Ltd. Company</p>		ENGINEER'S SEAL ORIGINAL SIGNED BY J. BETKE 2006/04/26 CONSULTANT DRAWING NO. SS6.01	
DESIGNED BY	AA/JB	CHECKED BY	AA/JB
DRAWN BY	WDB	APPROVED BY	JEH
HOR. SCALE: AS NOTED		RELEASED FOR CONSTRUCTION BY:	
VERTICAL SCALE: AS NOTED		J. VEILLEUX	
NO.	REVISIONS	DATE	DATE
01	21-2006 ADDENDUM 3	06/05/19	SRP
00	ISSUED FOR TENDER	06/04/26	CMF
2006/04/26		2006/04/26	

THE CITY OF WINNIPEG
WATER AND WASTE DEPARTMENT
ENGINEERING DIVISION

WEWPC
EFFLUENT DISINFECTION FACILITY
CONTRACT No. 2

STRUCTURAL
AREA S - BIOREACTORS
ELECTRICAL ROOM PLANS

CITY FILE NUMBER
SHEET OF
CITY DRAWING NUMBER