



1 NEW ROOF PLAN  
SA6.02 SCALE 1:50

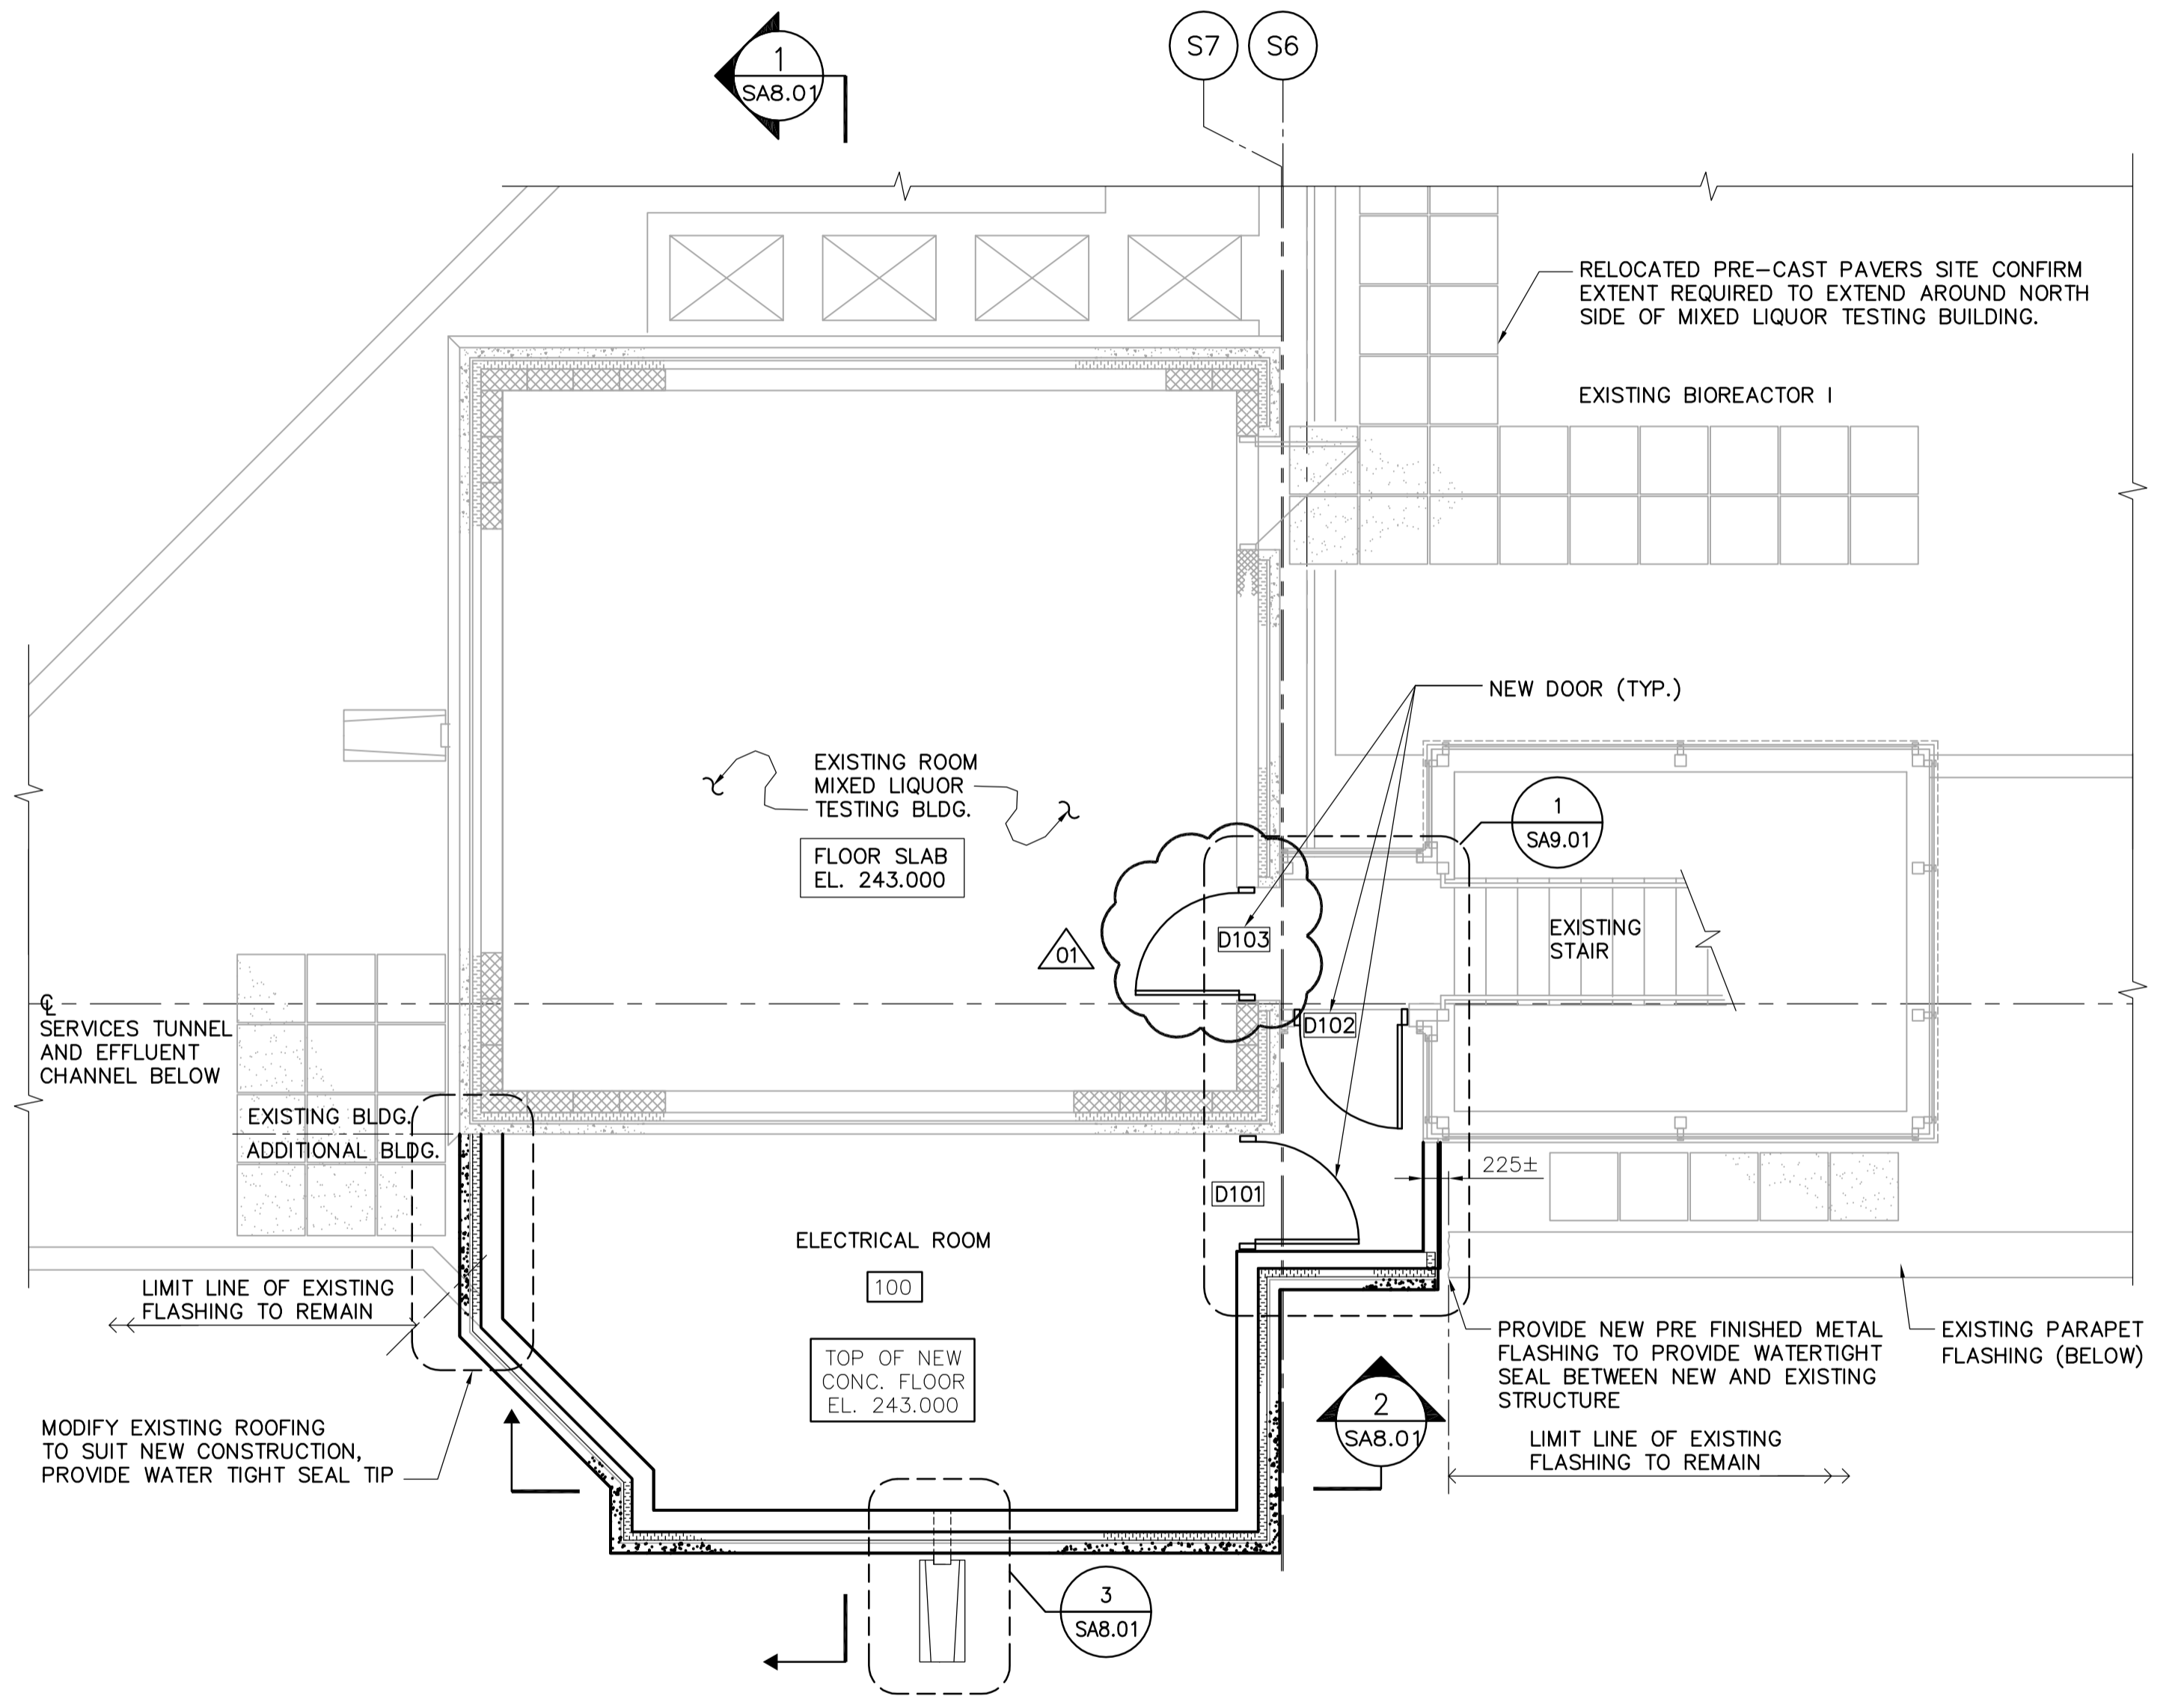

2 NEW MAIN FLOOR PLAN  
SA6.02 SCALE 1:50

DRAWING NOTES:

1. DIMENSIONS NOTED ARE APPROXIMATE. SITE CONFIRM ALL DIMENSION PRIOR TO CONSTRUCTION.

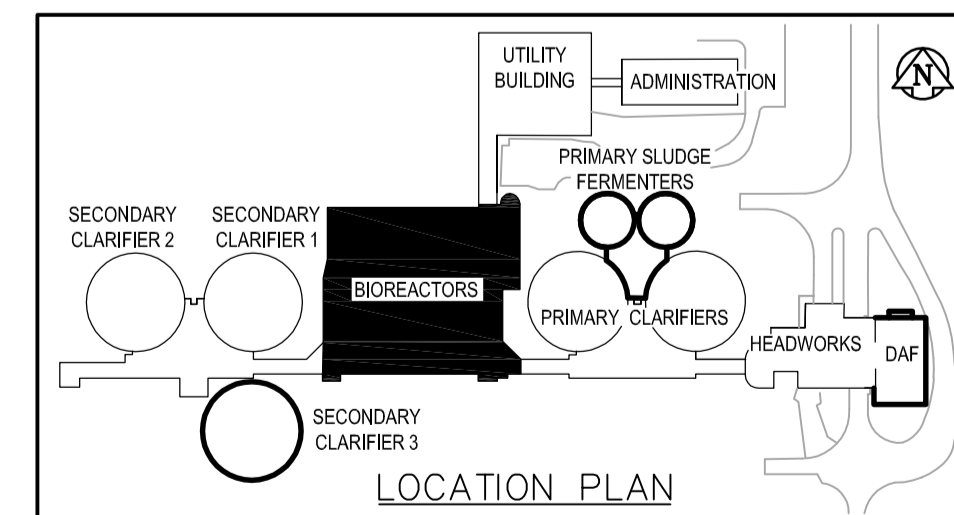

B.M. ELEV.					
01	21-2006 ADDENDUM 6	06/07/05	LK		
00	ISSUED FOR TENDER	06/04/26	CMF		
NO.	REVISIONS	DATE	BY	DATE	

**EarthTech**  
A Tyco International Ltd. Company

DESIGNED BY: GGP	CHECKED BY: NC
DRAWN BY: GGP	APPROVED BY: JEH
HOR. SCALE: AS NOTED	RELEASED FOR CONSTRUCTION BY: J. VEILLEUX
VERTICAL SCALE: AS NOTED	DATE: 2005/12/27
DATE: 2005/12/27	DATE: 2006/04/26

ENGINEER'S SEAL  
ORIGINAL SIGNED BY  
N. COOPER  
2006/04/26  
CONSULTANT DRAWING NO.  
SA6.02

**THE CITY OF WINNIPEG**  
WATER AND WASTE DEPARTMENT  
ENGINEERING DIVISION

**WEWPC**  
BIOLOGICAL NUTRIENT REMOVAL UPGRADE  
CONTRACT No. 3

ARCHITECTURAL  
AREA S - BIореACTORS  
ELECTRICAL ROOM NEW ROOF & MAIN FLOOR PLANS

CITY FILE NUMBER  
SHEET 2 OF 5  
CITY DRAWING NUMBER