



1 SBR, BLOWER BLDG & EXHAUST BLDG - PLUMBING PLAN
M1.01 SCALE 1:100

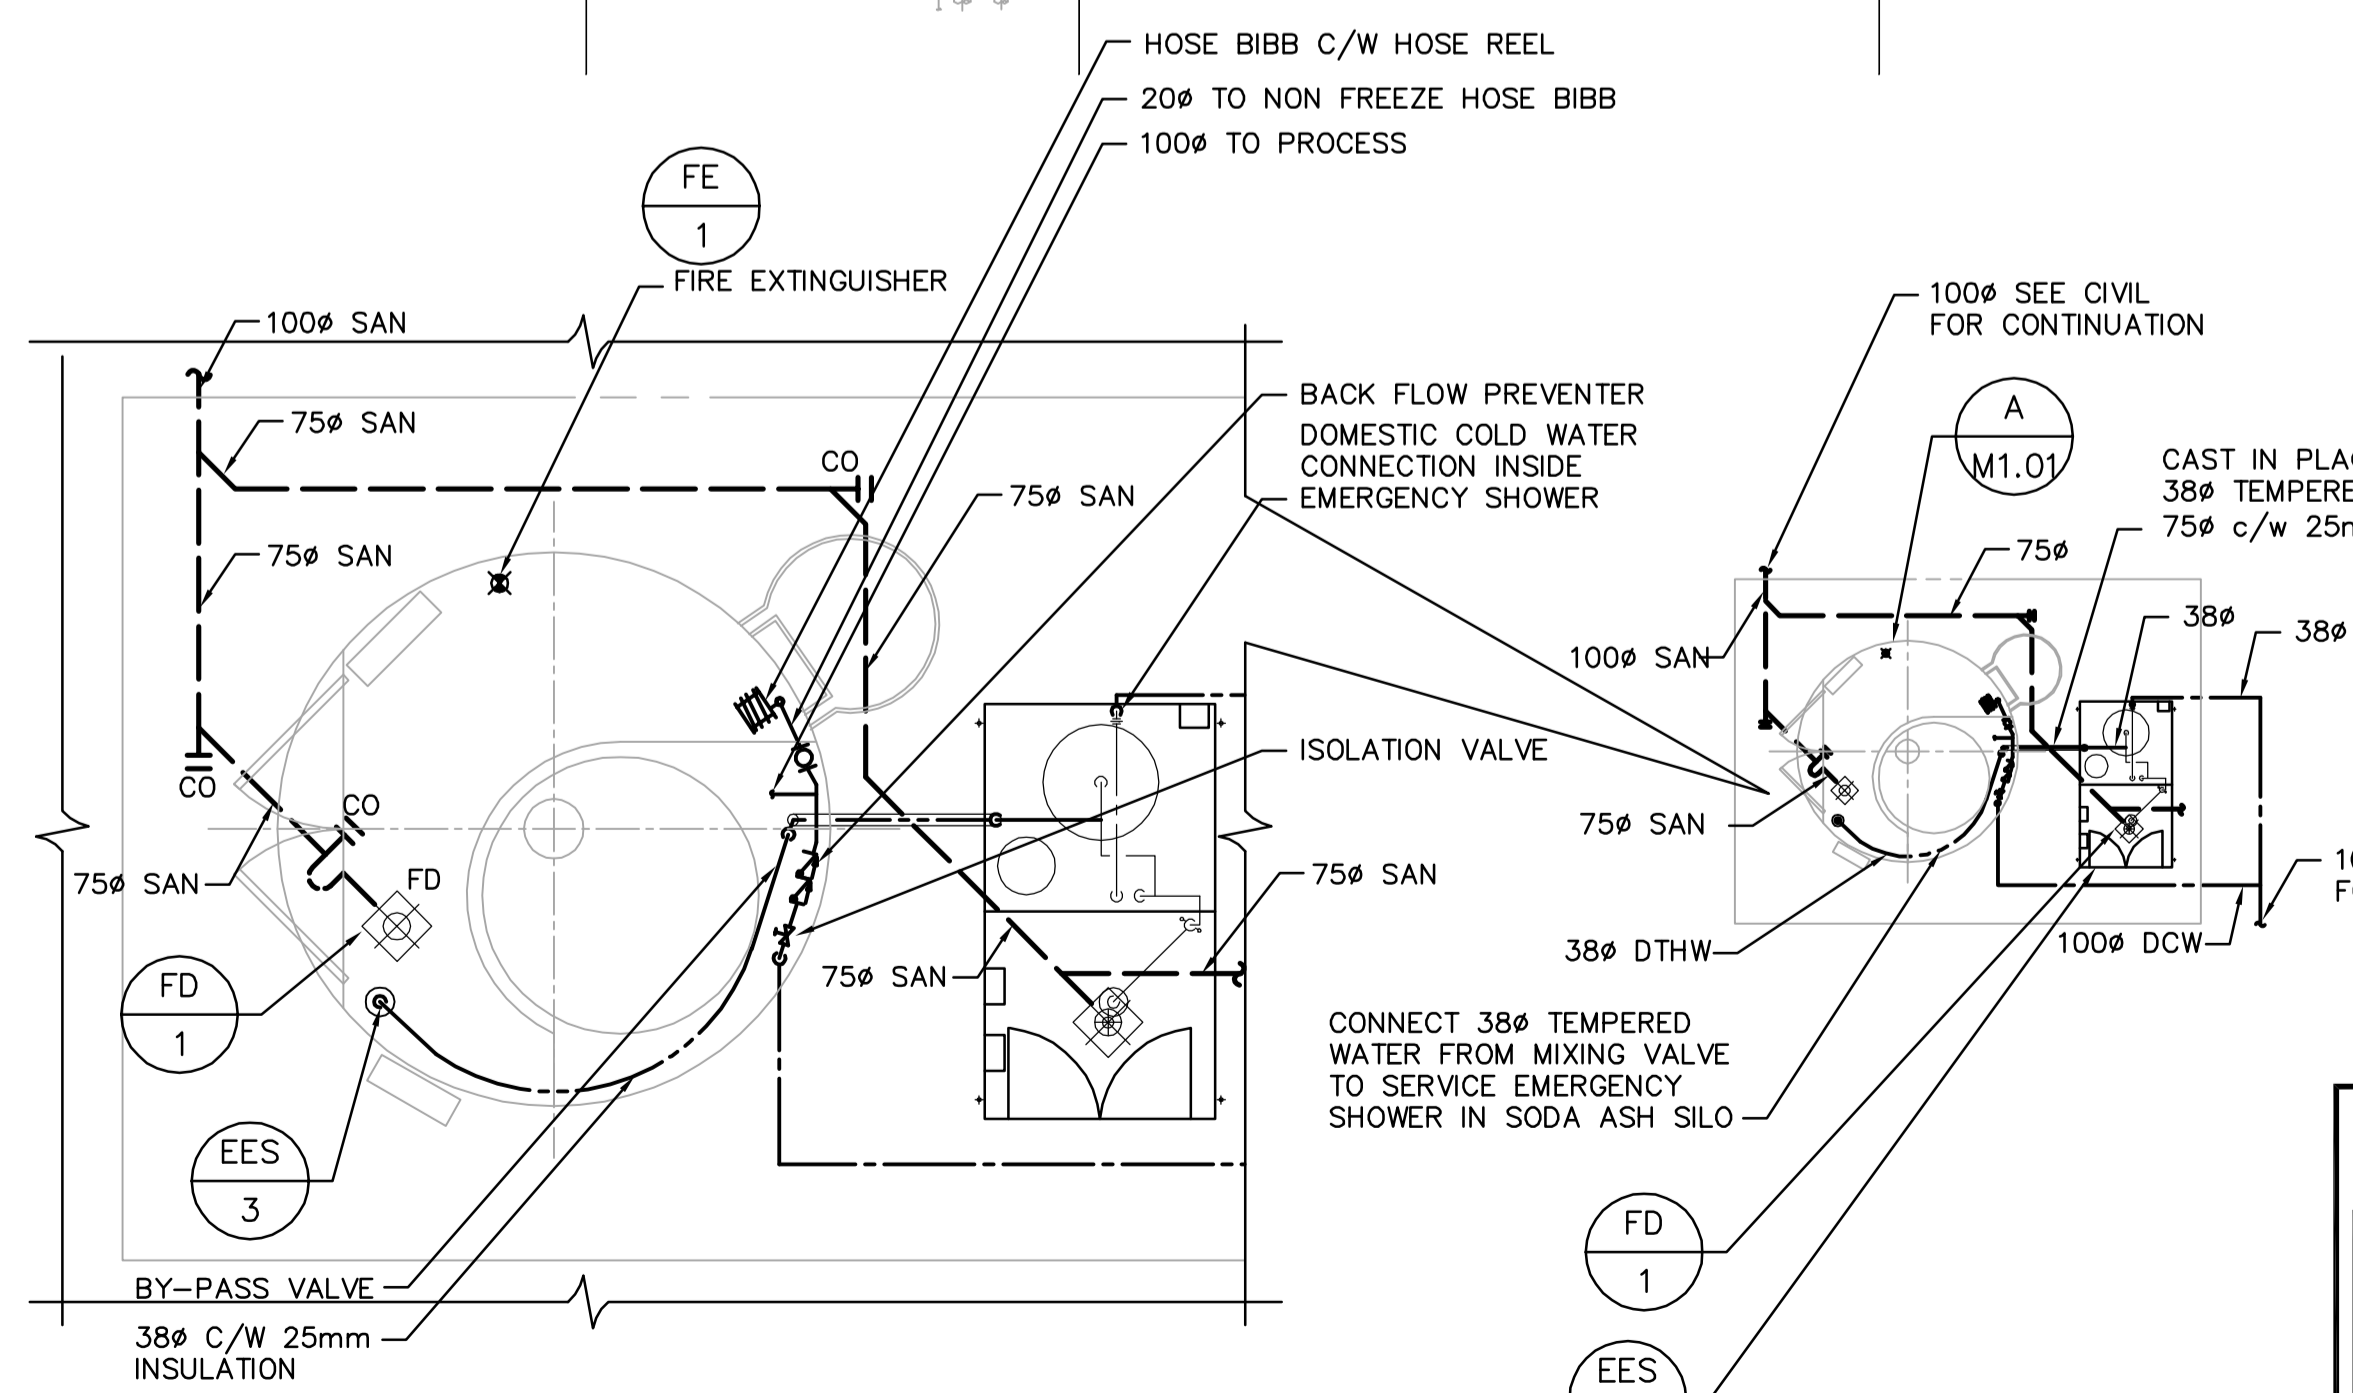

A SODA ASH DETAIL
M1.01 SCALE 1:50

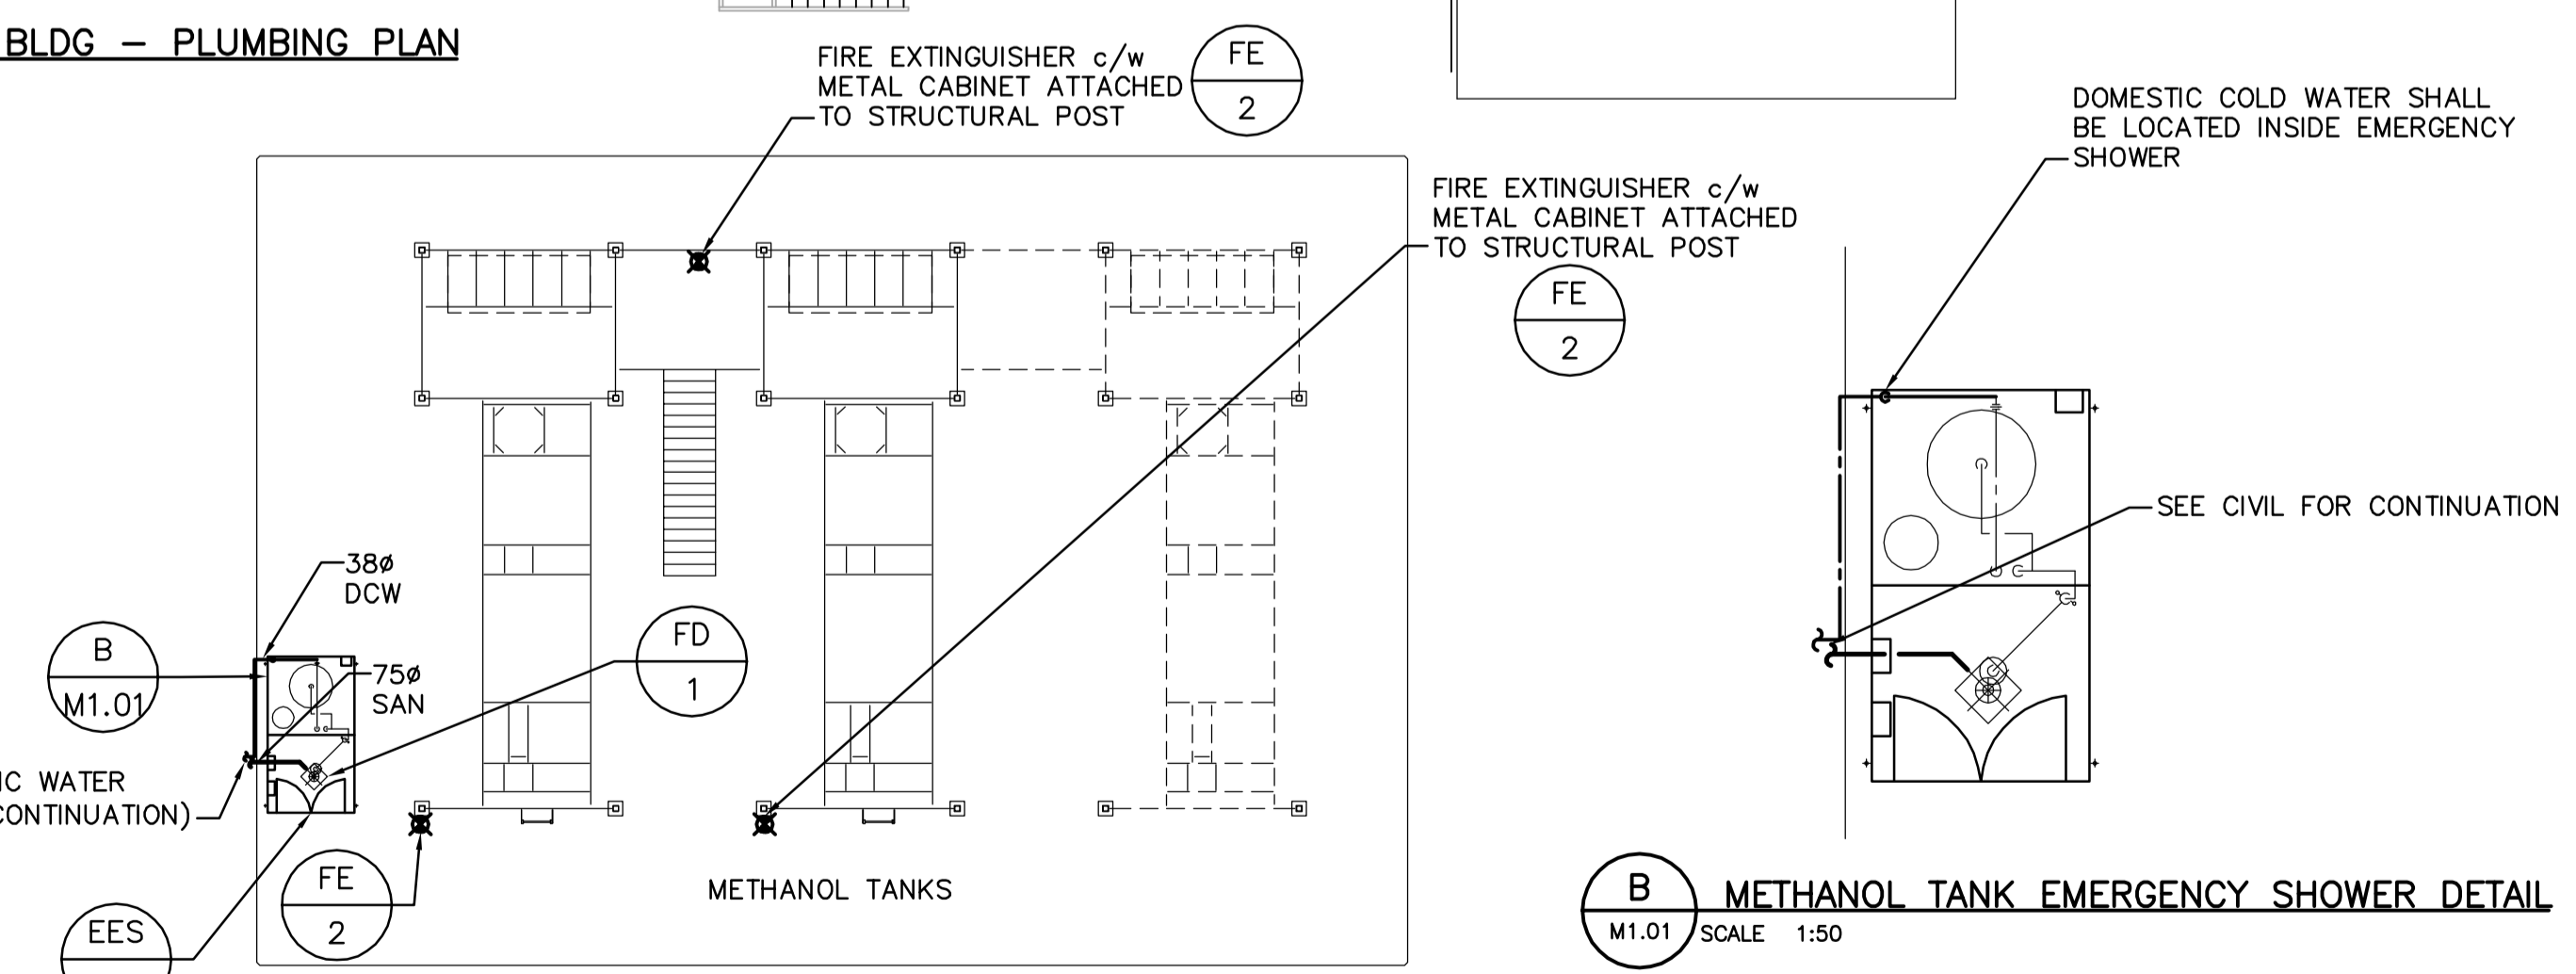

B METHANOL TANK EMERGENCY SHOWER DETAIL
M1.01 SCALE 1:50

<p>Certificate of Authorization Earth Tech Canada Inc. No. 730 Expiry: April 30, 2007</p>	B.M. ELEV.	<p>A Tyco International Ltd. Company</p>	ENGINEER'S SEAL	<p>THE CITY OF WINNIPEG WATER AND WASTE DEPARTMENT ENGINEERING DIVISION</p>	
			DESIGNED BY AB		ORIGINAL SIGNED BY A. BURACHYNSKY
			DRAWN BY DJP		APPROVED BY JEH
			SCALE: AS NOTED		RELEASED FOR CONSTRUCTION BY: K. MARTENS
	NO. REVISIONS	DATE	DATE	CONSULTANT DRAWING NO. M1.01	
			DATE 2006/05/15	DATE 2006/05/23	
				CITY FILE NUMBER	
				SHEET OF	
				CITY DRAWING NUMBER	