


2 MAIN FLOOR PLAN
WG-B0100 1:100

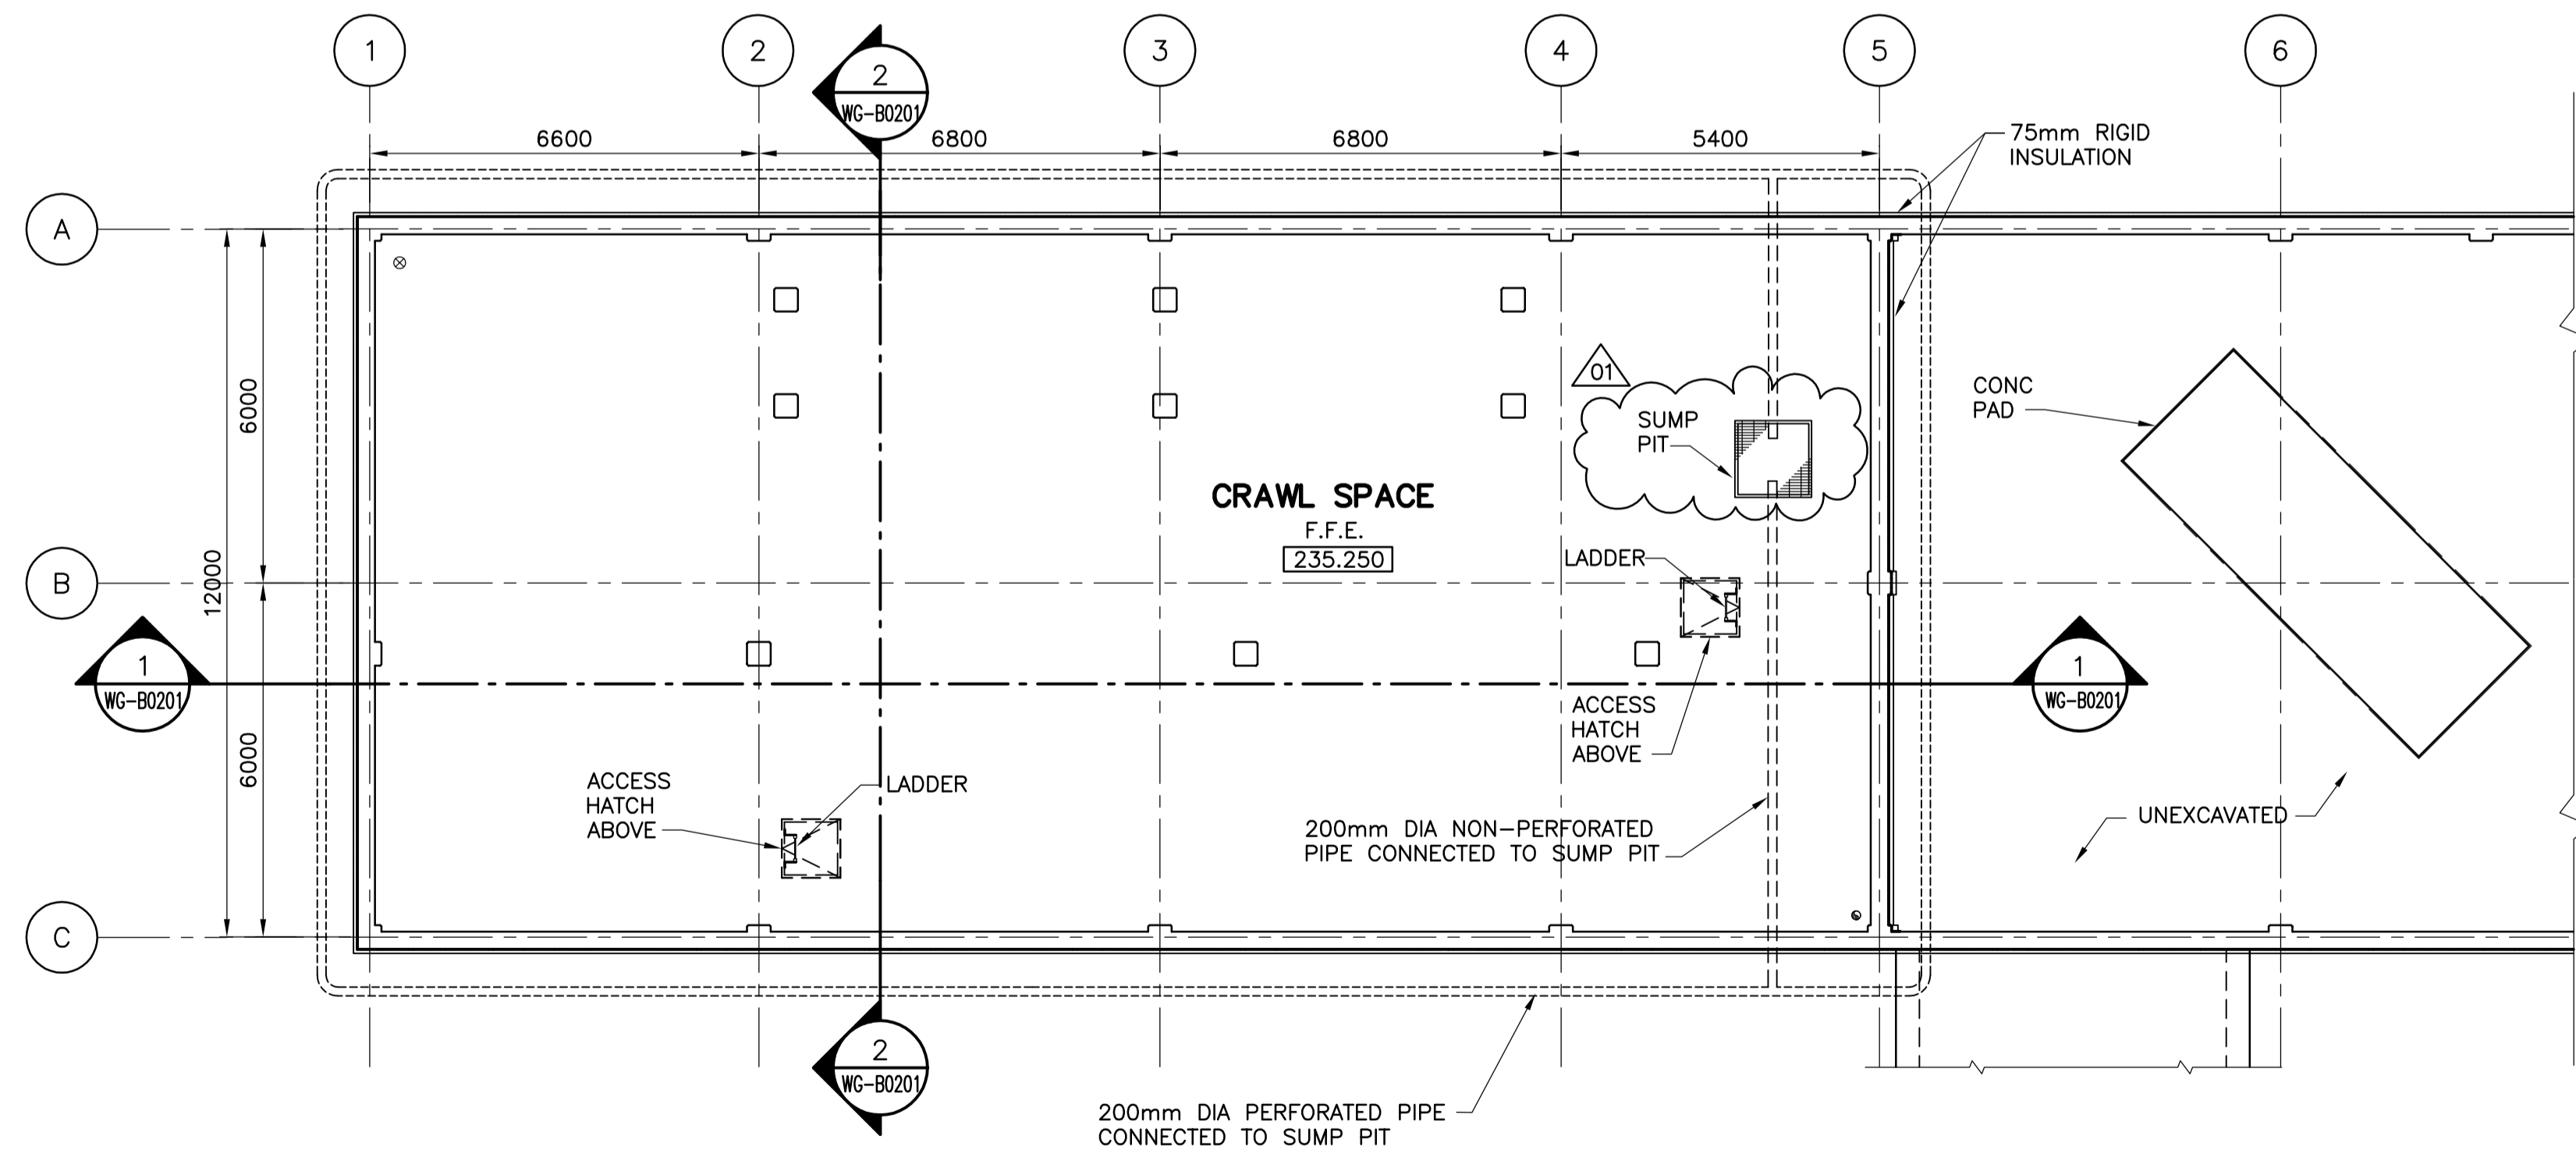

1 CRAWL SPACE FLOOR PLAN
WG-B0100 1:100

B.M. ELEV.		 		ENGINEER'S SEAL		 THE CITY OF WINNIPEG WATER AND WASTE DEPARTMENT ENGINEERING DIVISION	
		Frederickson Cooper ARCHITECTS		ORIGINAL SIGNED BY N. COOPER 2006/08/30		WATER TREATMENT PLANT STANDBY POWER GENERATOR	
		DESIGNED BY: NC CHECKED BY: LK DRAWN BY: AL APPROVED BY: AHL		CONSULTANT DRAWING NO. WG-B0100		CITY FILE NUMBER SHEET OF	
		SCALE: AS SHOWN RELEASED FOR CONSTRUCTION BY: R. SOROKOWSKI				CITY DRAWING NUMBER 1-0601G-A-B0100-001-0D	
NO. REVISIONS 01 498-2006 ADDENDUM 3 06/09/28 AL 00 ISSUED FOR TENDER 06/08/28 AL		DATE BY DATE 2006/06/01					