




1 CRAWLSPACE PLUMBING PLAN
WG-H0100 1:100

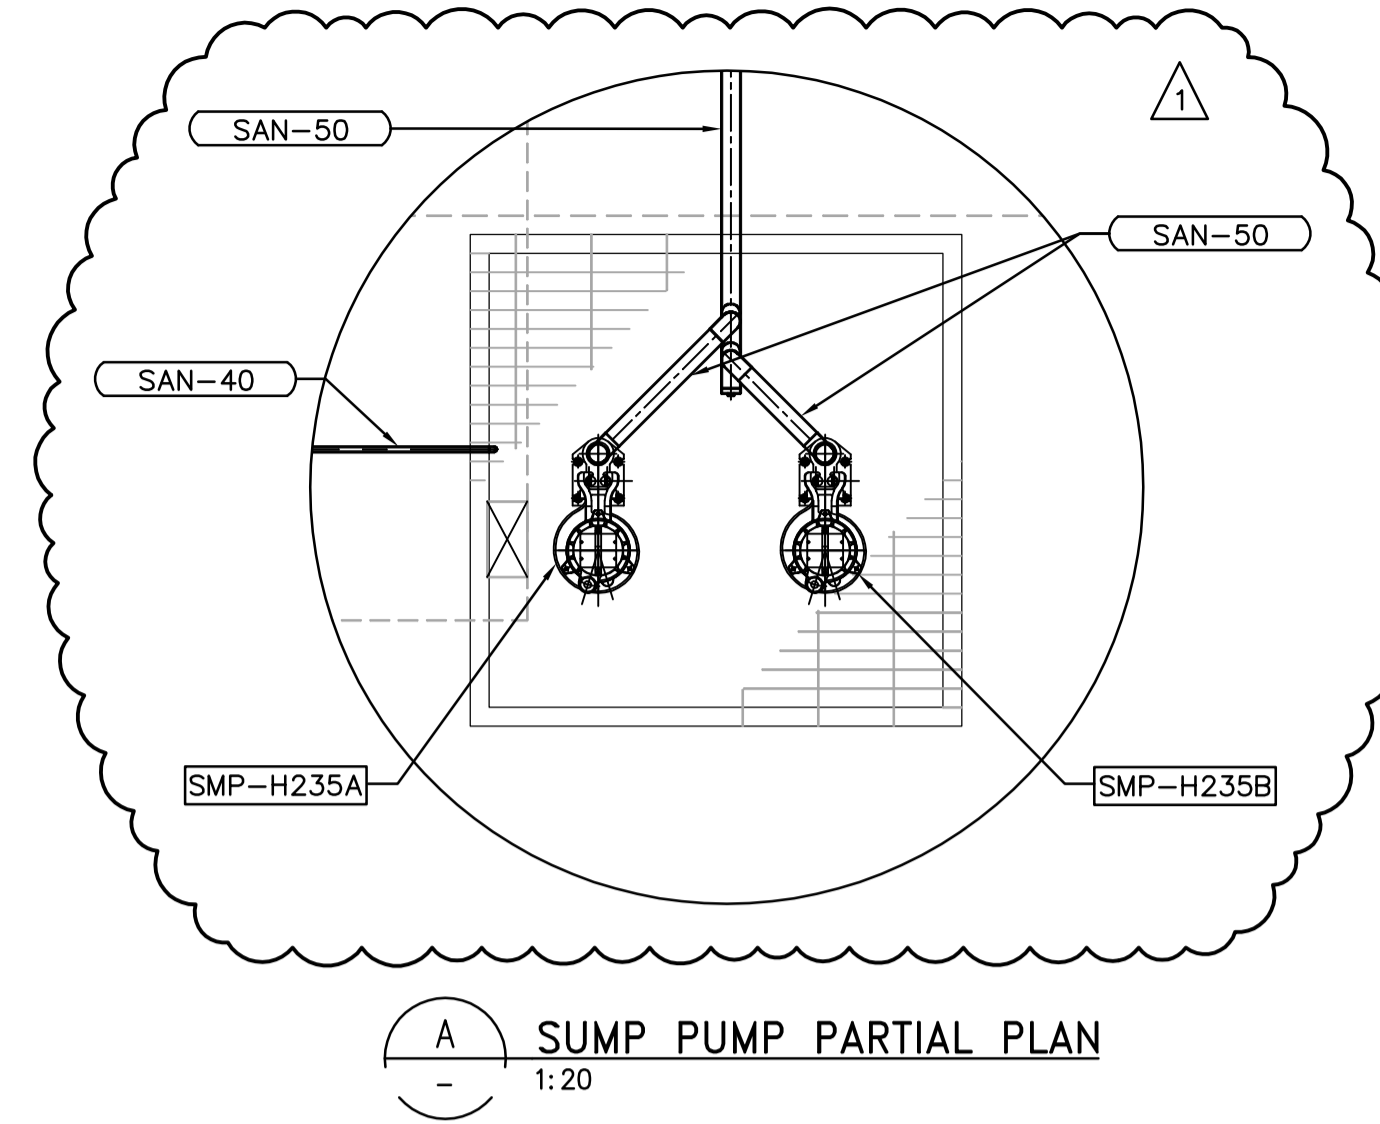

A SUMP PUMP PARTIAL PLAN
1:20

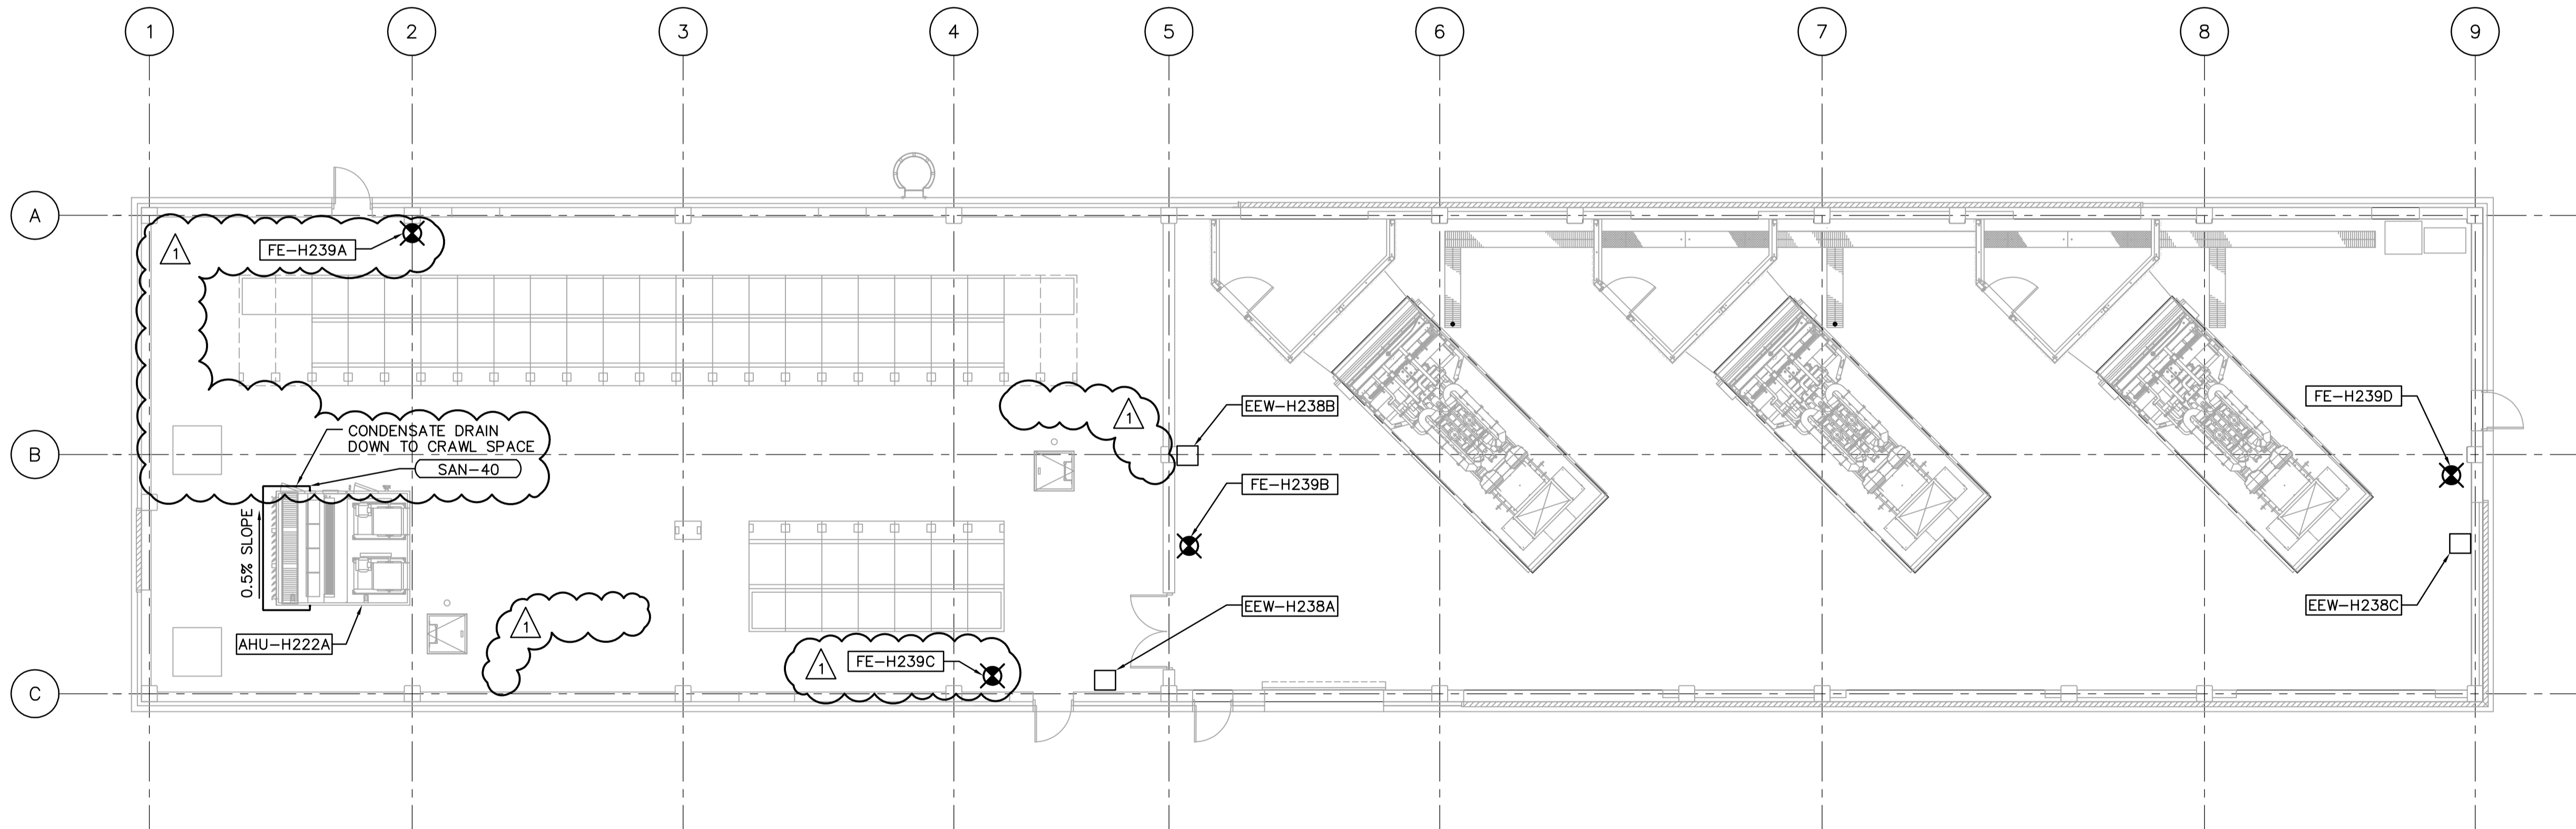

2 MAIN FLOOR FIRE PROTECTION PLAN
1:100

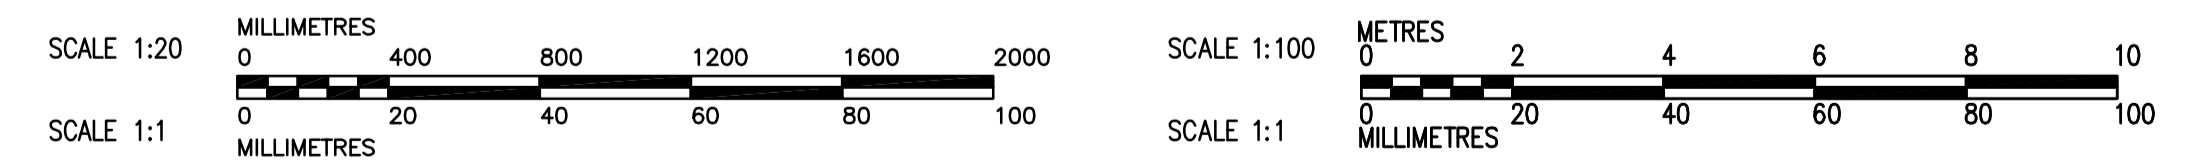

B.M. ELEV.		 Frederickson Cooper ARCHITECTS		 A Tyco International Ltd. Company		ENGINEER'S SEAL ORIGINAL SIGNED BY A. BURACHYNSKY 2006/08/30		 THE CITY OF WINNIPEG WATER AND WASTE DEPARTMENT ENGINEERING DIVISION	
DESIGNED BY	AB	CHECKED BY	AMA, PVL	SCALE: AS NOTED		CONSULTANT DRAWING NO. WG-H0100		CITY FILE NUMBER	
DRAWN BY	DJP	APPROVED BY	AHL	RELEASED FOR CONSTRUCTION BY: R. SOROKOWSKI		MECHANICAL PLUMBING PLAN CRAWLSPACE PLAN AND MAIN LEVEL PLAN		SHEET OF	
NO. REVISIONS	DATE	BY	DATE	DATE	DATE	CITY DRAWING NUMBER		1-0601G-A-H0100-001-01D	