



**INLET BUILDING MAIN FLOOR POWER PLAN**  
1:50

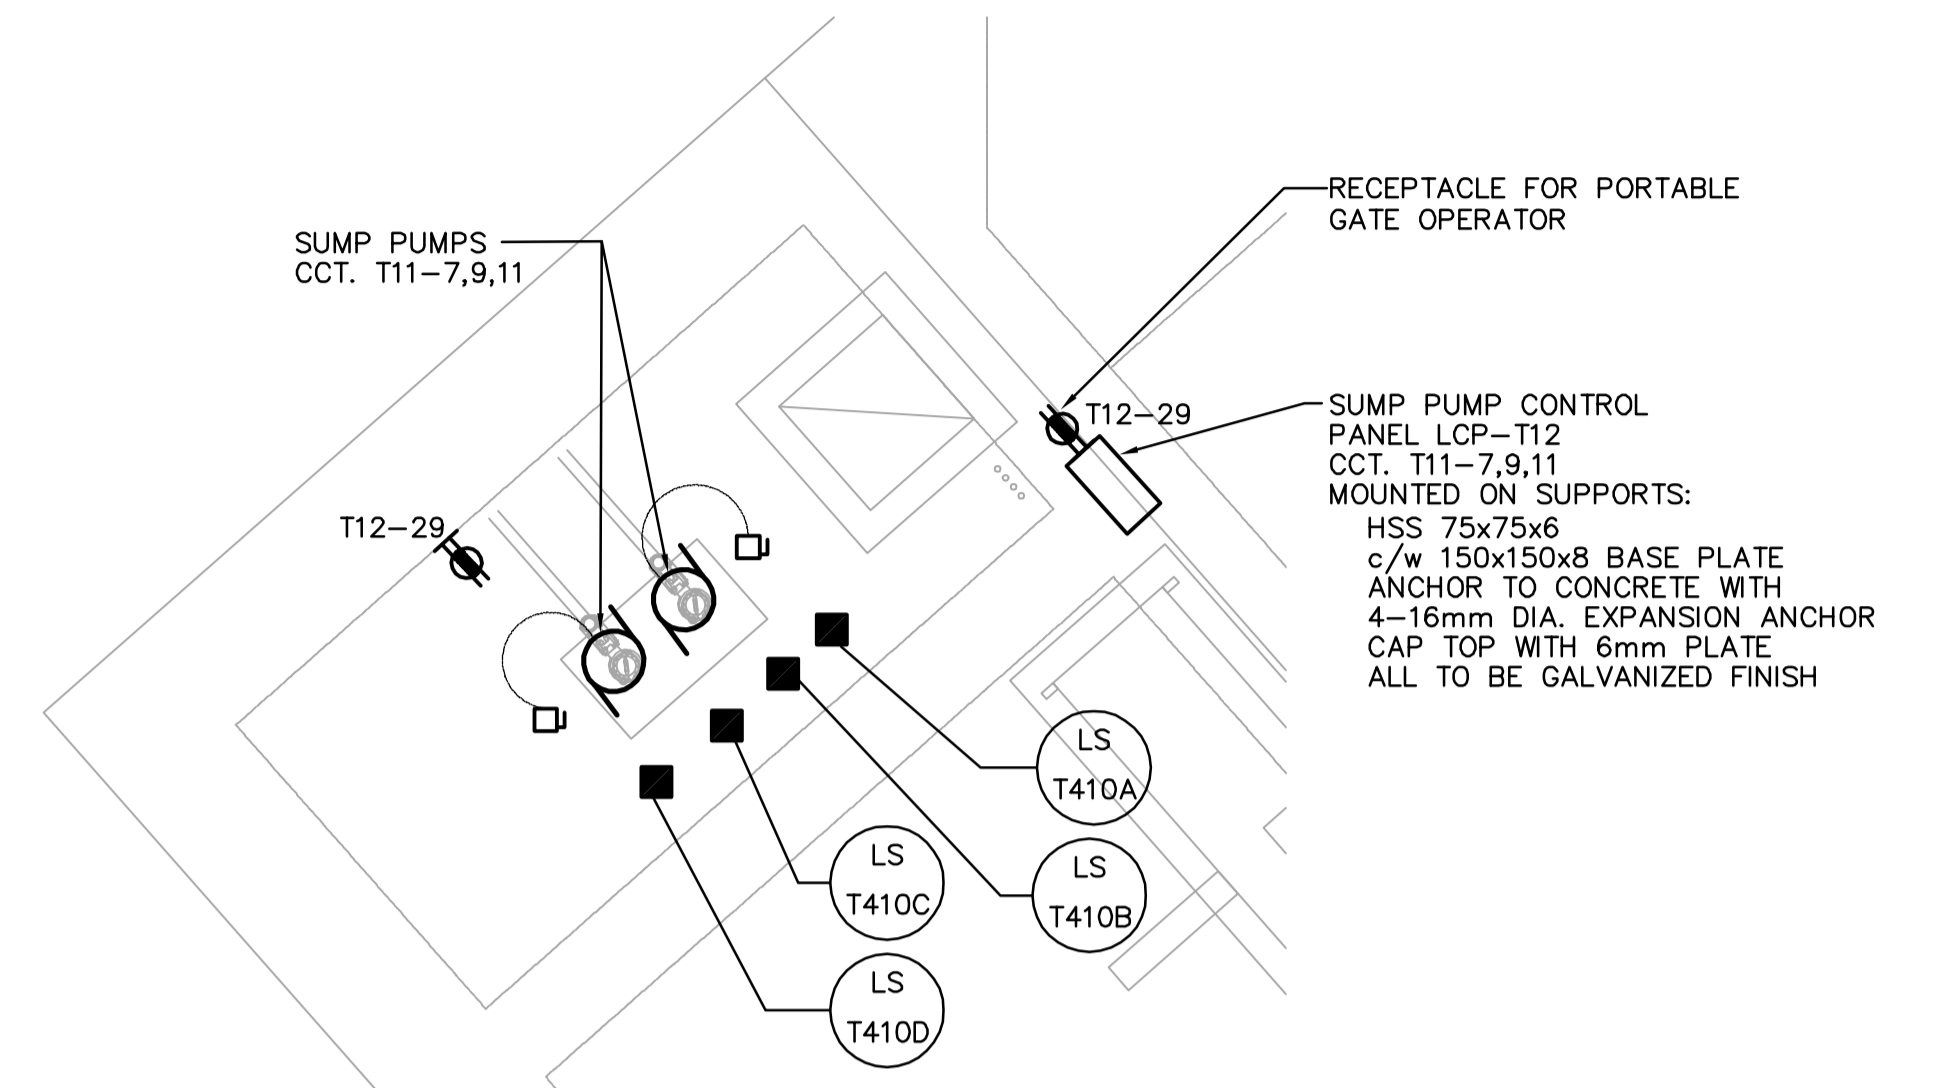

**SUMP PIT AREA POWER PLAN**  
1:50

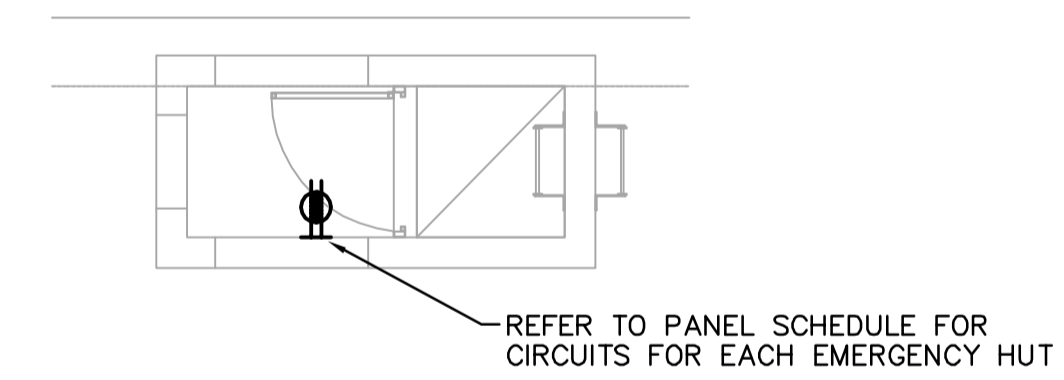

**EMERGENCY HUT POWER PLAN**  
1:50

**DRAWING NOTES**

- COORDINATE WORK WITH OTHER TRADES TO AVOID CONFLICTS.
- PROVIDE VERTICAL CABLETRAY OVER THE MONORAIL.

<p>Certificate of Authorization Earth Tech Canada Inc. No. 730 Expiry: April 30, 2007</p>	B.M. ELEV.	<p>Frederickson Cooper ARCHITECTS</p>	<p>A Tech International Ltd. Company</p>	ENGINEER'S SEAL	<p><b>THE CITY OF WINNIPEG</b> WATER AND WASTE DEPARTMENT ENGINEERING DIVISION</p>		
				DESIGNED BY BLM		CHECKED BY PS	ORIGINAL SIGNED BY B.L. MOORE
				DRAWN BY ERC		APPROVED BY AHL	2006/08/30
				SCALE: 1:50		RELEASED FOR CONSTRUCTION BY: R. SOROKOWSKI	CONSULTANT DRAWING NO. WT-E0112
	NO. REVISIONS	DATE	DATE	DATE	<p>WATER TREATMENT PLANT TREATED WATER STORAGE INLET BUILDING</p> <p>ELECTRICAL POWER AND FIRE ALARMS FLOOR PLANS</p>		
					<p>CITY FILE NUMBER</p> <p>SHEET OF</p> <p>CITY DRAWING NUMBER 1-0601T-A-E0112-001-02D</p>		