




INLET BUILDING MAIN FLOOR POWER PLAN
1:50

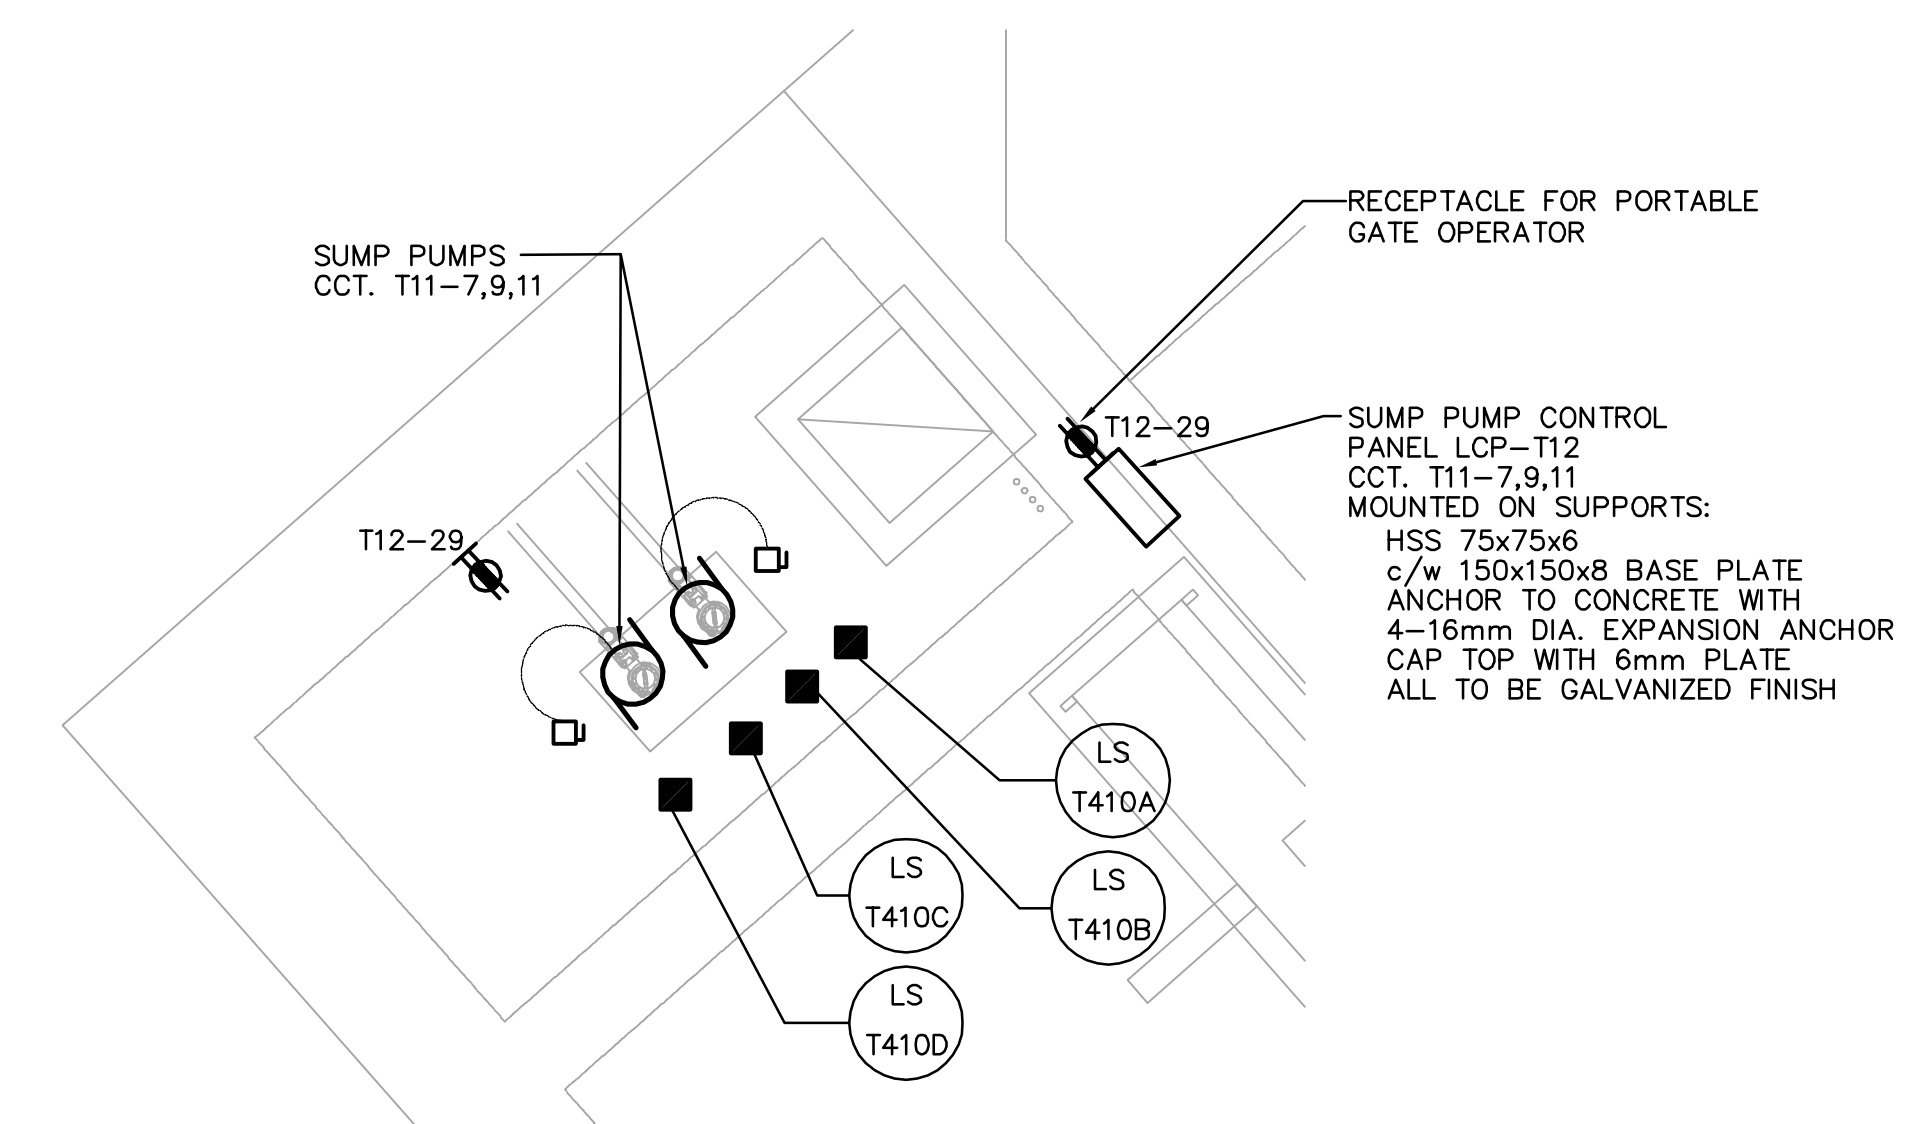

SUMP PIT AREA POWER PLAN
1:50

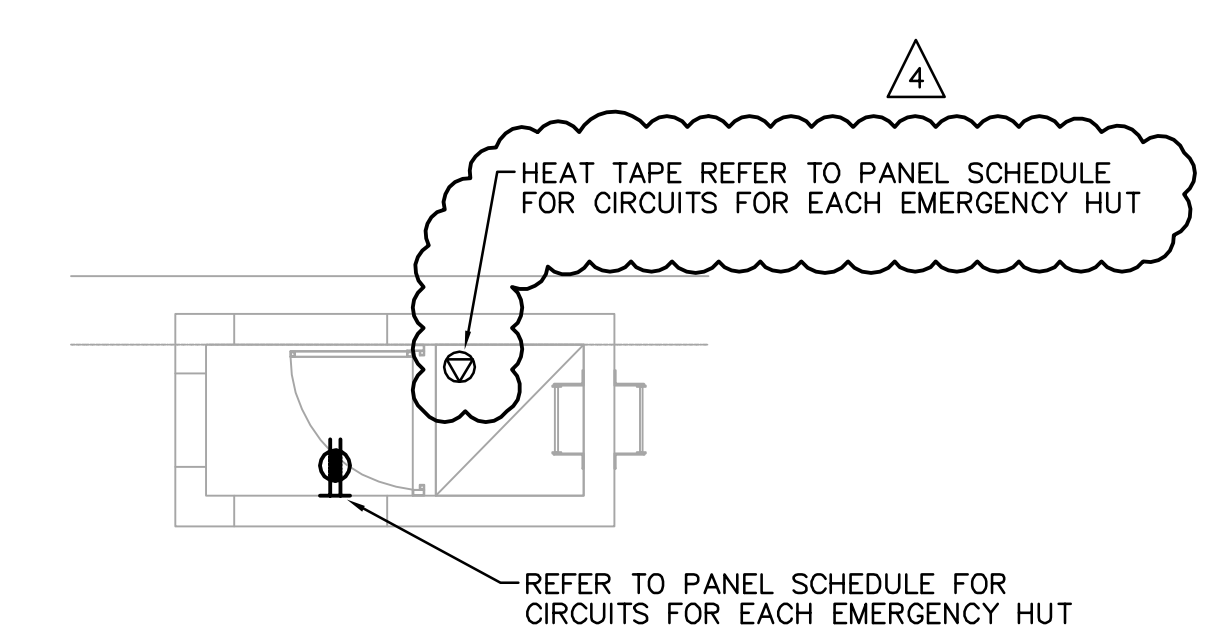

EMERGENCY HUT POWER PLAN
1:50

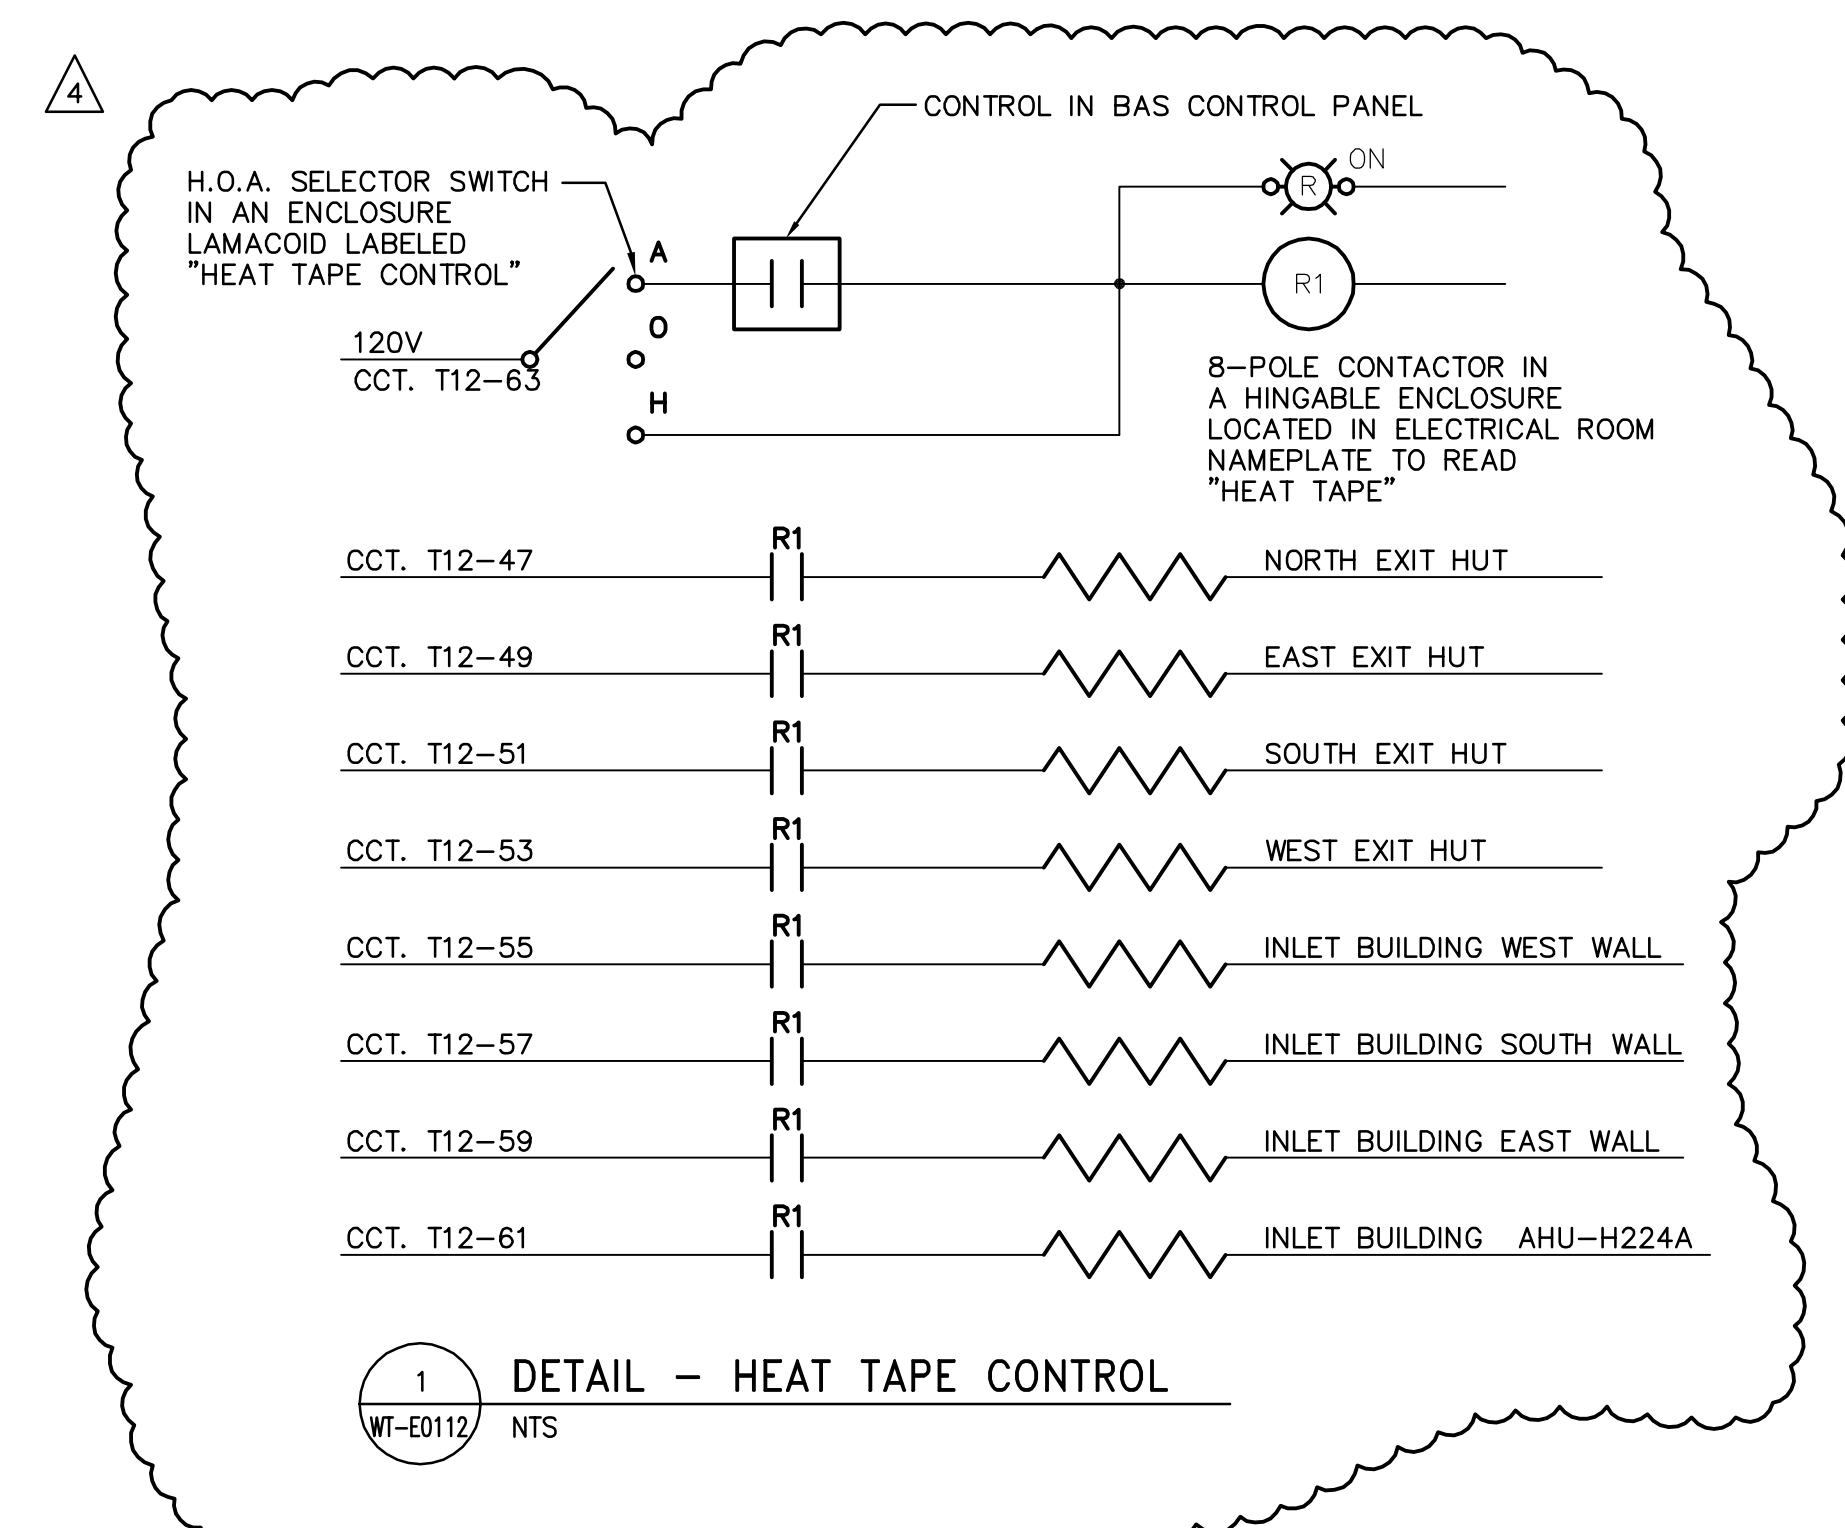

1 **DETAIL - HEAT TAPE CONTROL**
WT-E0112 NTS

DRAWING NOTES

- 1. COORDINATE WORK WITH OTHER TRADES TO AVOID CONFLICTS.
- 2. PROVIDE VERTICAL CABLETRAY OVER THE MONORAIL.

<p>APECM Certificate of Authorization Earth Tech Canada Inc. No. 730 Expiry: April 30, 2007</p>	B.M. ELEV.	<p>CH2M HILL Frederickson Cooper ARCHITECTS</p>	<p>EarthTech A Tyco International Ltd. Company</p>	ENGINEER'S SEAL	<p>THE CITY OF WINNIPEG WATER AND WASTE DEPARTMENT ENGINEERING DIVISION</p>	CITY FILE NUMBER	
				DESIGNED BY BLM		CHECKED BY PS	ORIGINAL SIGNED BY B.L. MOORE
		DRAWN BY ERC	APPROVED BY AHL	2006/08/30		WATER TREATMENT PLANT TREATED WATER STORAGE INLET BUILDING	CITY DRAWING NUMBER
		SCALE: 1:50	RELEASED FOR CONSTRUCTION BY: R. SOROKOWSKI	CONSULTANT DRAWING NO. WT-E0112		ELECTRICAL POWER AND FIRE ALARMS FLOOR PLANS	1-0601T-A-E0112-001-04D
	NO. REVISIONS	DATE	DATE	DATE			