


- GENERAL NOTES:**
1. PERFORM WORK IN ACCORDANCE WITH ALL APPLICABLE CODES AND REGULATIONS.
  2. REVIEW EQUIPMENT LOCATIONS WITH CONTRACT ADMINISTRATOR PRIOR TO INSTALLATION.
  3. PIPE ROUTING INDICATED ON DRAWINGS ARE APPROXIMATE ONLY. CONFIRM IN FIELD. REROUTE PIPING TO ELIMINATE FIELD INTERFERENCES WITH BUILDING STRUCTURES, ELECTRICAL ETC. CONFIRM CHANGES WITH CONTRACT ADMINISTRATOR.
  4. FIRE SEAL ALL PIPE PENETRATIONS TO MAINTAIN EXISTING FIRE SEPARATIONS.
  5. REFER TO PIPING SCHEMATICS FOR DETAILS.
  6. PROVIDE ACCESS DOORS FOR ALL EQUIPMENT AND DAMPERS LOCATED ABOVE DRYWALL CEILINGS.
  7. PIPING TO CABINET UNIT HEATERS CAN BE SURFACE MOUNT. PIPING TO BE PROTECTED USING BENT PLATE SHROUD AS INDICATED IN STRUCTURAL DRAWINGS.

- KEY NOTES:**
1. INSTALL NEW PIPING AS INDICATED. CONFIRM PIPE ROUTING IN FIELD.
  2. RUN SUPPLY AND RETURN PIPING UP TO MEZZANINE LEVEL (TYP).

- LEGEND:**
- NEW EQUIPMENT OR PIPING
  - - - EXISTING EQUIPMENT/DUCTWORK/PIPING
  - RHC RE-HEAT COIL
  - GS GLYCOL SUPPLY
  - GR GLYCOL RETURN
  - CUH CABINET UNIT HEATER

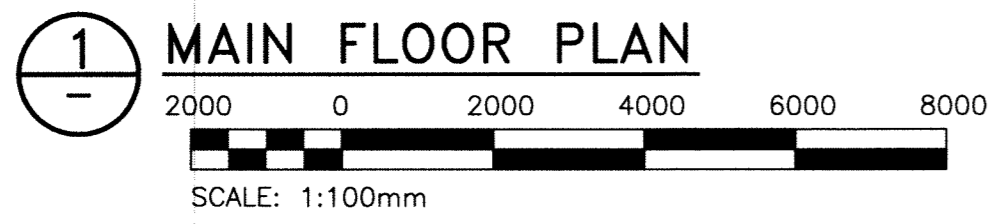

KGS FILE NO.: P:\PROJECTS\2011\11-0107-02\DWG\MECH\11-0107-02\_M3.dwg



B.M.	
ELEV.	
DESIGNED BY	PSS
CHECKED BY	RED
DRAWN BY	VJH
APPROVED BY	
1	RE-ISSUED FOR TENDER 12/04/23
0	ISSUED FOR TENDER 12/04/11
NO.	REVISIONS
	DATE
	BY
	DATE

**KGS GROUP**  
 CONSULTING ENGINEERS & PROJECT MANAGERS  
 WINNIPEG (204) 896-1209  
 THUNDER BAY (807) 345-2233

DESIGNED BY: PSS  
 CHECKED BY: RED  
 DRAWN BY: VJH  
 APPROVED BY: [Signature]  
 HOR. SCALE: AS SHOWN  
 VERTICAL: .  
 RELEASED FOR CONSTRUCTION: [Signature]  
 DATE: .

ENGINEER'S SEAL  
  
 CONSULTANT DRAWING NO.  
**P2-M03**

**THE CITY OF WINNIPEG**  
 PUBLIC WORKS DEPARTMENT

PROJECT TITLE  
**FORT ROUGE LEISURE CENTRE  
 HVAC UPGRADE - PHASE 2**

SHEET OF  
**001 001**

COMPUTER FILE NAME  
**11-0107-02-P2-M03**

CITY DRAWING NUMBER

**MAIN FLOOR PLAN  
 NEW PIPING**