


FURNITURE LEGEND

- ITEM 1 IST TYPICAL WORKSTATION
- ITEM 2 TYPICAL PRIVATE OFFICE PLAN
- ITEM 3 SWS MANAGER'S DESK (#3)
- ITEM 4 IST MANAGER'S DESKS (#1&8)
- ITEM 5 SWS "CLOSED" WORKSTATION
- ITEM 6 SWS CLERKS WORKSTATION
- ITEM 7 SWS "OPEN" WORKSTATIONS
- ITEM 8 SWS FIELD STAFF WORKSTATIONS
- ITEM 9 SWS FIELD STAFF "HOTELLING" DESKS
- ITEM 10 SWS STUDENT DESKS
- ITEM 11 IST WORKROOM DESKS
- ITEM 12 IST CONSULTANT DESKS
- ITEM 13 MANUAL STORAGE SHELVES
- ITEM 14 TALL STORAGE CABINET-- (PART OF IST WORKROOM DESK COMPONENTS)
- ITEM 15 3 DRAWER LATERAL FILES
- ITEM 16 SUPPLY CABINETS
- ITEM 17 END TAB FILING SHELVING
- ITEM 18 OPEN STORAGE SHELVING
- ITEM 19 FILE BOX STORAGE SHELVES
- ITEM 20 CUSTOM MAP STORAGE UNIT
- ITEM 21 MEETING ROOM TABLE-- n.i.c
- ITEM 22 IST MEETING ROOM TABLE
- ITEM 23 BOARDROOM TABLES
- ITEM 24 MEDIASCAPE STOOL HEIGHT TABLE
- ITEM 25 STOOL HEIGHT TABLES
- ITEM 26 LUNCH ROOM TABLES
- ITEM 27 COFFEE TABLE
- ITEM 28 STOOL HEIGHT COUNTERS OVER FILE CABINETS
- ITEM 29 PRIVATE OFFICE ROUND MEETING TABLES
- ITEM 30 STOOLS
- ITEM 31 LUNCH ROOM/BOARDROOM STACKING CHAIRS
- ITEM 32 LOUNGE SEATING
- ITEM 33 ARMLESS TABLET CHAIRS
- ITEM 34 OTTOMAN
- ITEM 35 NOT USED
- ITEM 36 IST TASK CHAIRS
- ITEM 37 SWS TASK CHAIRS
- ITEM 38 CONSULTANT/ MEETING ROOM CHAIRS
- ITEM 39 MEETING TABLE STOOL TASK CHAIRS
- ITEM 40 PRIVATE OFFICE GUEST CHAIRS
- ITEM 41 IST MANAGER WHITEBOARD 48"x76"
- ITEM 42 IST OFFICE WHITEBOARDS 48"x60"
- ITEM 43 WHITEBOARD 48"x96"
- ITEM 44 MOBILE WHITEBOARD
- ITEM 45 FULL HEIGHT WALL MOUNTED WHITEBOARDS
- ITEM 46 TACKBOARD
- ITEM 47 PODIUM/ LECTURN
- ITEM 48 MEETING ROOM CONSOLE
- ITEM 49 RECEPTION DESK WORKSTATION
- ITEM 50 COUNTERTOP OVER FILE CABINETS

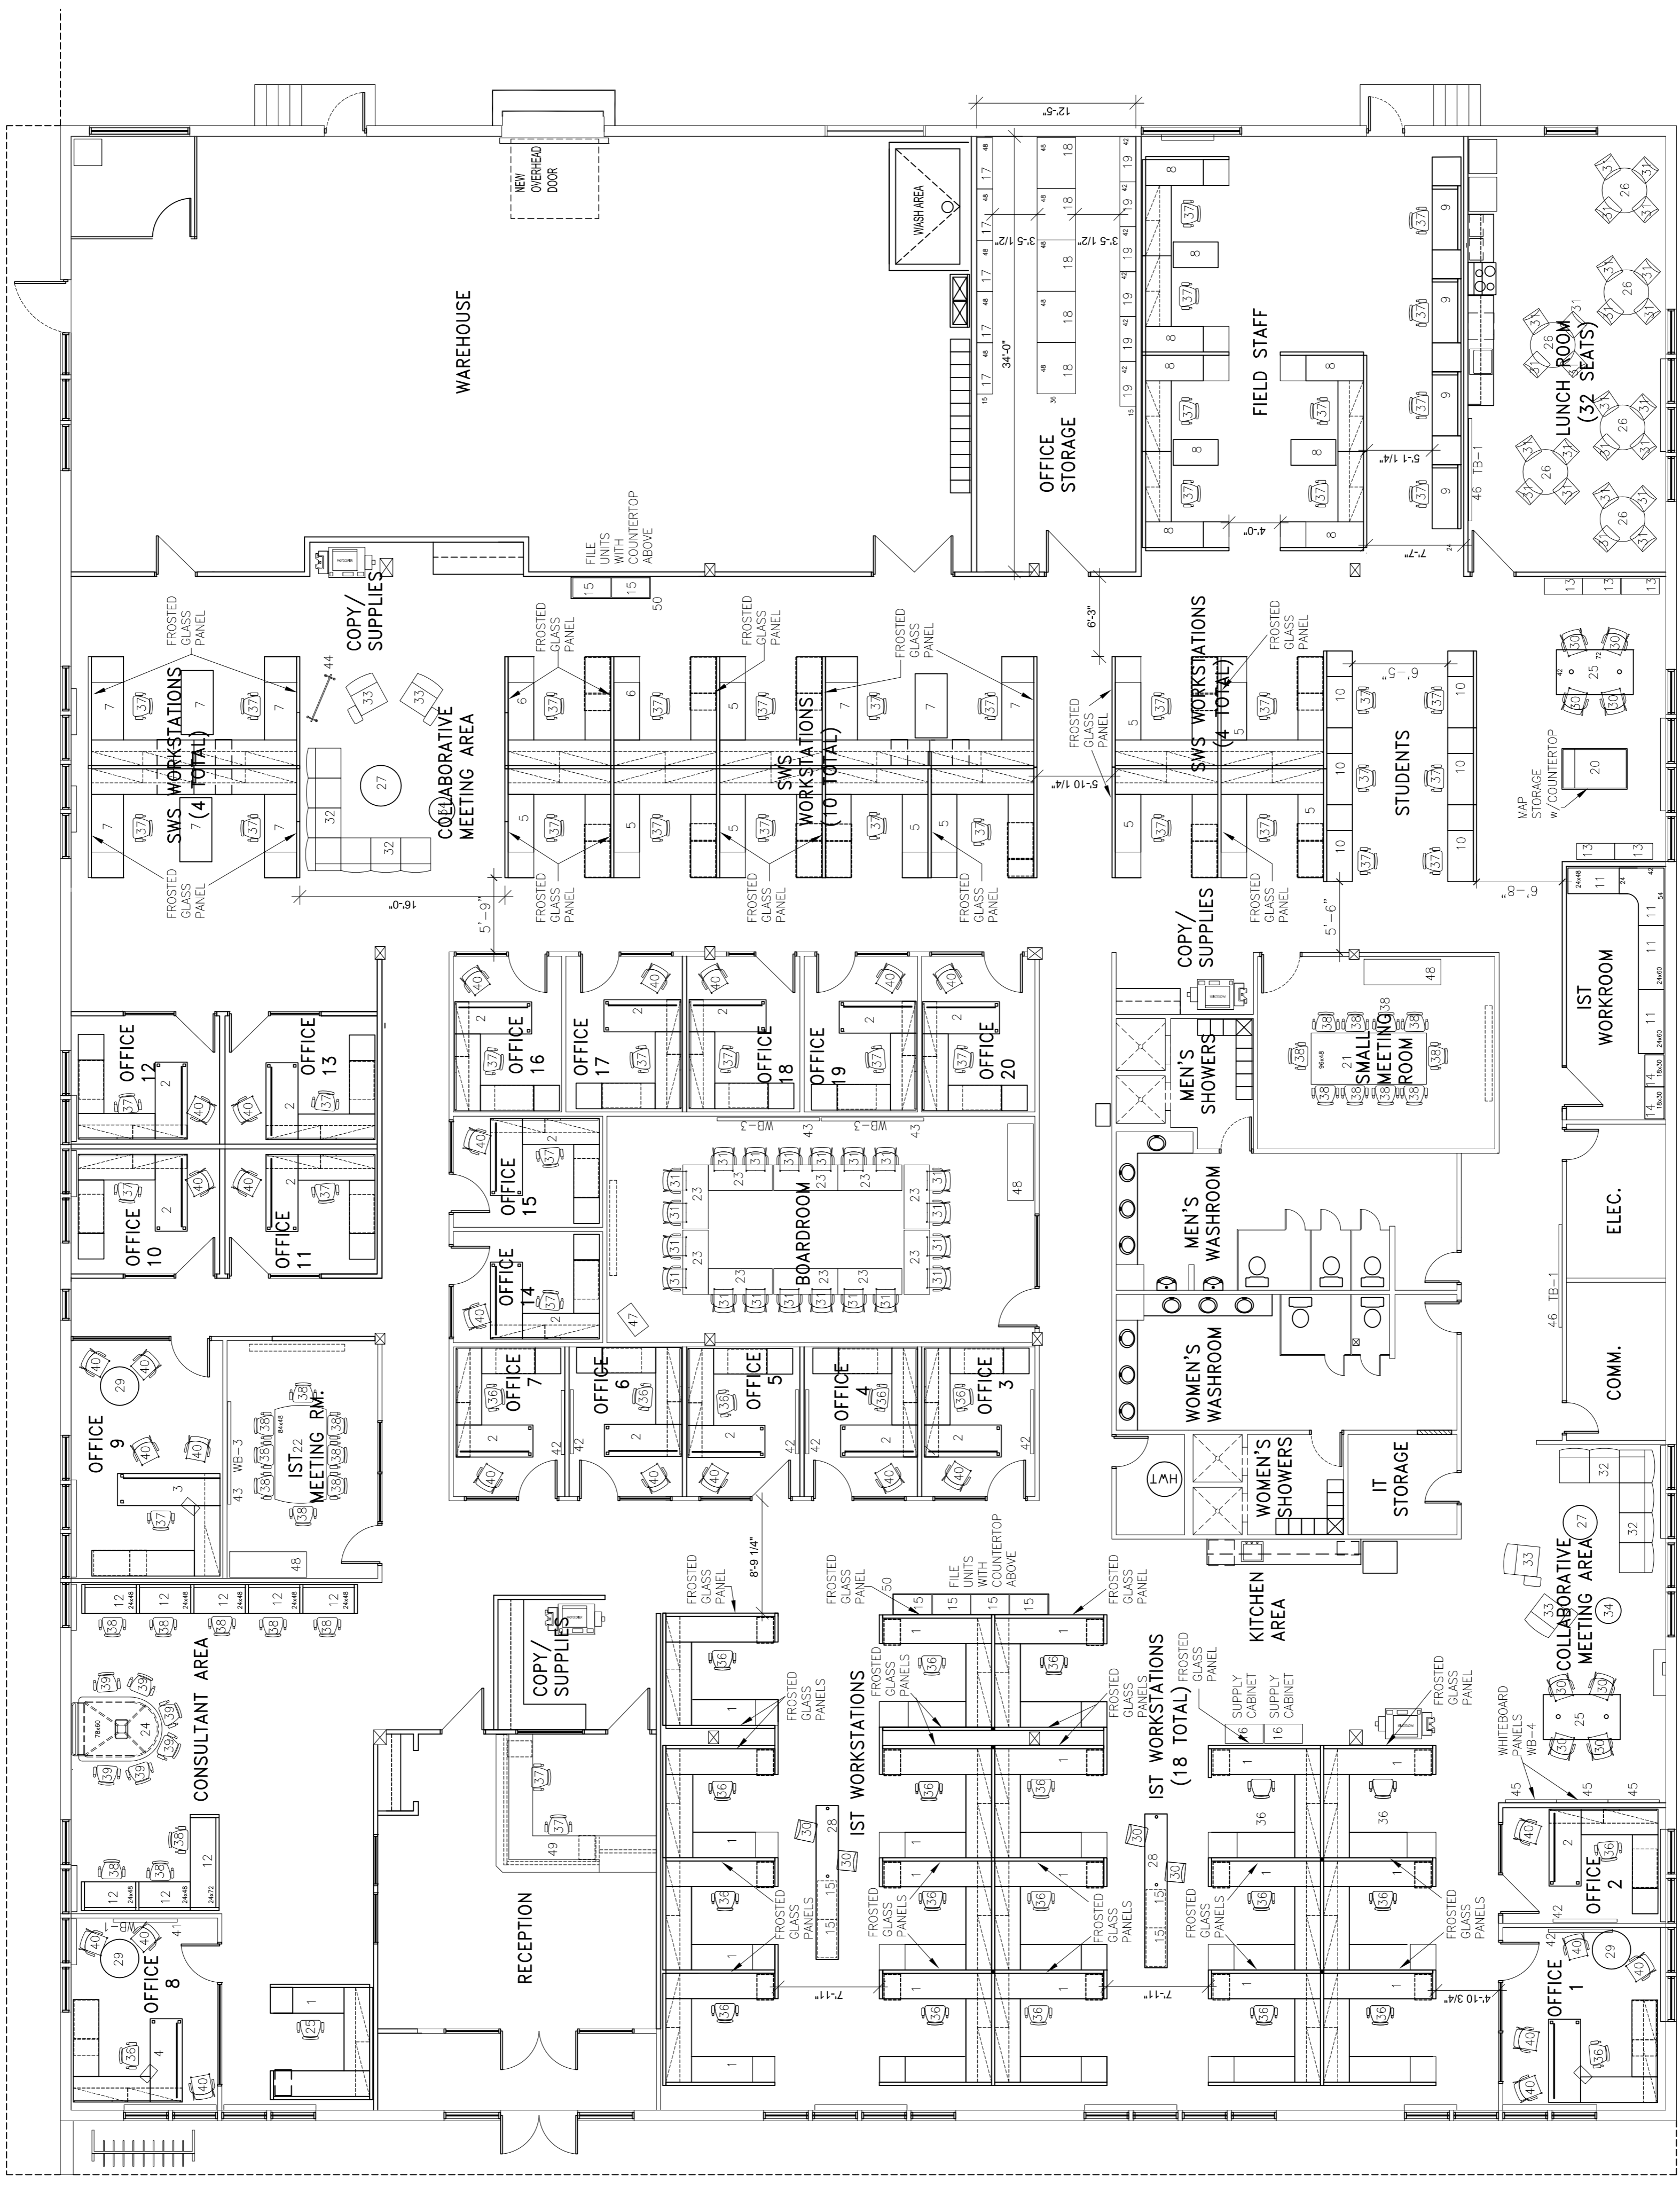

MAIN FLOOR PLAN - FURNITURE PLAN
SCALE: 1/8"=1'-0"

NOTES:
THESE DRAWINGS SHALL NOT BE SCALED.
THE CONTRACTOR SHALL VISIT THE SITE AND SATISFY HIMSELF ALL DIMENSIONS, DATUM, AND DETAILED INFORMATION SHOWN ARE CORRECT.
THE CONTRACTOR IS TO REVIEW AND COORDINATE ALL ARCHITECTURAL, MECHANICAL, ELECTRICAL AND STRUCTURAL DRAWINGS FOR ADDITIONAL OPENINGS THROUGH FLOORS, WALLS, AND CEILINGS FOR DUCT, PIPE & ELECTRICAL RISERS AND ALL OPENINGS NOT SHOWN ON DRAWINGS.
ALL OPENINGS THROUGH FIRE ASSEMBLIES ARE TO BE FIRE STOPPED AND SEALED WITH ILC APPROVED FIRE STOPPING TO MAINTAIN THE INTEGRITY OF THE FIRE SEPARATION, AND PROVIDE A SMOKE-TIGHT BARRIER.
ALL PRODUCTS AND MATERIALS TO BE USED AND INSTALLED SHALL CONFORM WITH MANUFACTURER'S SPECIFICATIONS & APPLICABLE CODES.
THE CONTRACTOR SHALL BE RESPONSIBLE TO PATCH AND MAKE GOOD ALL EXISTING CONSTRUCTION DAMAGED BY THE REMOVAL OF ALL ITEMS FORMING THE PART OF THE RESTORATION WORK.
WHERE NEW FLOORING AND BASE IS TO BE INSTALLED IN EXISTING AREAS REFER TO FLOOR PLAN AND ROOM SCHEDULE. THE EXISTING FLOORING SURFACE AND BASE MUST BE REMOVED UNLESS OTHERWISE NOTED. ALL FLOOR SURFACES SHALL BE PREPARED IN ACCORDANCE TO MANUFACTURER'S RECOMMENDATIONS FOR INSTALLATION OF NEW FLOOR.
WHERE PAINTING OF EXISTING WALLS IS INDICATED ON THE ROOM SCHEDULE, THESE WALLS ARE TO BE CLEANED OF ALL EXISTING FINISH COVERING, PATCHED & PREPARED TO ACCEPT NEW MATERIAL UNLESS OTHERWISE NOTED.

No.	REVISION/DESCRIPTION	BY	DATE	DESIGNED	IN	APPROVED
				CHECKED	IN	APPROVED
SEALED				DATE	2012/04/06	

THE CITY OF WINNIPEG
 PLANNING, PROPERTY AND DEVELOPMENT DEPARTMENT
 MUNICIPAL ACCOMMODATIONS DIVISION
 3-65 GARRY STREET, R3C 4K4

PROJECT
 1120 WAVERLY STREET
 SOLID WASTE/IST RELOCATION

1120 WAVERLY STREET
SHEET TITLE

OVERALL FURNITURE PLAN

SCALE	1/8"=1'-0"	PROJECT No:	2012-035	SHEET No:	A1
-------	------------	-------------	----------	-----------	----

DRAWING SHEET SIZE: A1 (841mm x 594mm) PLOT 1:1