



ELEMENTARY DIAGRAM:

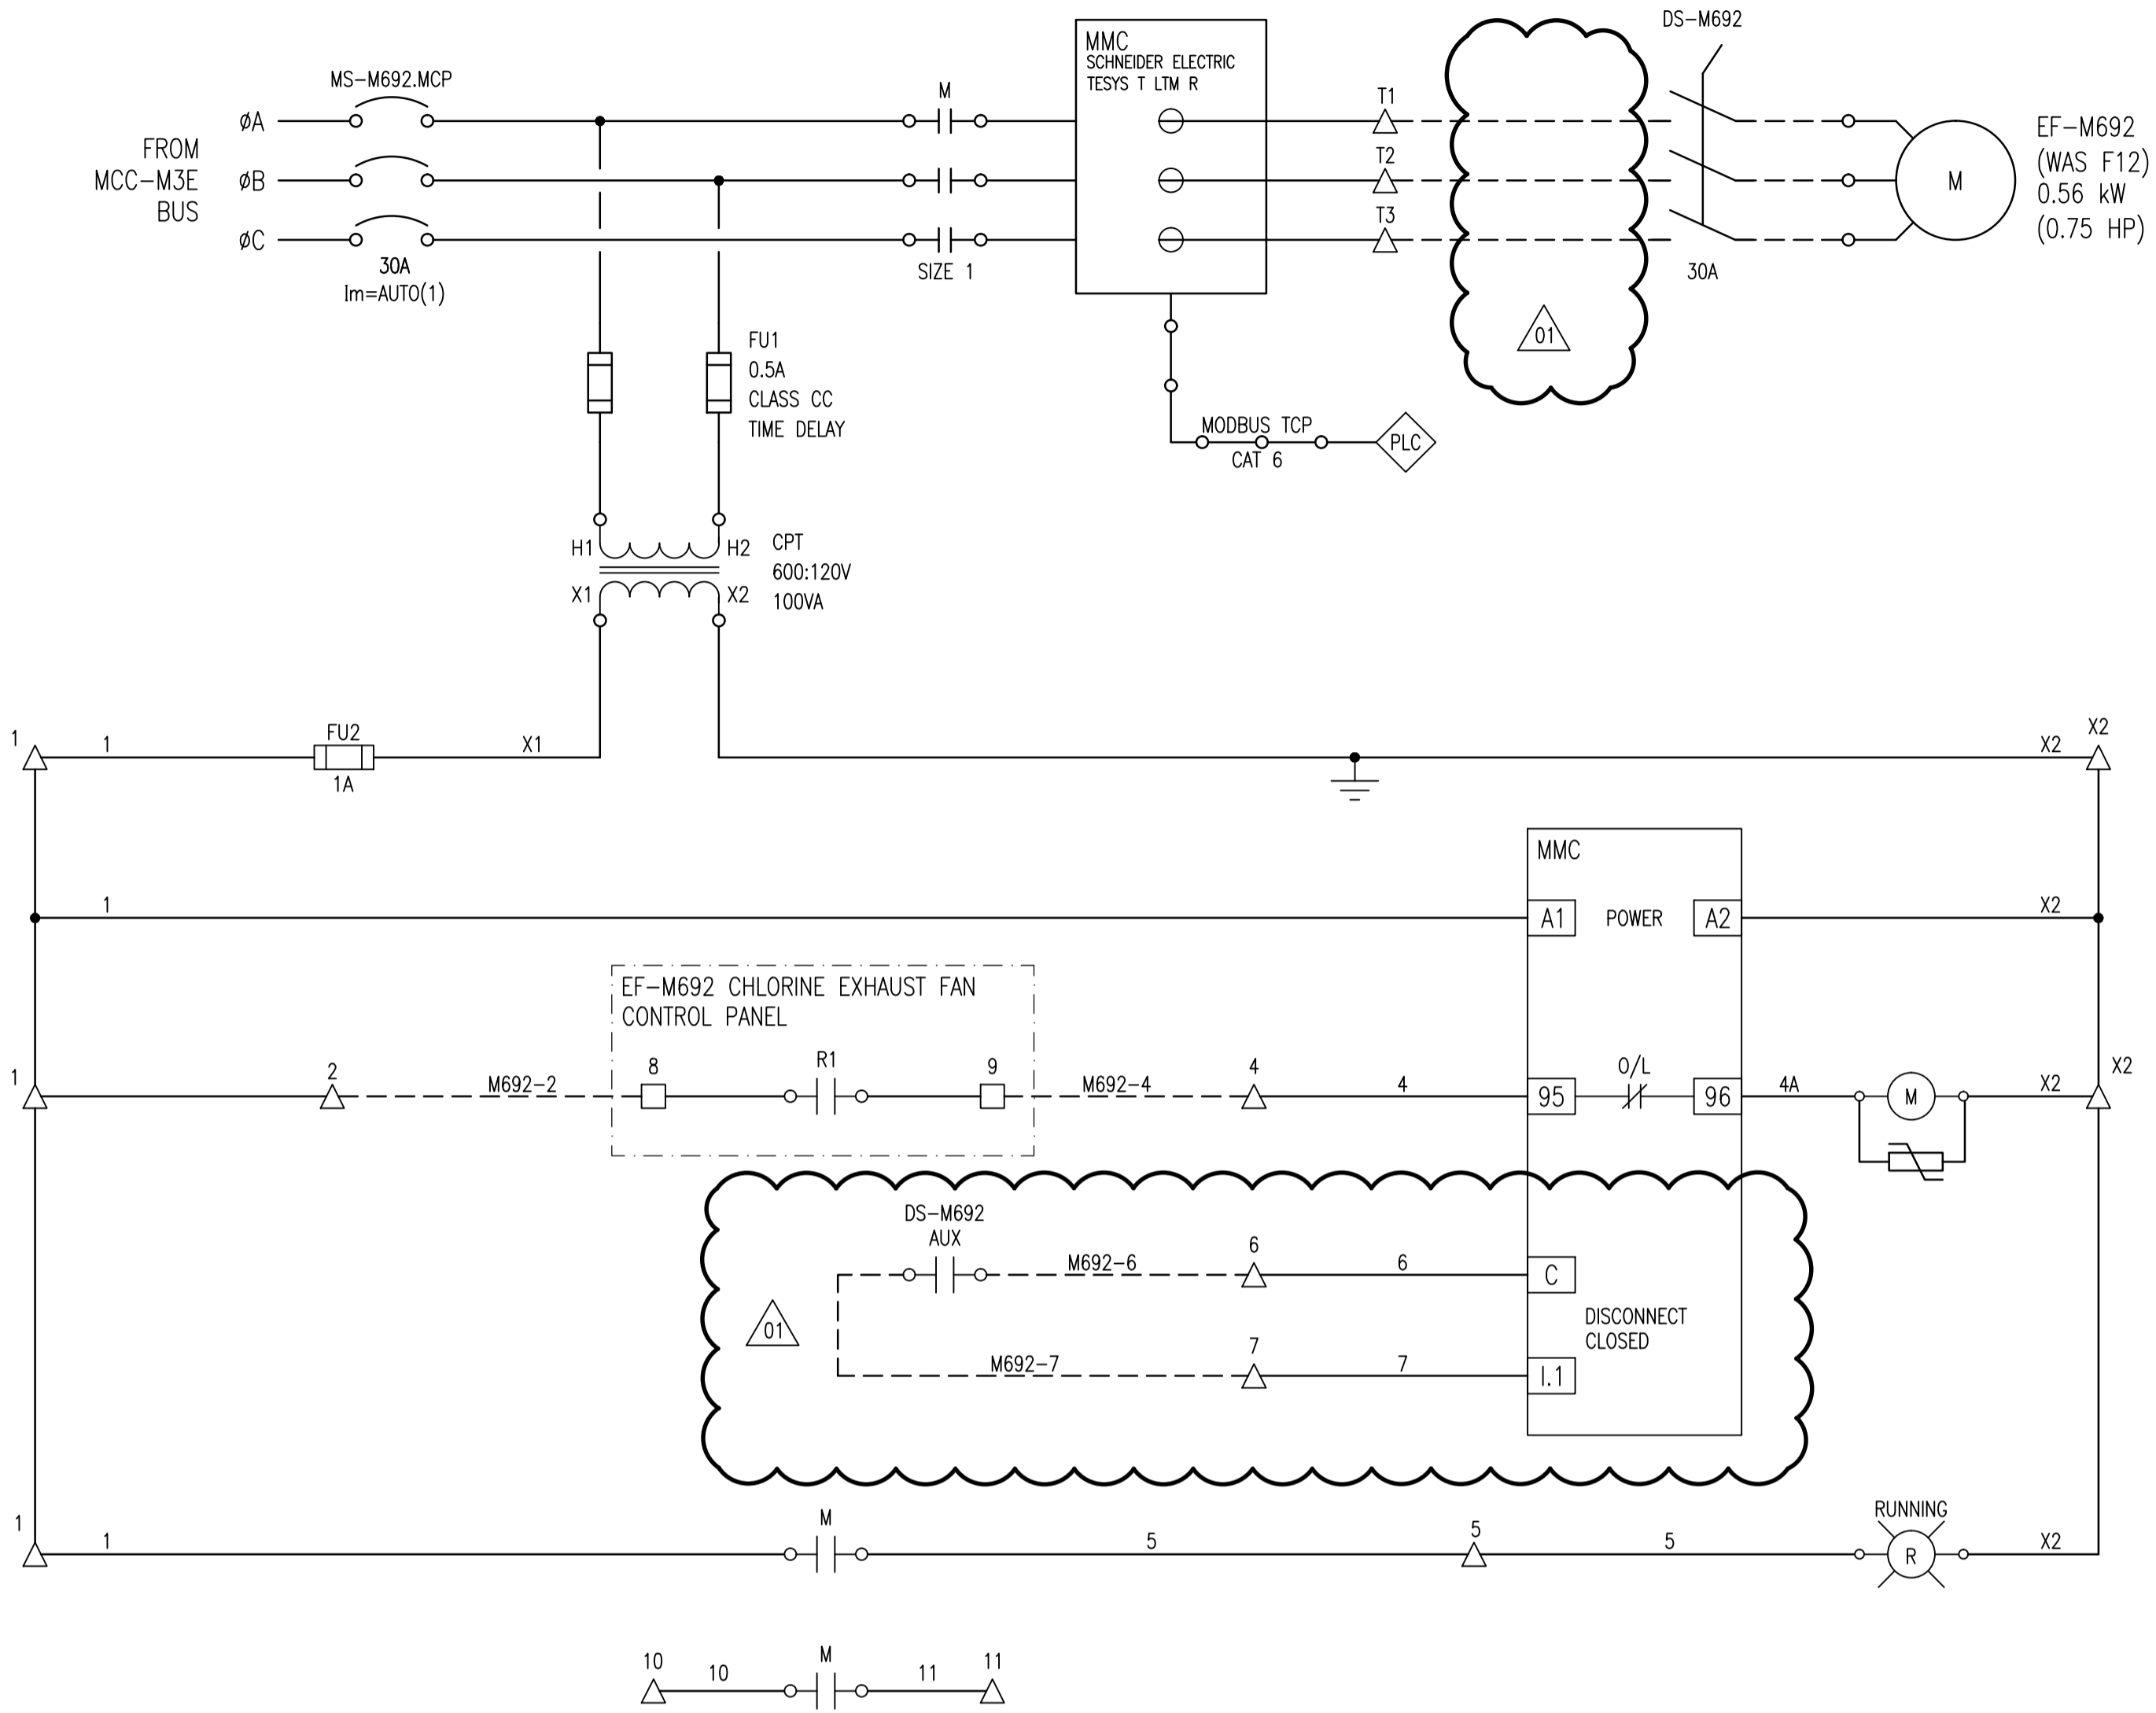

FIELD CONNECTION DIAGRAM:

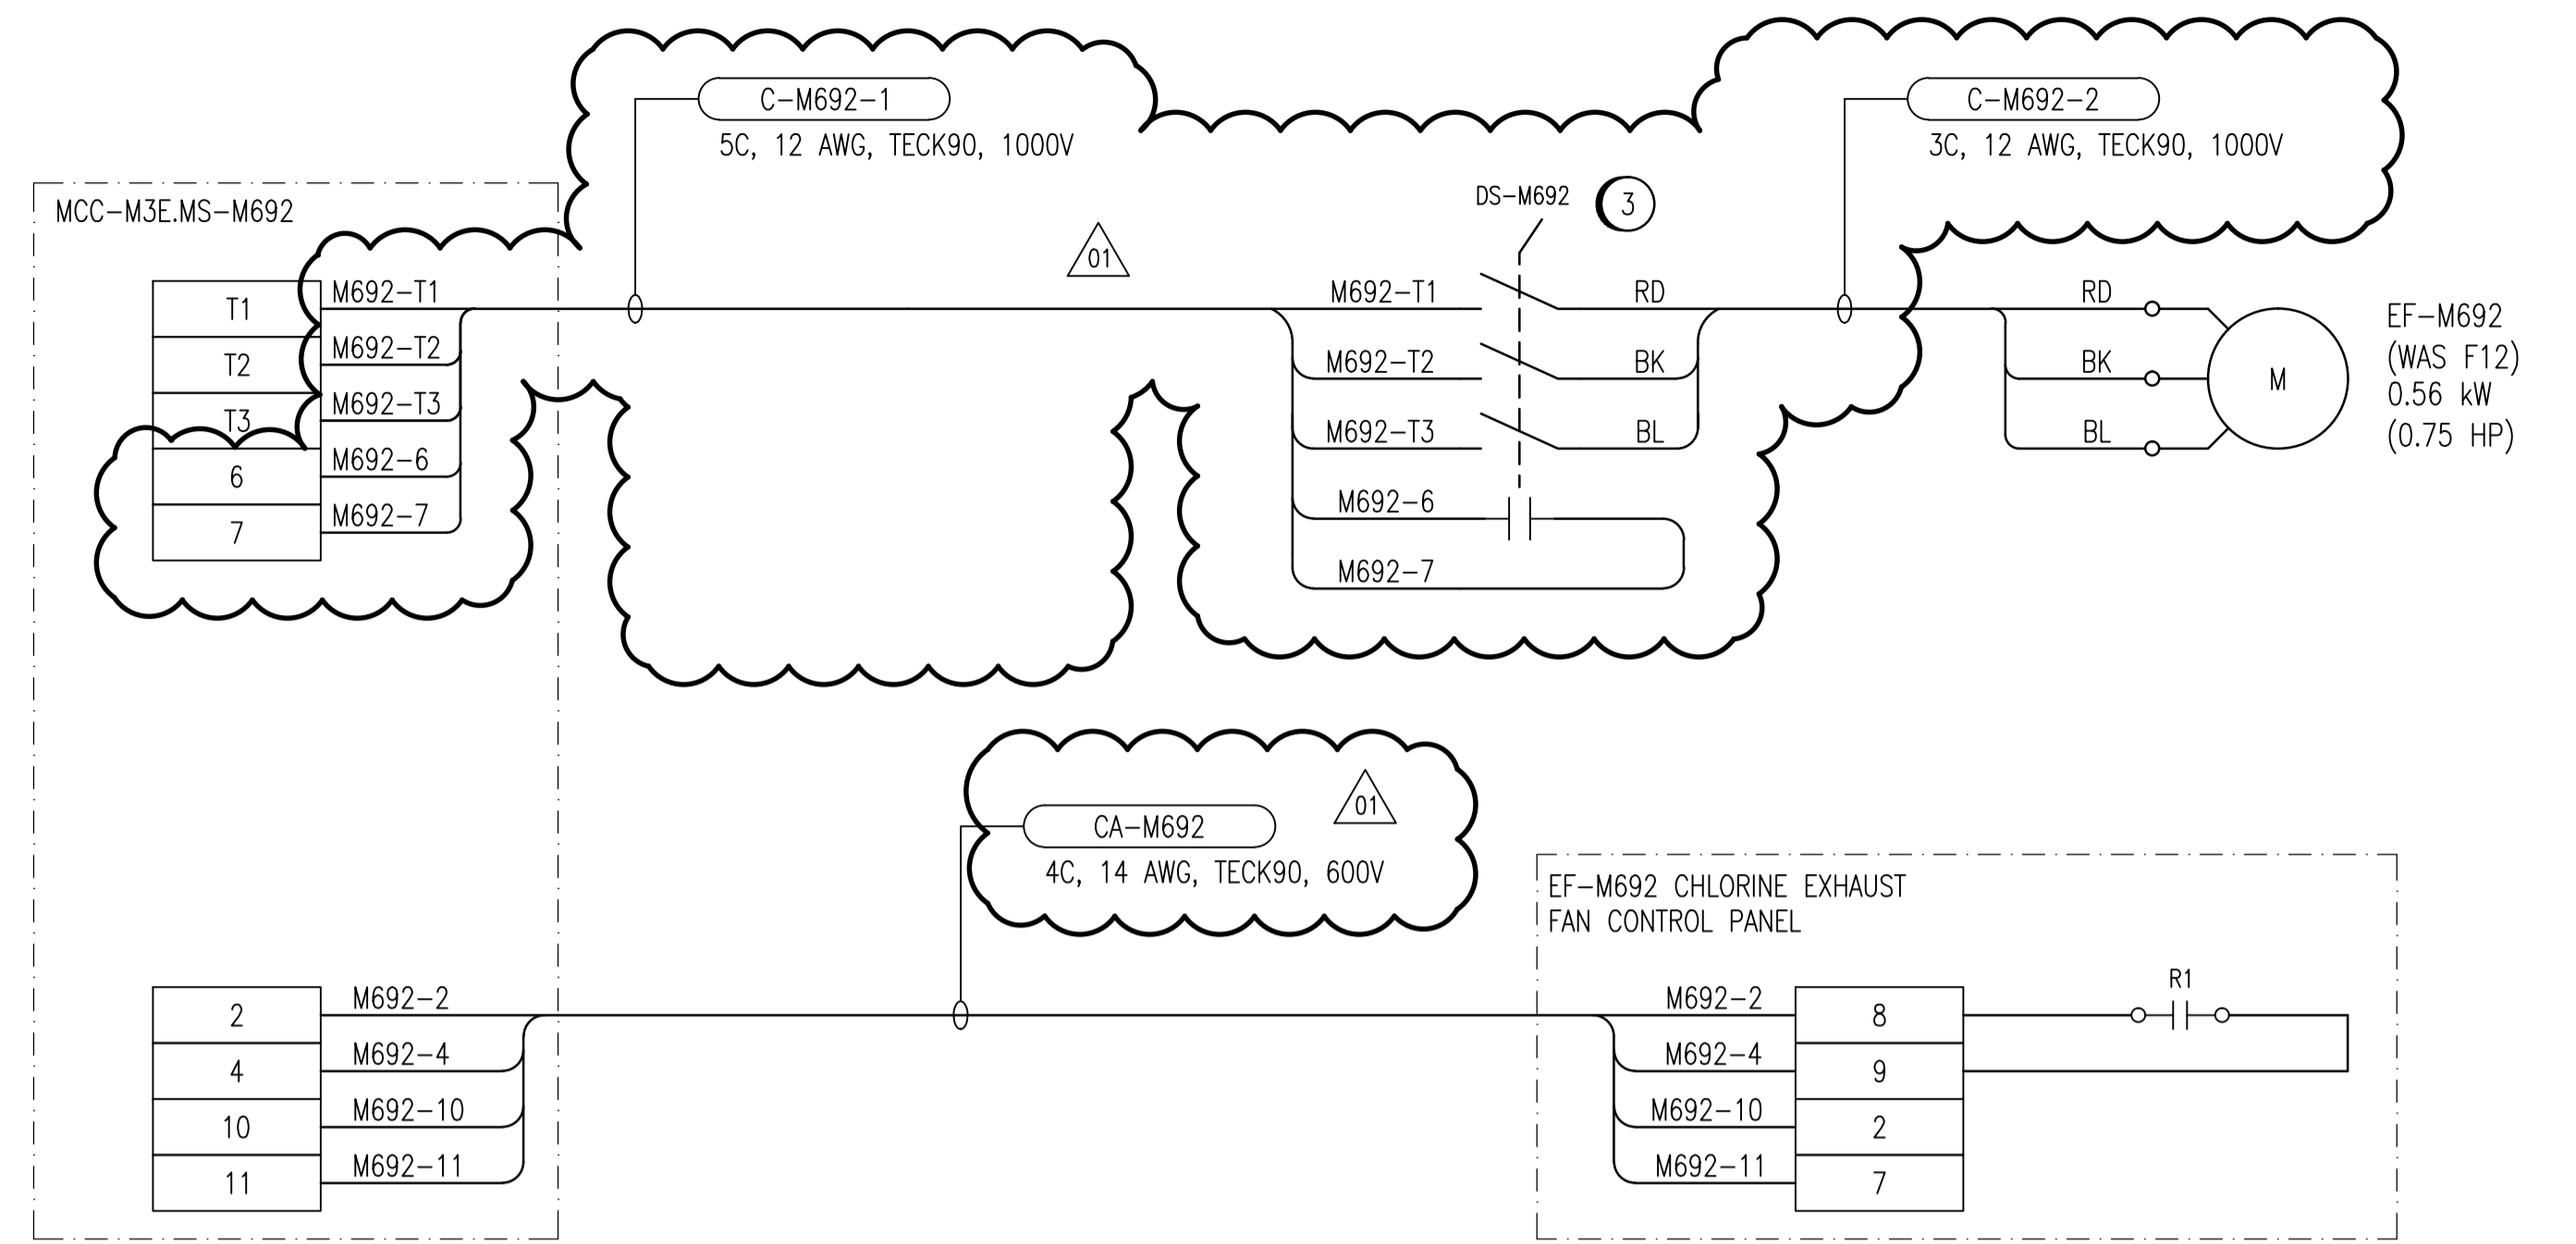

CONSTRUCTION NOTES:

- INVESTIGATE EXISTING WIRING TO THE EXHAUST FAN CONTROL PANEL(S) AND MODIFY WIRING FROM THAT SHOWN AS REQUIRED TO REPLICATE EXISTING FUNCTIONALITY. PROVIDE AS-BUILT MARKUPS TO THE CONTRACT ADMINISTRATOR.
- PROVIDE IDENTIFICATION LAMACOIDS FOR ALL CHLORINE EXHAUST FAN CONTROL PANELS APPLICABLE TO EF-M692.
- REPLACE EXISTING FUSIBLE DISCONNECT SWITCH WITH NON-FUSIBLE DISCONNECT SWITCH, COMPLETE WITH AUXILIARY CONTACT.

LEGEND:

	TERMINAL IN MOTOR STARTER COMPARTMENT
	TERMINAL IN LCP-M600
	TERMINAL IN JUNCTION BOX
	INDICATING LIGHT, R = RED, A = AMBER
	CONTACTOR COIL
	TRANSIENT VOLTAGE SUPPRESSOR

1-0630M-E0027	MCC ELEVATION, MCC-M3E
1-0630M-E0025	SINGLE LINE DIAGRAM, MCC-M3E
DRAWING NUMBER	REFERENCE DRAWINGS



NO.	REVISIONS	DATE	DESIGN	CHECK
01	ADDENDUM 1, BID OPP. 490-2012	2012/08/14	BJC	CJR
00	ISSUED FOR TENDER, BID OPP. 490-2012	2012/07/23	BJC	CJR

 SNC-LAVALIN INC. 148 Nature Park Way Winnipeg, MB, Canada R3P 0X7 204-786-8080	
DESIGNED BY: B. CLEVEN	CHECKED BY: C. REIMER
DRAWN BY: M.J. PERSSON	APPROVED BY: C. REIMER
SCALE: NTS	RELEASED FOR CONSTRUCTION BY: DATE:
DATE: 2012/05/03	DATE:
CONSULTANT NO.: 508955-0000-47DD-0057	

ENGINEER'S SEAL  
**PRELIMINARY**  
 NOT TO BE  
 USED FOR  
 CONSTRUCTION

 THE CITY OF WINNIPEG WATER AND WASTE DEPARTMENT		
MACLEAN WATER PUMPING STATION		
MOTOR STARTER SCHEMATIC EF-M692 CL2 STORAGE ROOM EXHAUST FAN		
CITY DRAWING NUMBER 1-0630M-E0057	SHEET 001	REV. 01
		SIZE A1