


ARC FLASH VALUES ARE PRELIMINARY AND WILL BE FINALIZED DURING CONSTRUCTION.

LEGEND:
 ——— EXISTING
 ——— NEW WORK
 - - - FUTURE

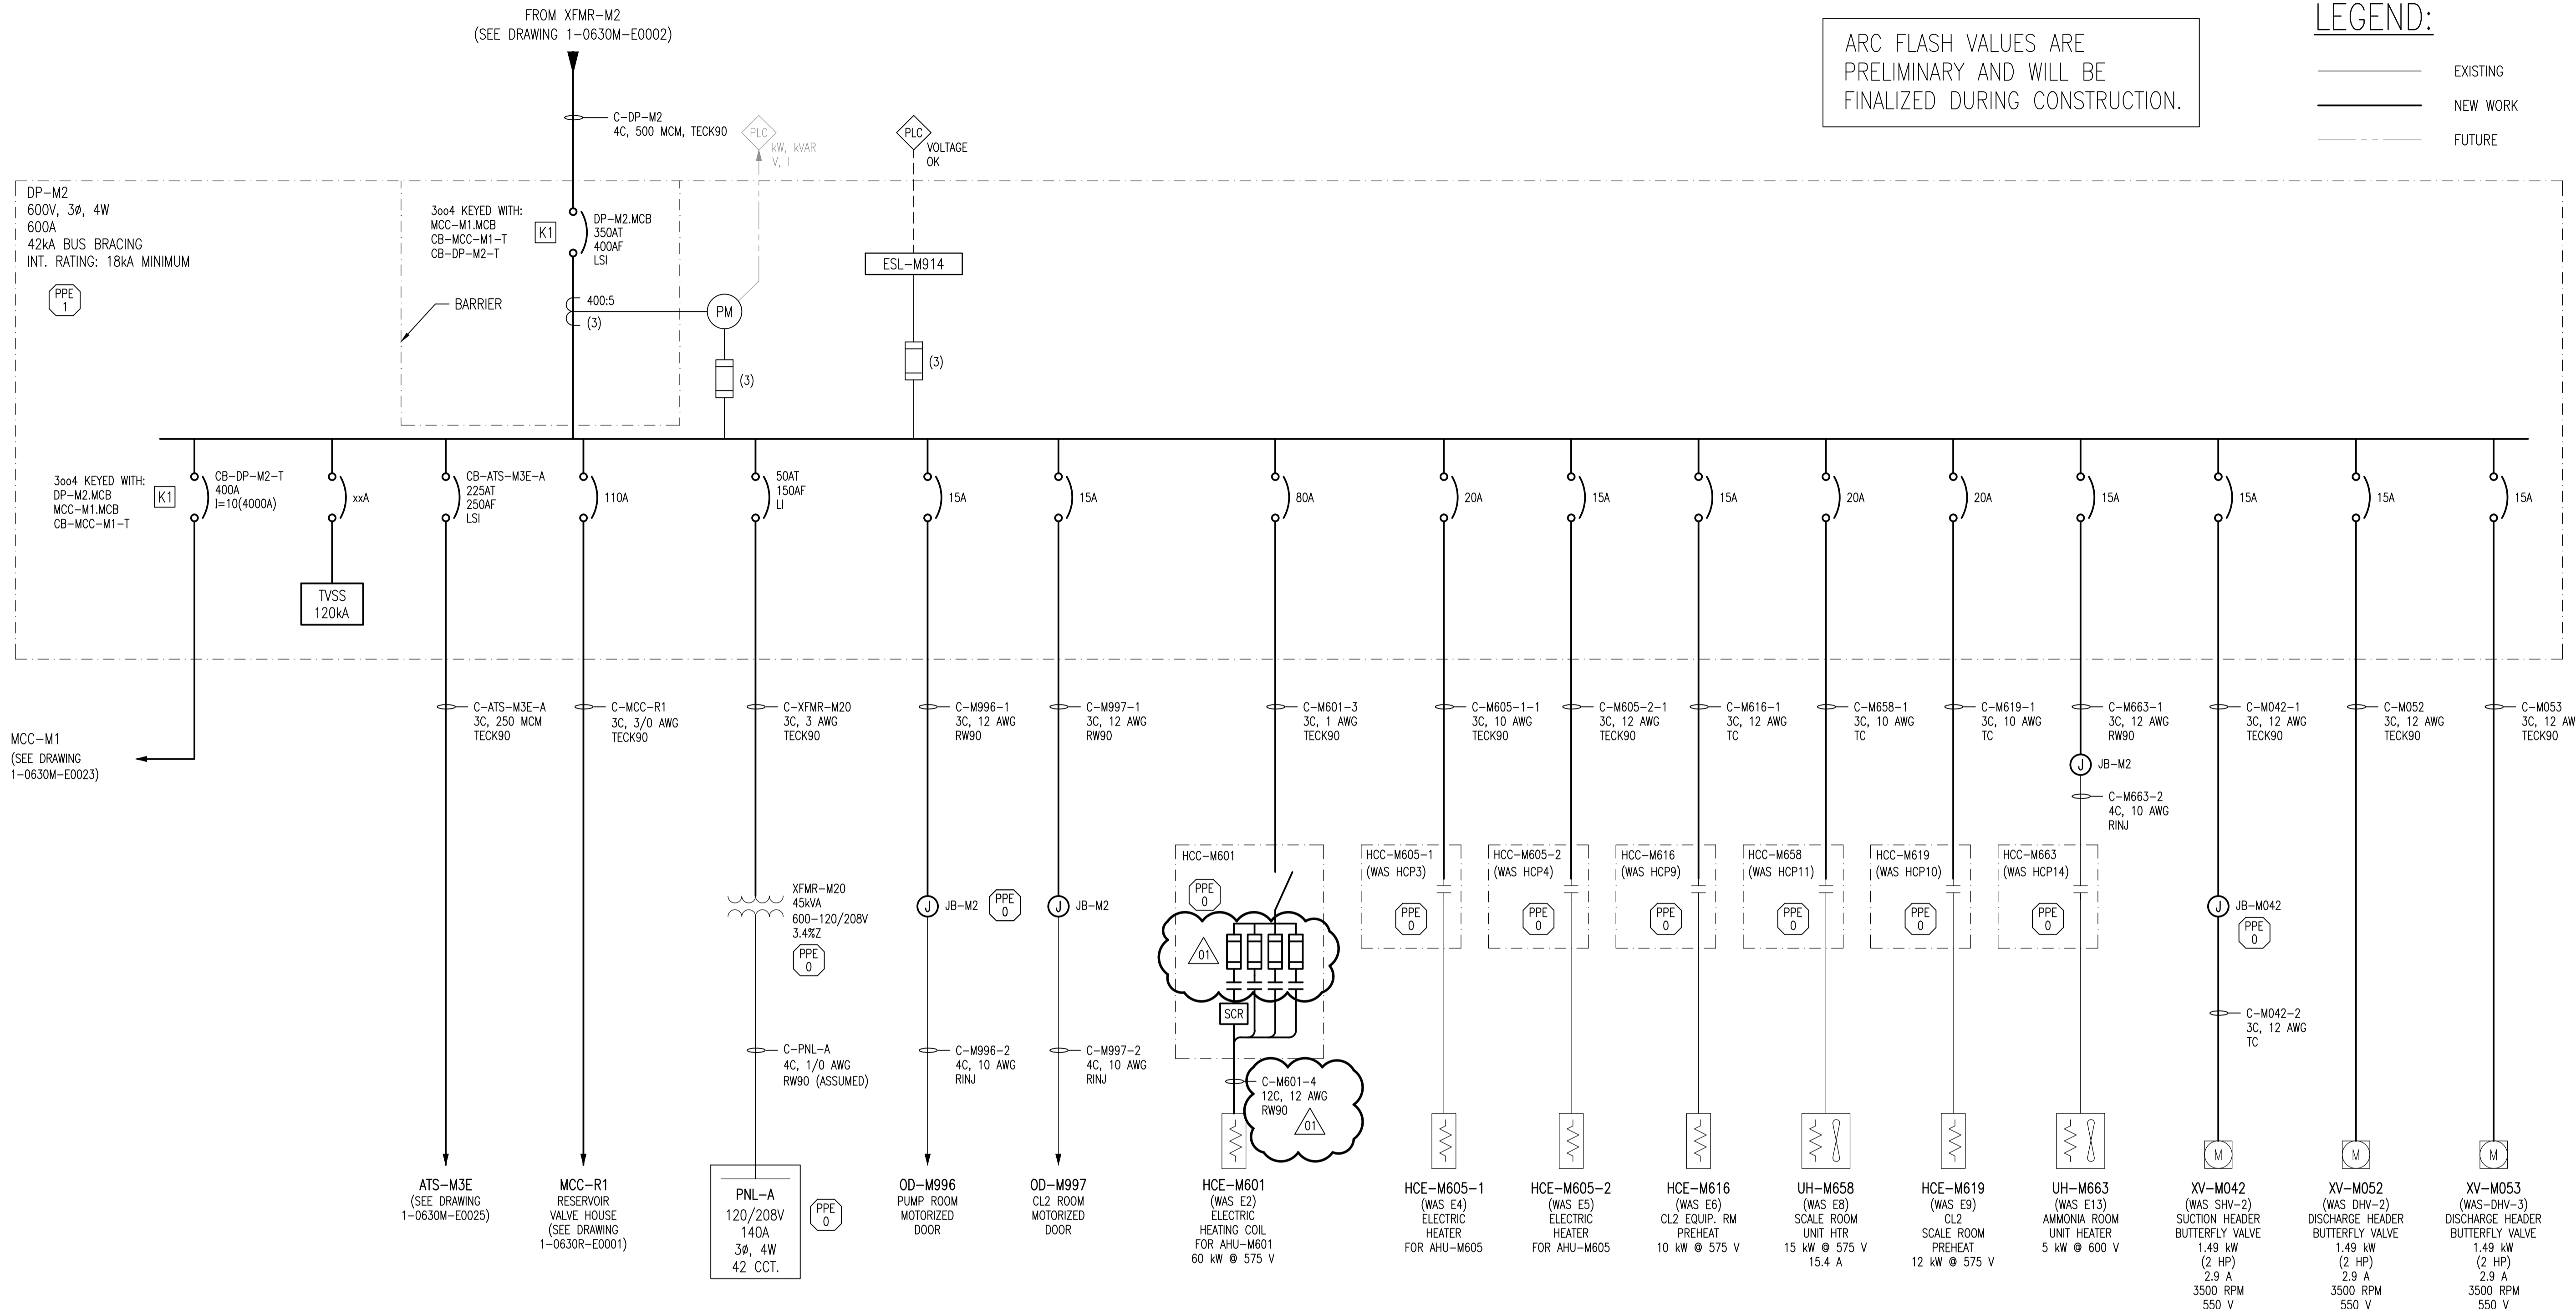

1-0630M-E0029	PANEL SCHEDULE AND DETAILS - DP-M2
1-0630M-E0001	ELECTRICAL SINGLE LINE DIAGRAM LEGEND AND DETAILS
DRAWING NUMBER	REFERENCE DRAWINGS



NO.	REVISIONS	DATE	DESIGN	CHECK
01	ADDENDUM 2, BID OPP. 490-2012	2012/08/22	BJC	CJR
00	ISSUED FOR TENDER, BID OPP. 490-2012	2012/07/23	BJC	CJR

 SNC-LAVALIN INC. 148 Nature Park Way Winnipeg, MB, Canada R3P 0X7 204-786-8080	
DESIGNED BY: B. CLEVEN	CHECKED BY: C. REIMER
DRAWN BY: S. FUNK	APPROVED BY: C. REIMER
SCALE: NTS	RELEASED FOR CONSTRUCTION BY:
DATE: 2011/01/25	DATE:
CONSULTANT NO.: 508955-0000-47DD-0024	

ENGINEER'S SEAL
PRELIMINARY
 NOT TO BE
 USED FOR
 CONSTRUCTION

THE CITY OF WINNIPEG
 WATER AND WASTE DEPARTMENT

MACLEAN WATER PUMPING STATION

ELECTRICAL SINGLE LINE DIAGRAM
 DP-M2

CITY DRAWING NUMBER	SHEET	REV.	SIZE
1-0630M-E0024	001	01	A1