
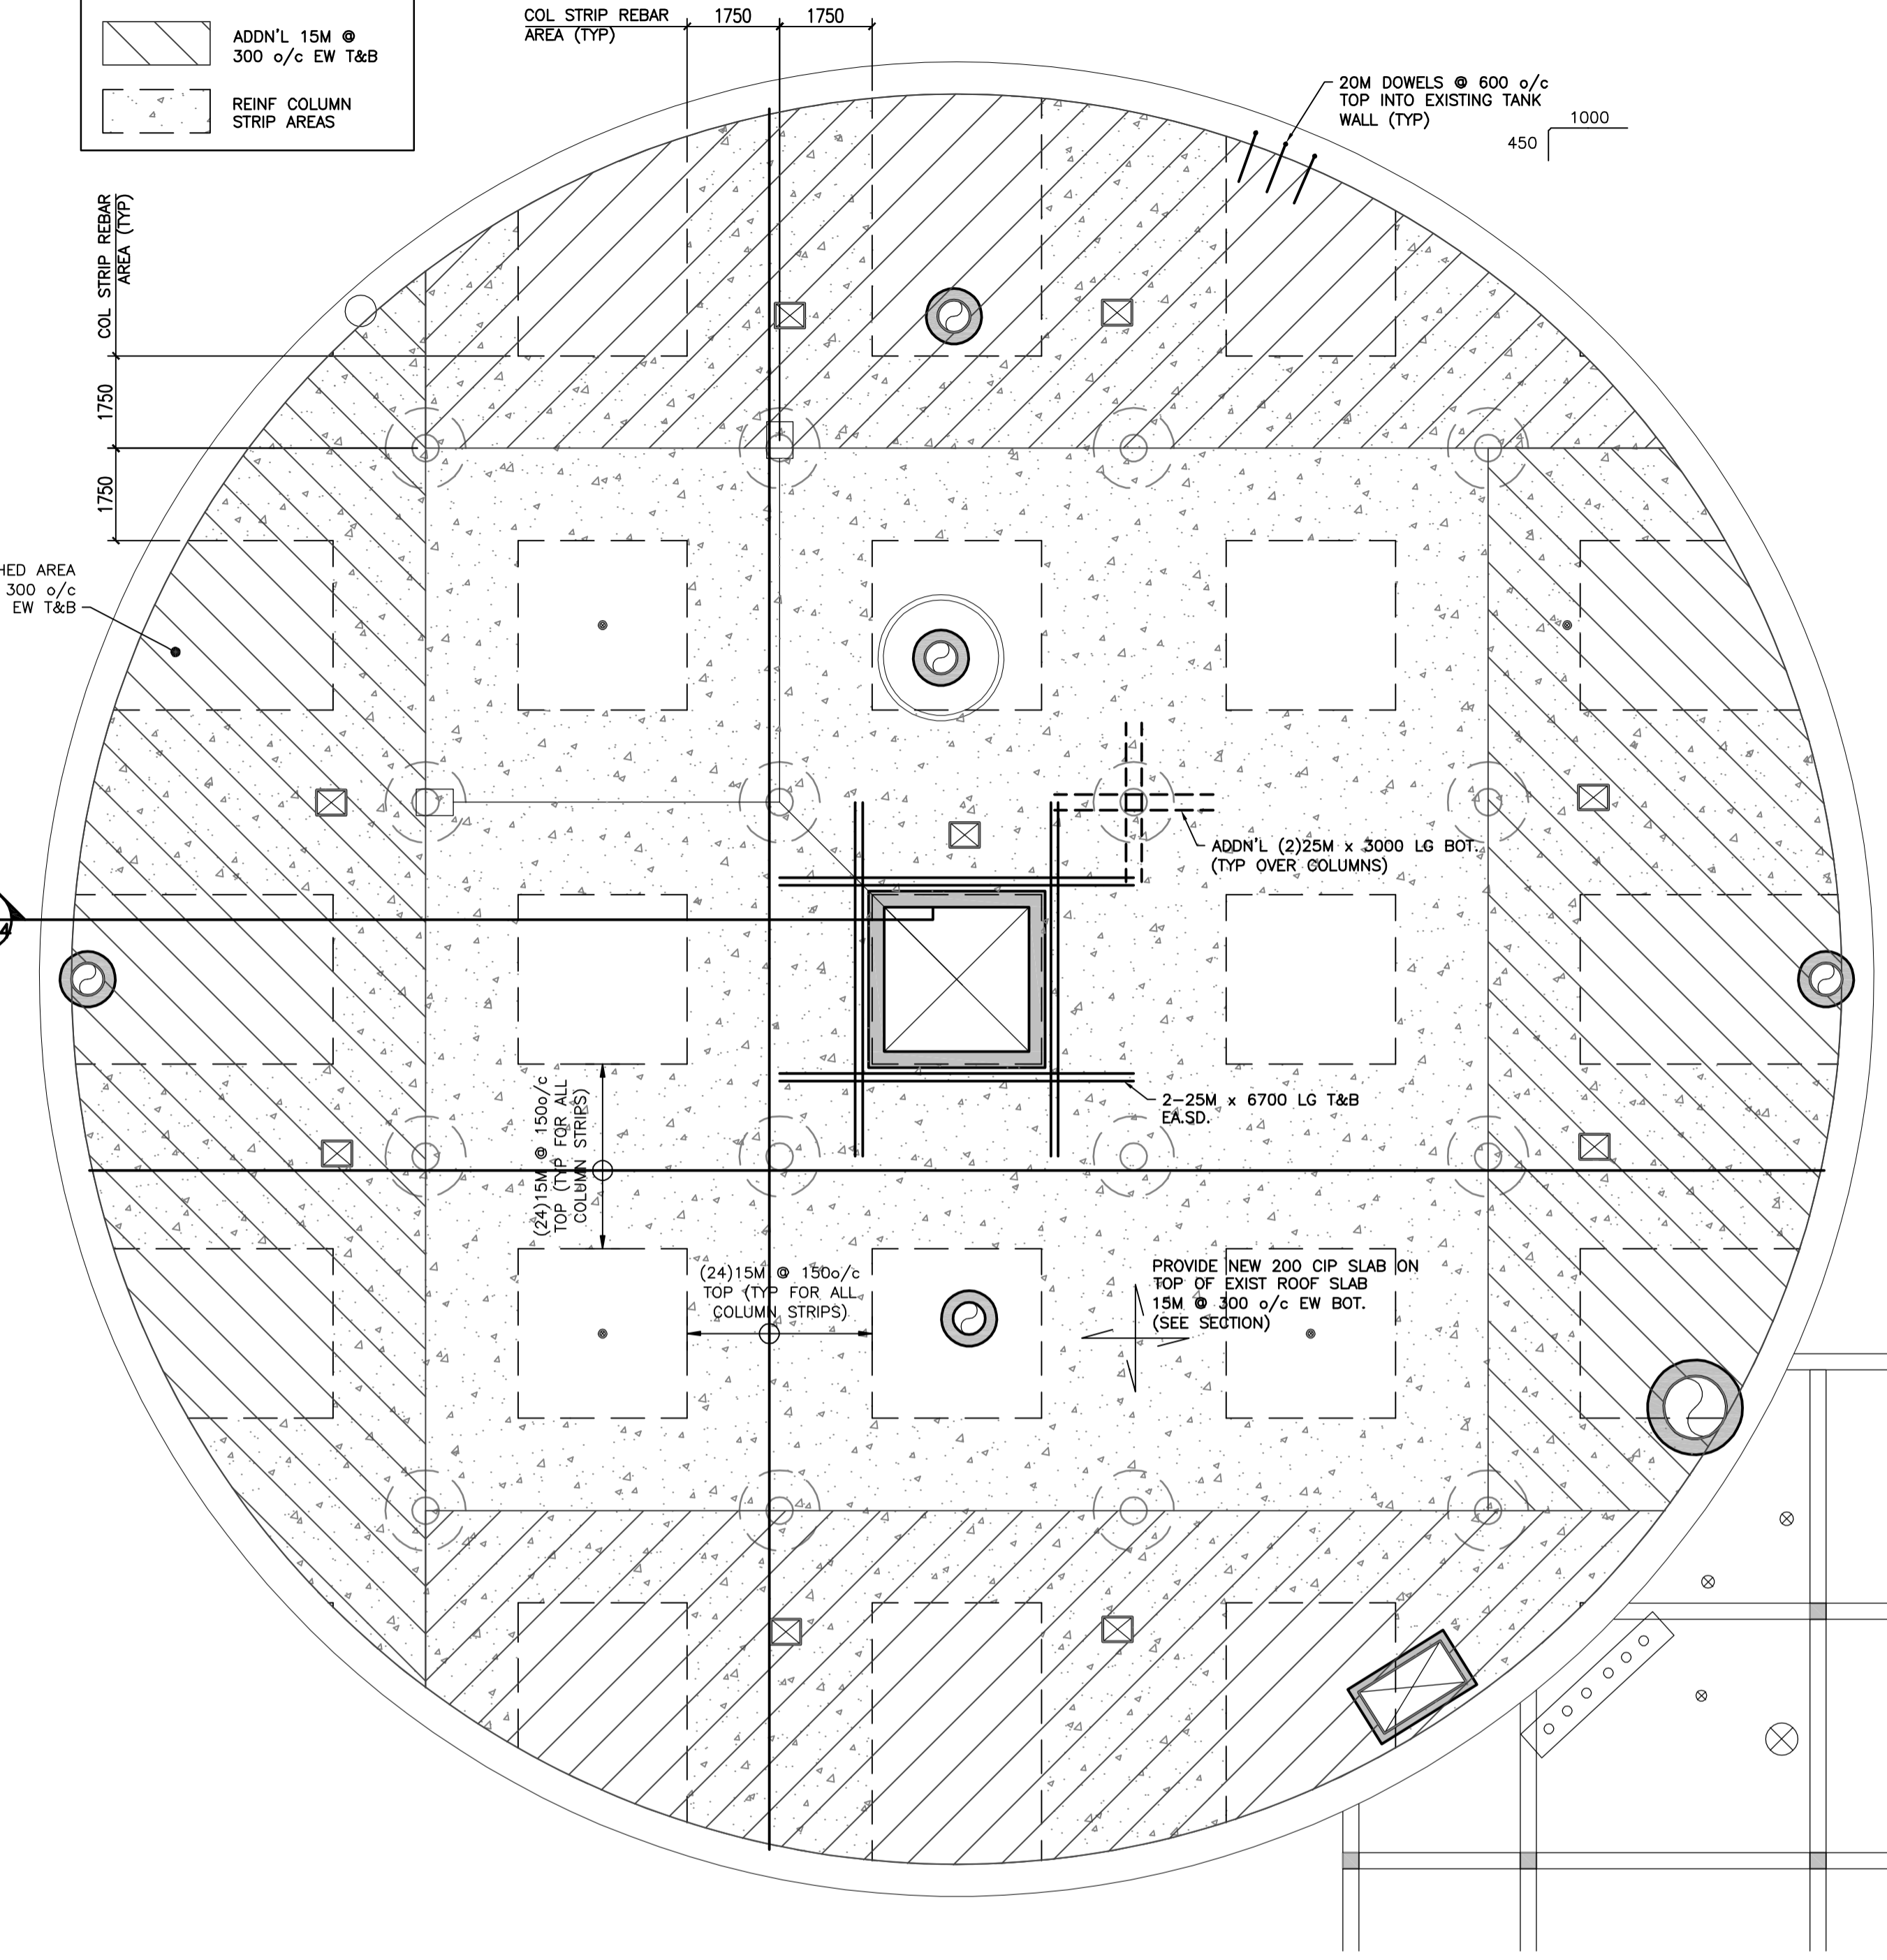


1
-
1:100


EXISTING DIGESTER TANK NO. 11 ROOF PLAN

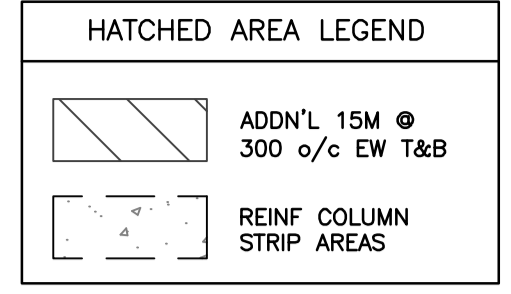

2
-
1:100

EXISTING DIGESTER TANK NO. 11 ADDN'L REINF PLAN

V:\1112\w\1112\2012_NSR\CD_Digester\Roofing\102_design\sheet_11.dwg (3/3_structural) 11/01/10-50003-001.dwg
2012 November 23, 9:46 am

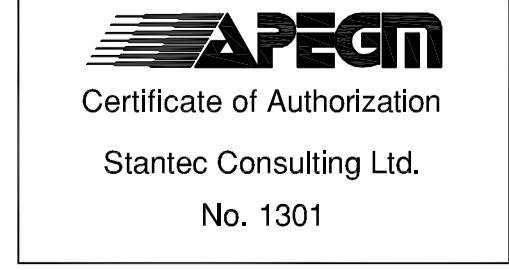

LOCATION APPROVED UNDERGROUND STRUCTURES

SUPV. U/G STRUCTURES COMMITTEE	DATE	B.M. ELEV.

NOTE:
LOCATION OF UNDERGROUND STRUCTURES AS SHOWN ARE BASED ON THE BEST INFORMATION AVAILABLE BUT NO GUARANTEE IS GIVEN THAT ALL EXISTING UTILITIES ARE SHOWN OR THAT THE GIVEN LOCATIONS ARE EXACT. CONFIRMATION OF EXISTENCE AND EXACT LOCATION OF ALL SERVICES MUST BE OBTAINED FROM THE INDIVIDUAL UTILITIES BEFORE PROCEEDING WITH CONSTRUCTION.

NO.	REVISIONS	DATE	BY
4	ISSUED FOR ADDENDUM 3	12.11.23	J.R.B.
3	ISSUED FOR TENDER	12.11.01	S.K.B.
2	ISSUED FOR 95% REVIEW	12.09.12	S.K.B.
1	ISSUED FOR 60% REVIEW	12.07.27	S.K.B.

Stantec Consulting Ltd.
905 Waverley Street, Winnipeg, Manitoba
Tel 204-489-5900 Fax 204-453-9012

DESIGNED BY: B.F. CHECKED BY: BF
DRAWN BY: I.R. APPROVED BY: S.K.B.

HOR. SCALE: AS SHOWN
VERTICAL: RELEASED FOR CONSTRUCTION:
DATE 2011.12.15

ENGINEER'S SEAL
ORIGINAL SEALED BY
B.E. FRASER
P. ENG.
12.11.01

THE CITY OF WINNIPEG
WATER AND WASTE DEPARTMENT

Winnipeg

NORTH END WATER POLLUTION CONTROL CENTRE
REHABILITATION OF DIGESTER NO. II AND
SLUDGE TANK No. 5 AND 7

DIGESTER No. II - PLANS & SECTIONS

BID OPPORTUNITY NO. 573-2012
CITY DRAWING NUMBER I-OI0ID-S0003-001
SHEET 5 OF 29