


LEGEND

- LIMIT OF CONTRACT 'B'
- EXISTING ELEVATIONS
- PROPOSED CONTOUR LINE & EL.
- NEW SECONDARY TREATMENT BLDG.
- AREAS TO BE SEEDED
- EXISTING LAGOON BERMS
- BORE HOLES

NOTE:
INVERTS AND SIDE SLOPES OF DITCHES LOCATED
IN AREAS SHOWN TO BE SEEDED ARE TO
BE SODDED.

REVISIONS		
NO.	DATE	DETAIL
1	10/14/61	CATHODIC PROTECTION CABLE & ANODES ADDED
2	2/10/64	CATHODIC PROTECTION CABLE & ANODES ADDED

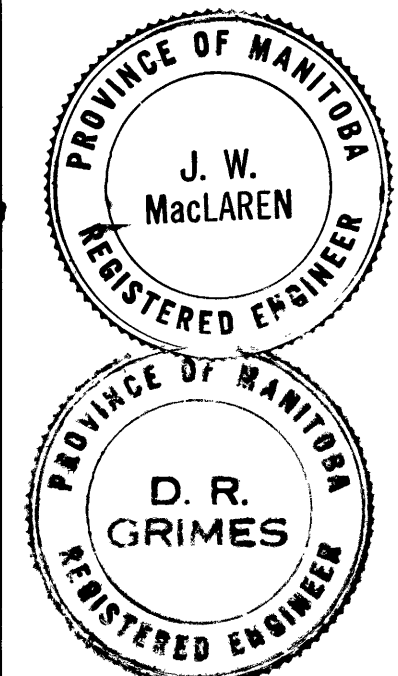

THE METROPOLITAN CORPORATION OF GREATER WINNIPEG
WATERWORKS AND WASTE DISPOSAL DIVISION

NORTH END SEWAGE TREATMENT PLANT

CONTRACT B - GENERAL SITE PLAN

APPROVED: *J. W. MacLaren*
JAMES F. MACLAREN LIMITED ENGINEERS TORONTO

APPROVED: *A. Perman*
ENGINEER OF WASTE DISPOSAL

APPROVED: *[Signature]*
DIRECTOR CHIEF ENGINEER

DATE: AUGUST 15, 1963
SCALE: 1" = 100'-0"

DWG. No. 218 OF 315

NEP-21E

NEP-0218

NR 10-124