


LIGHTING MAIN FLOOR PLAN
Scale 1:50

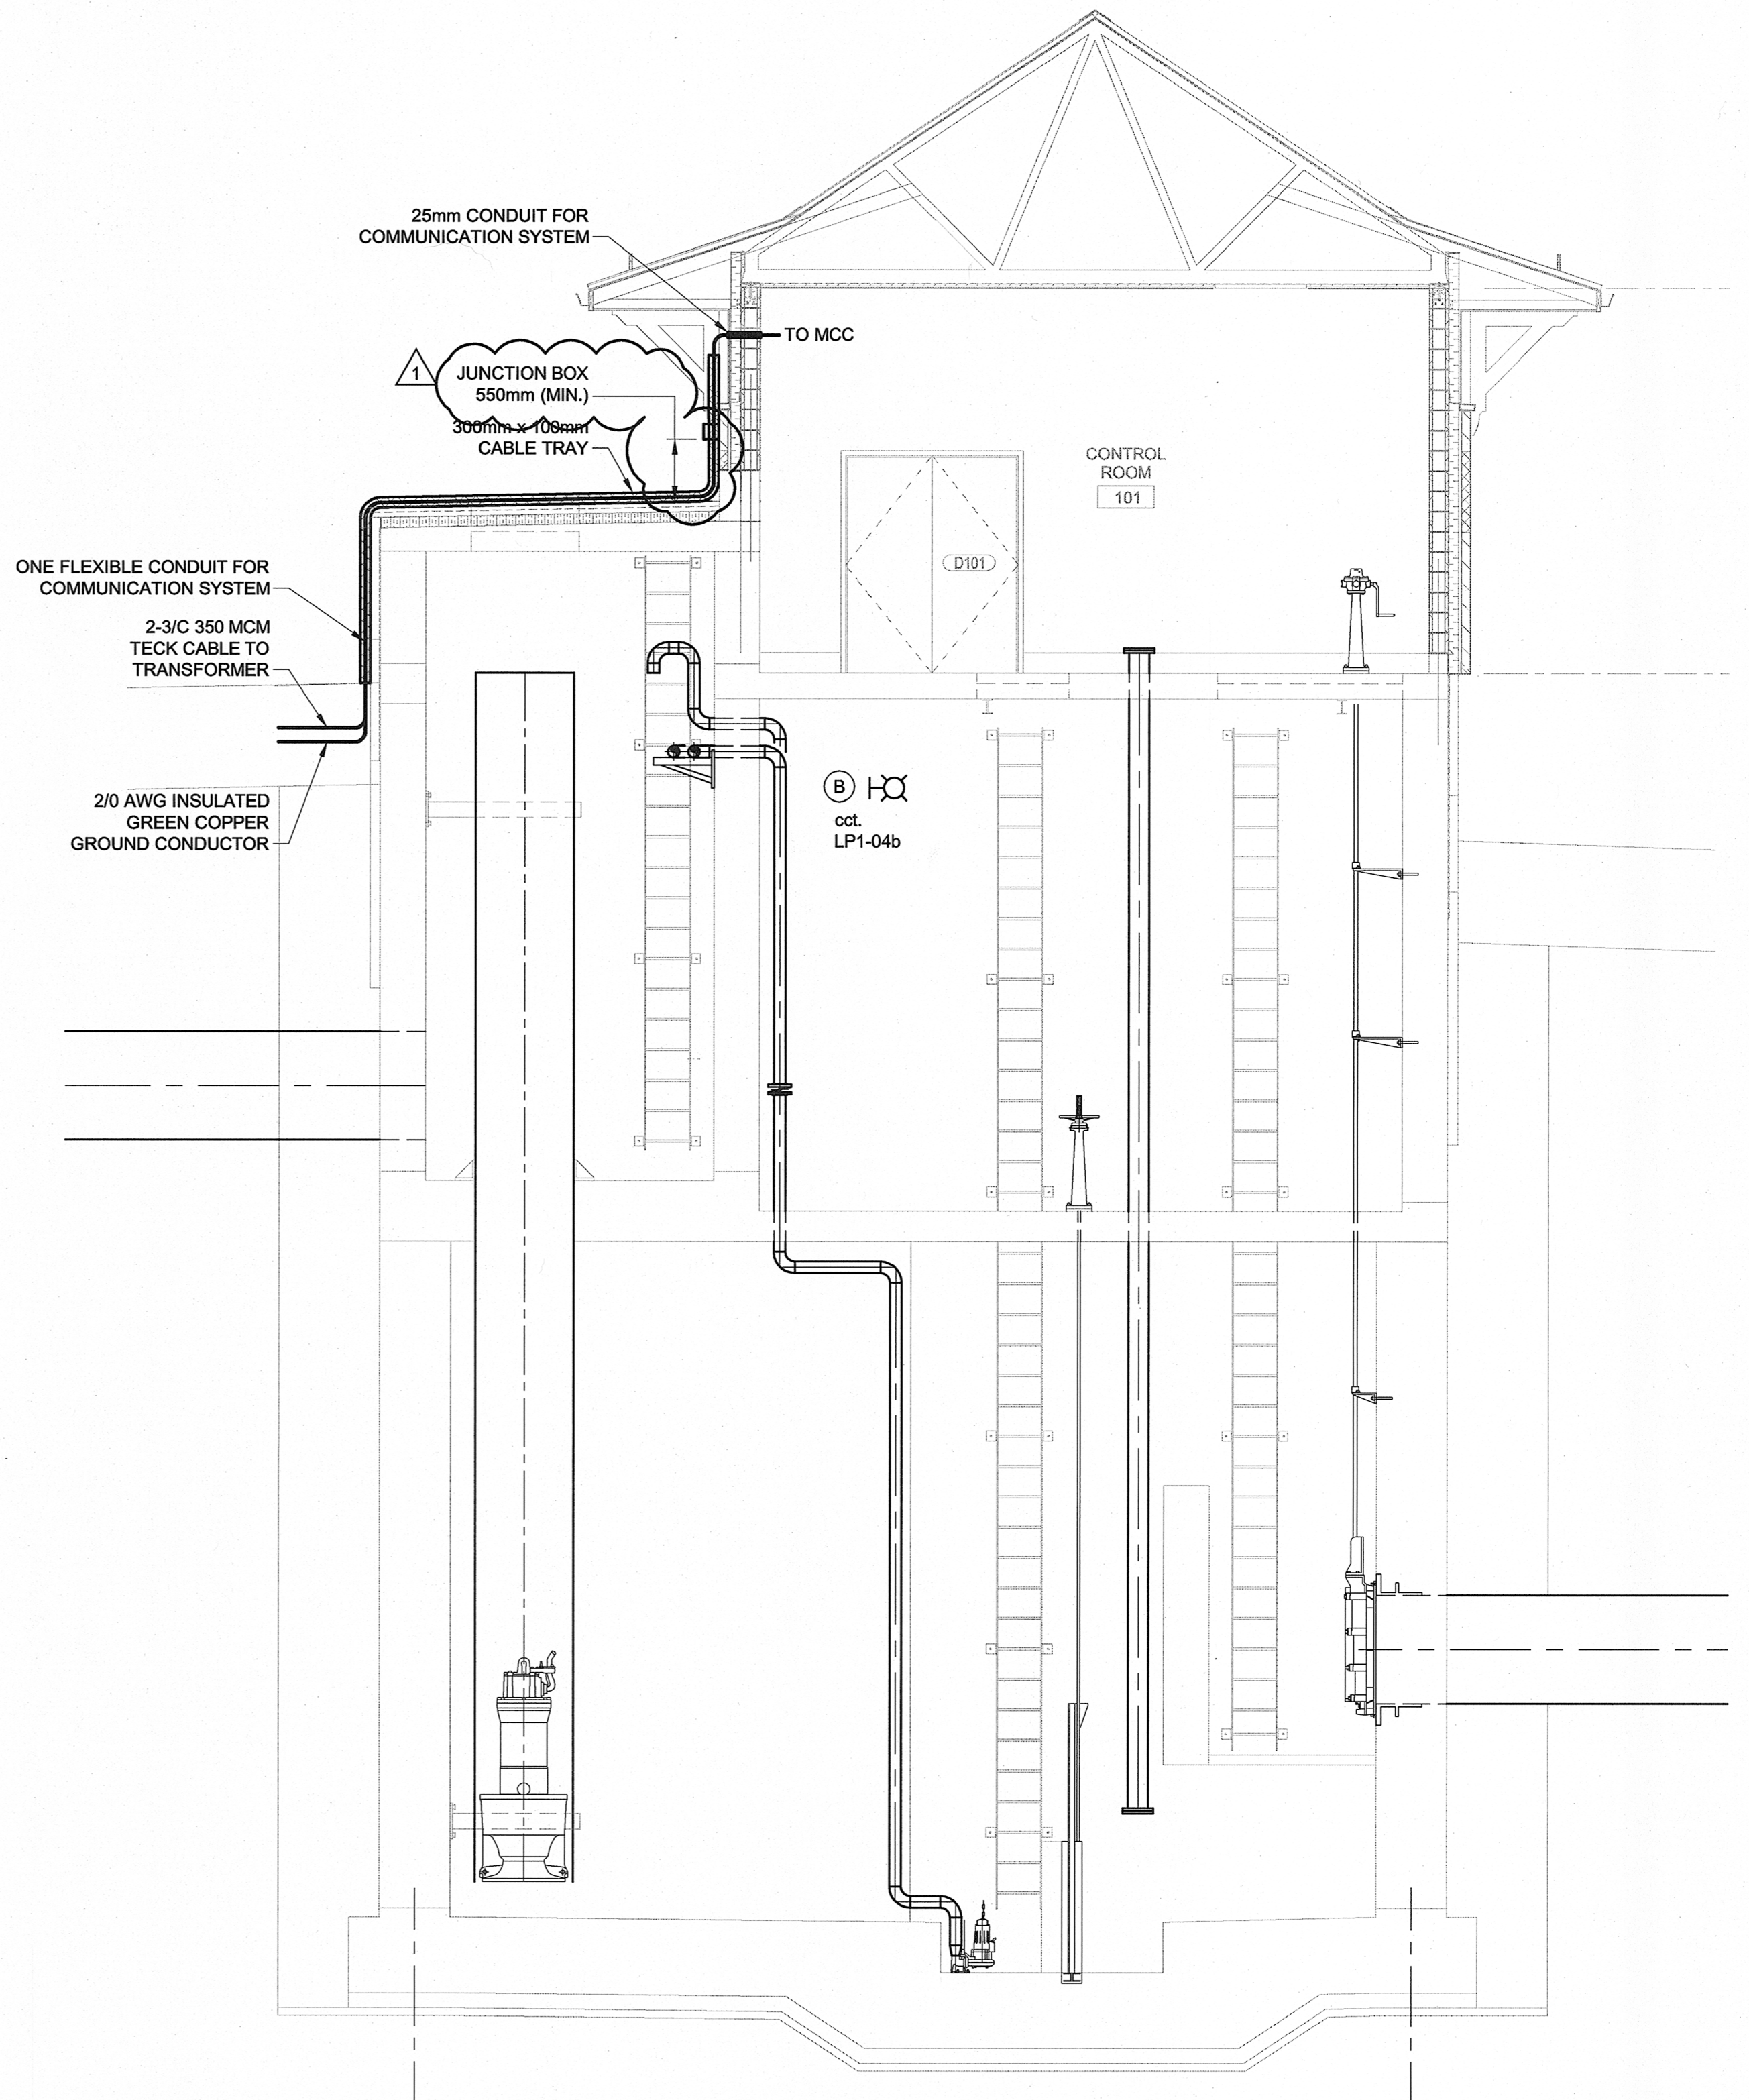

LIGHTING SECTION
Scale 1:50

APECM
Certificate of Authorization
AECOM Canada Ltd.
No. 4671 Date: Dec 19, 2013

LOCATION APPROVED UNDERGROUND STRUCTURES		B.M. ELEV.	
SUPV. U/G STRUCTURES COMMITTEE	DATE		
NOTE: LOCATION OF UNDERGROUND STRUCTURES AS SHOWN ARE BASED ON THE BEST INFORMATION AVAILABLE. BUT NO GUARANTEE IS GIVEN THAT ALL EXISTING UTILITIES ARE SHOWN OR THAT THE GIVEN LOCATIONS ARE EXACT. CONFIRMATION OF EXISTENCE AND EXACT LOCATION OF ALL SERVICES MUST BE OBTAINED FROM THE INDIVIDUAL UTILITIES BEFORE PROCEEDING WITH CONSTRUCTION.			
1	ISSUED FOR ADDENDUM	13/12/10	RB
0	ISSUED FOR TENDER	13/10/15	RB
NO.	REVISIONS	DATE	BY

AECOM

DESIGNED BY	RB	CHECKED BY	
DRAWN BY	RB	APPROVED BY	
HOR. SCALE:	AS NOTED	RELEASED FOR CONSTRUCTION BY:	
VERTICAL:	AS NOTED	DATE	

ENGINEER'S SEAL
PROVINCE OF MANITOBA
S.A. SABLER
Member
30812013
REGISTERED PROFESSIONAL ENGINEER
CONSULTANT DRAWING NO.
60273041-SHT-01-CON3-E-0003.DWG

THE CITY OF WINNIPEG PUBLIC WORKS DEPARTMENT

PLESSIS ROAD TWINNING AND GRADE SEPARATION AT CN REDDITT SUBDIVISION CONTRACT 3

ELECTRICAL LIGHTING MAIN FLOOR PLAN

CITY DRAWING NUMBER U238-2014-2353
SHEET 03 OF 09
E-0003