



NOTE:  
1. REMOVE ALL ABANDONED CABLE AND CONDUIT IN BASEMENT.

DILLON CONSULTING LIMITED 485 RICHMOND STREET, LONDON, ONTARIO, CANADA N6A 5A9. PHONE (519) 438-6192, FAX (519) 672-8209

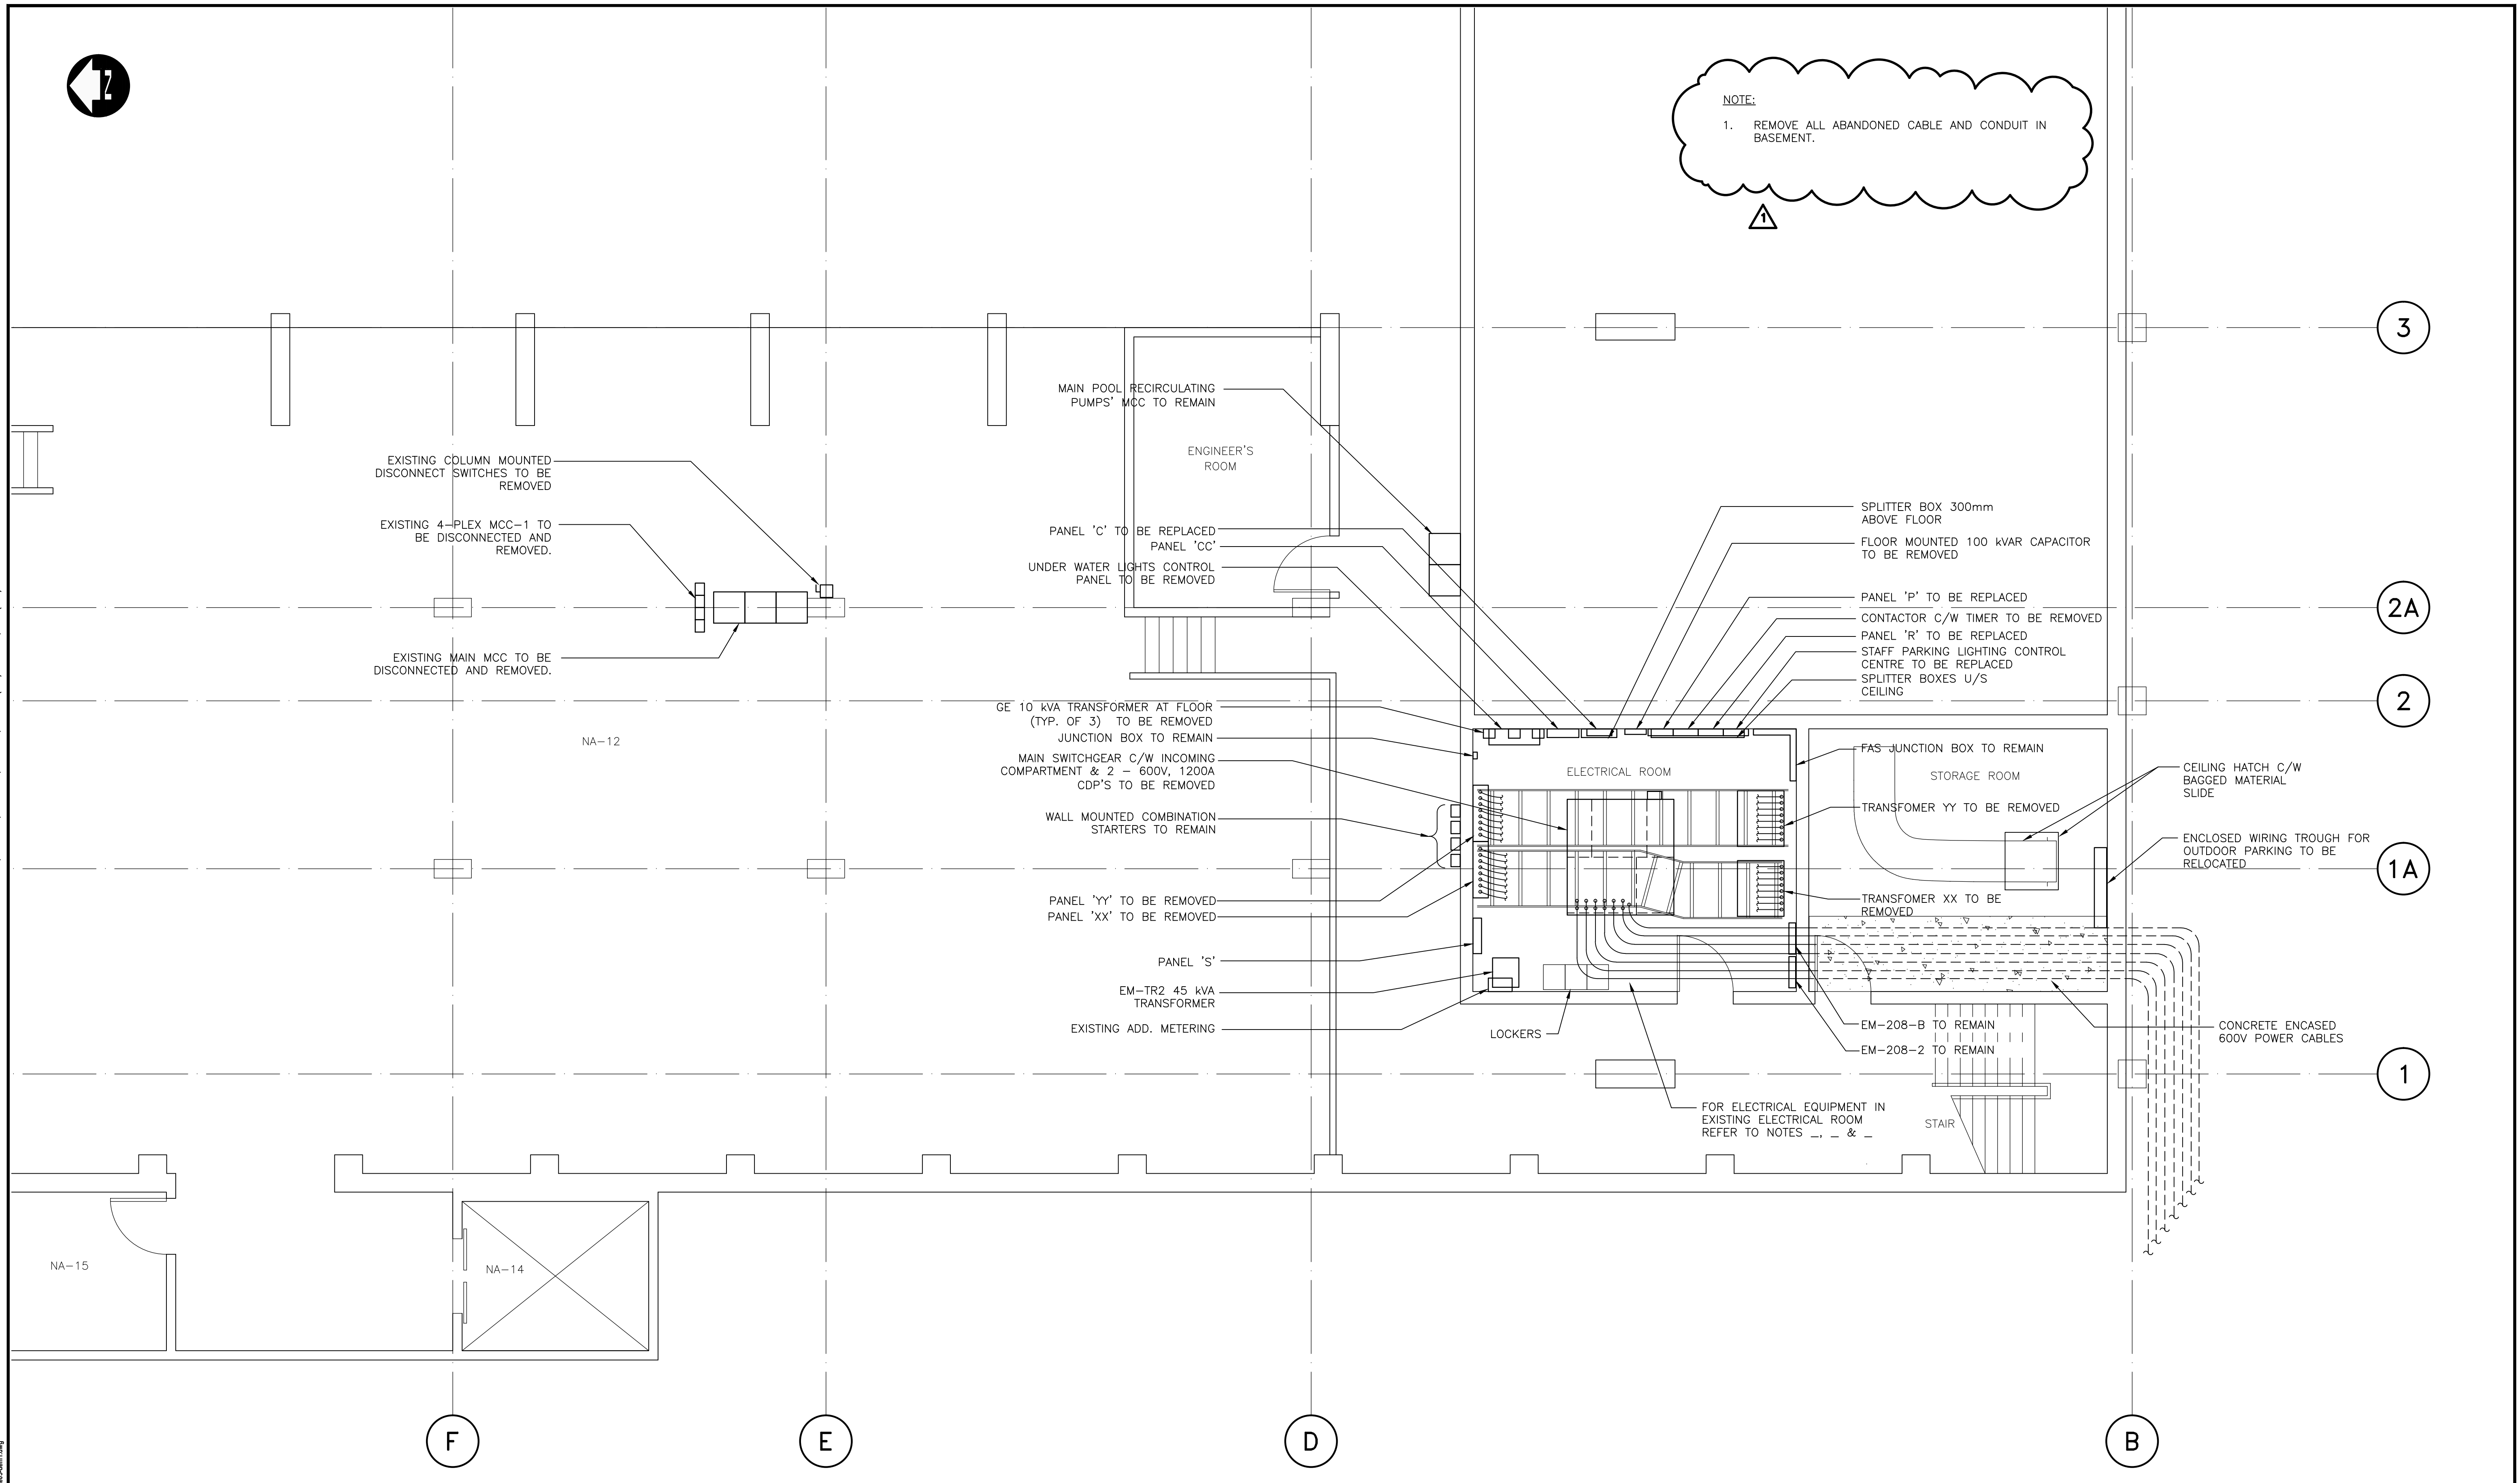

**Conditions of Use**  
Verify elevations and/or dimensions on drawing prior to use.  
Report any discrepancies to Dillon Consulting Limited.

Do not scale dimensions from drawing.  
Do not modify drawing, re-use it, or use it for purposes other than those intended at the time of its preparation without prior written permission from Dillon Consulting Limited.

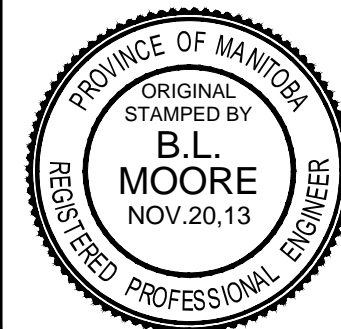

No.	ISSUED FOR	DATE	BY
1	ISSUED FOR ADDENDUM No.1	13-12-10	SCK
0	ISSUED FOR BID OPPORTUNITY NUMBER 850-2013	13-11-20	SCK

DESIGN	REVIEWED BY
DRAWN	CHECKED BY
DATE	FEB. 12, 2013
SCALE	1:50

PAN AM POOL ELECTRICAL UPGRADE

PROJECT NO.  
137300

**ELECTRICAL - DEMOLITION  
BASEMENT - PARTIAL FLOOR PLAN**

SHEET NO.

**ED01**