



PLAN
SCALE: 1 : 20

VERTICAL PRE-CAST BOX SECTION(S)

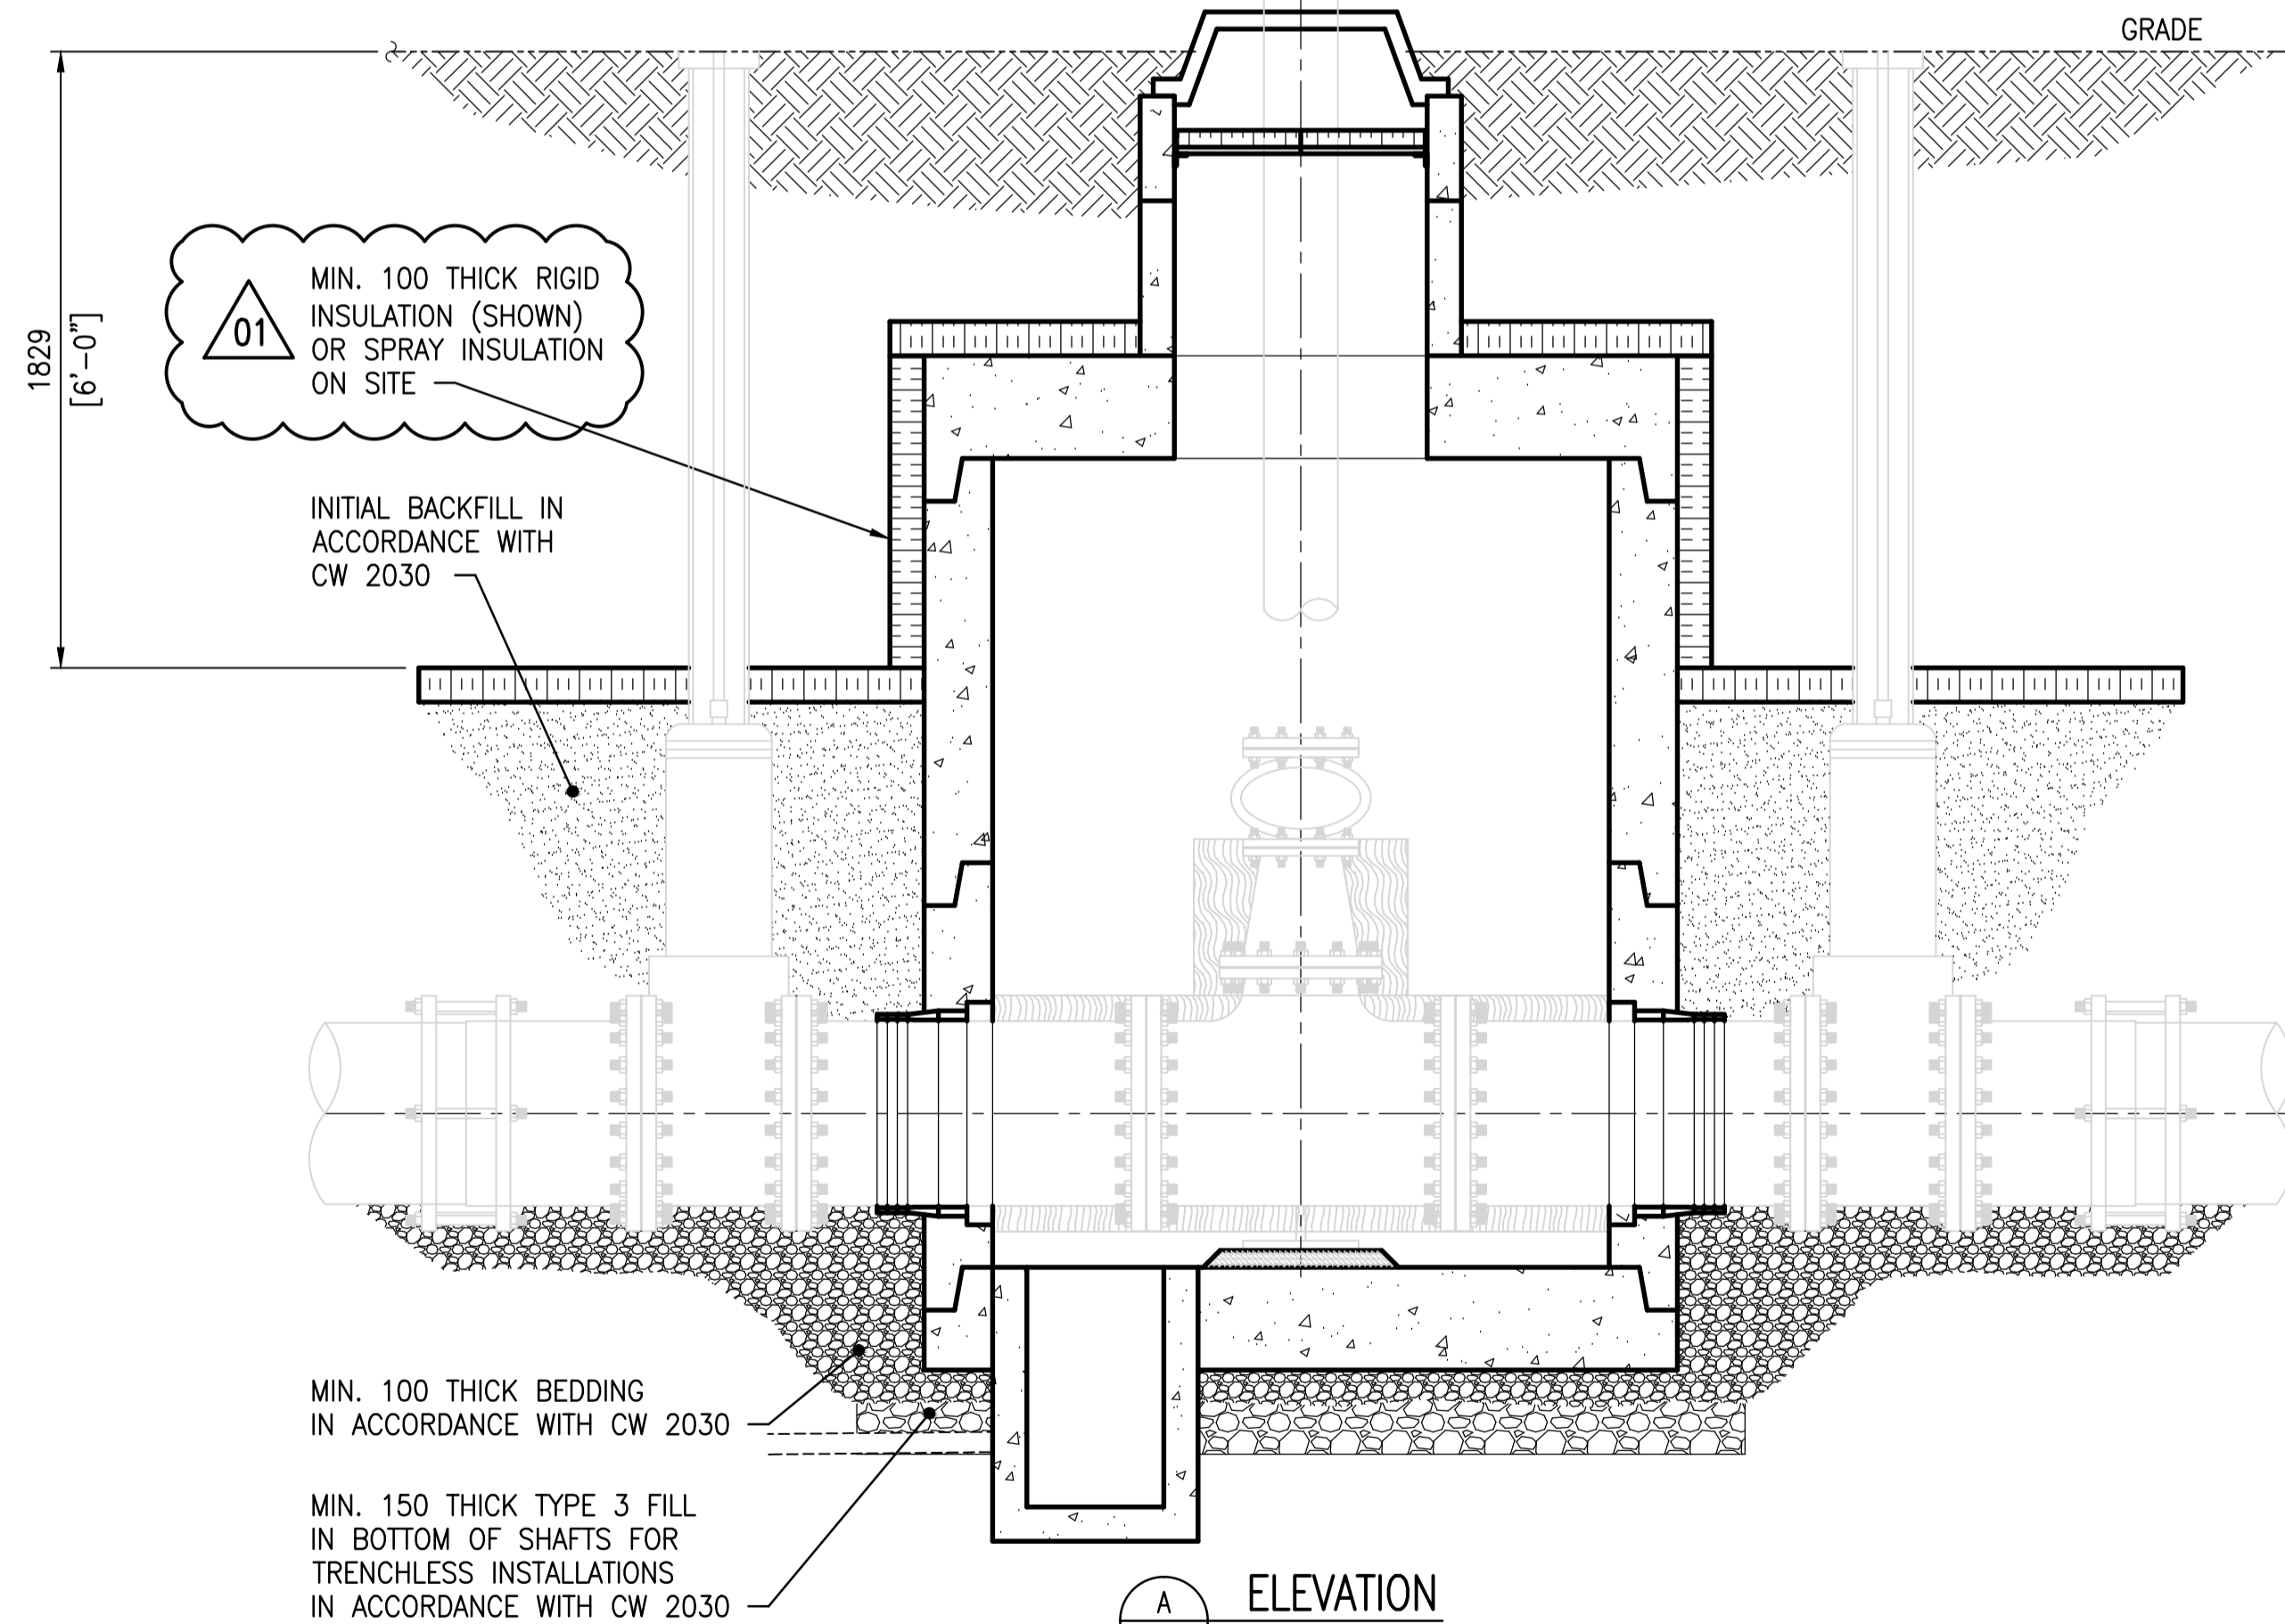


A ELEVATION
SCALE: 1 : 20

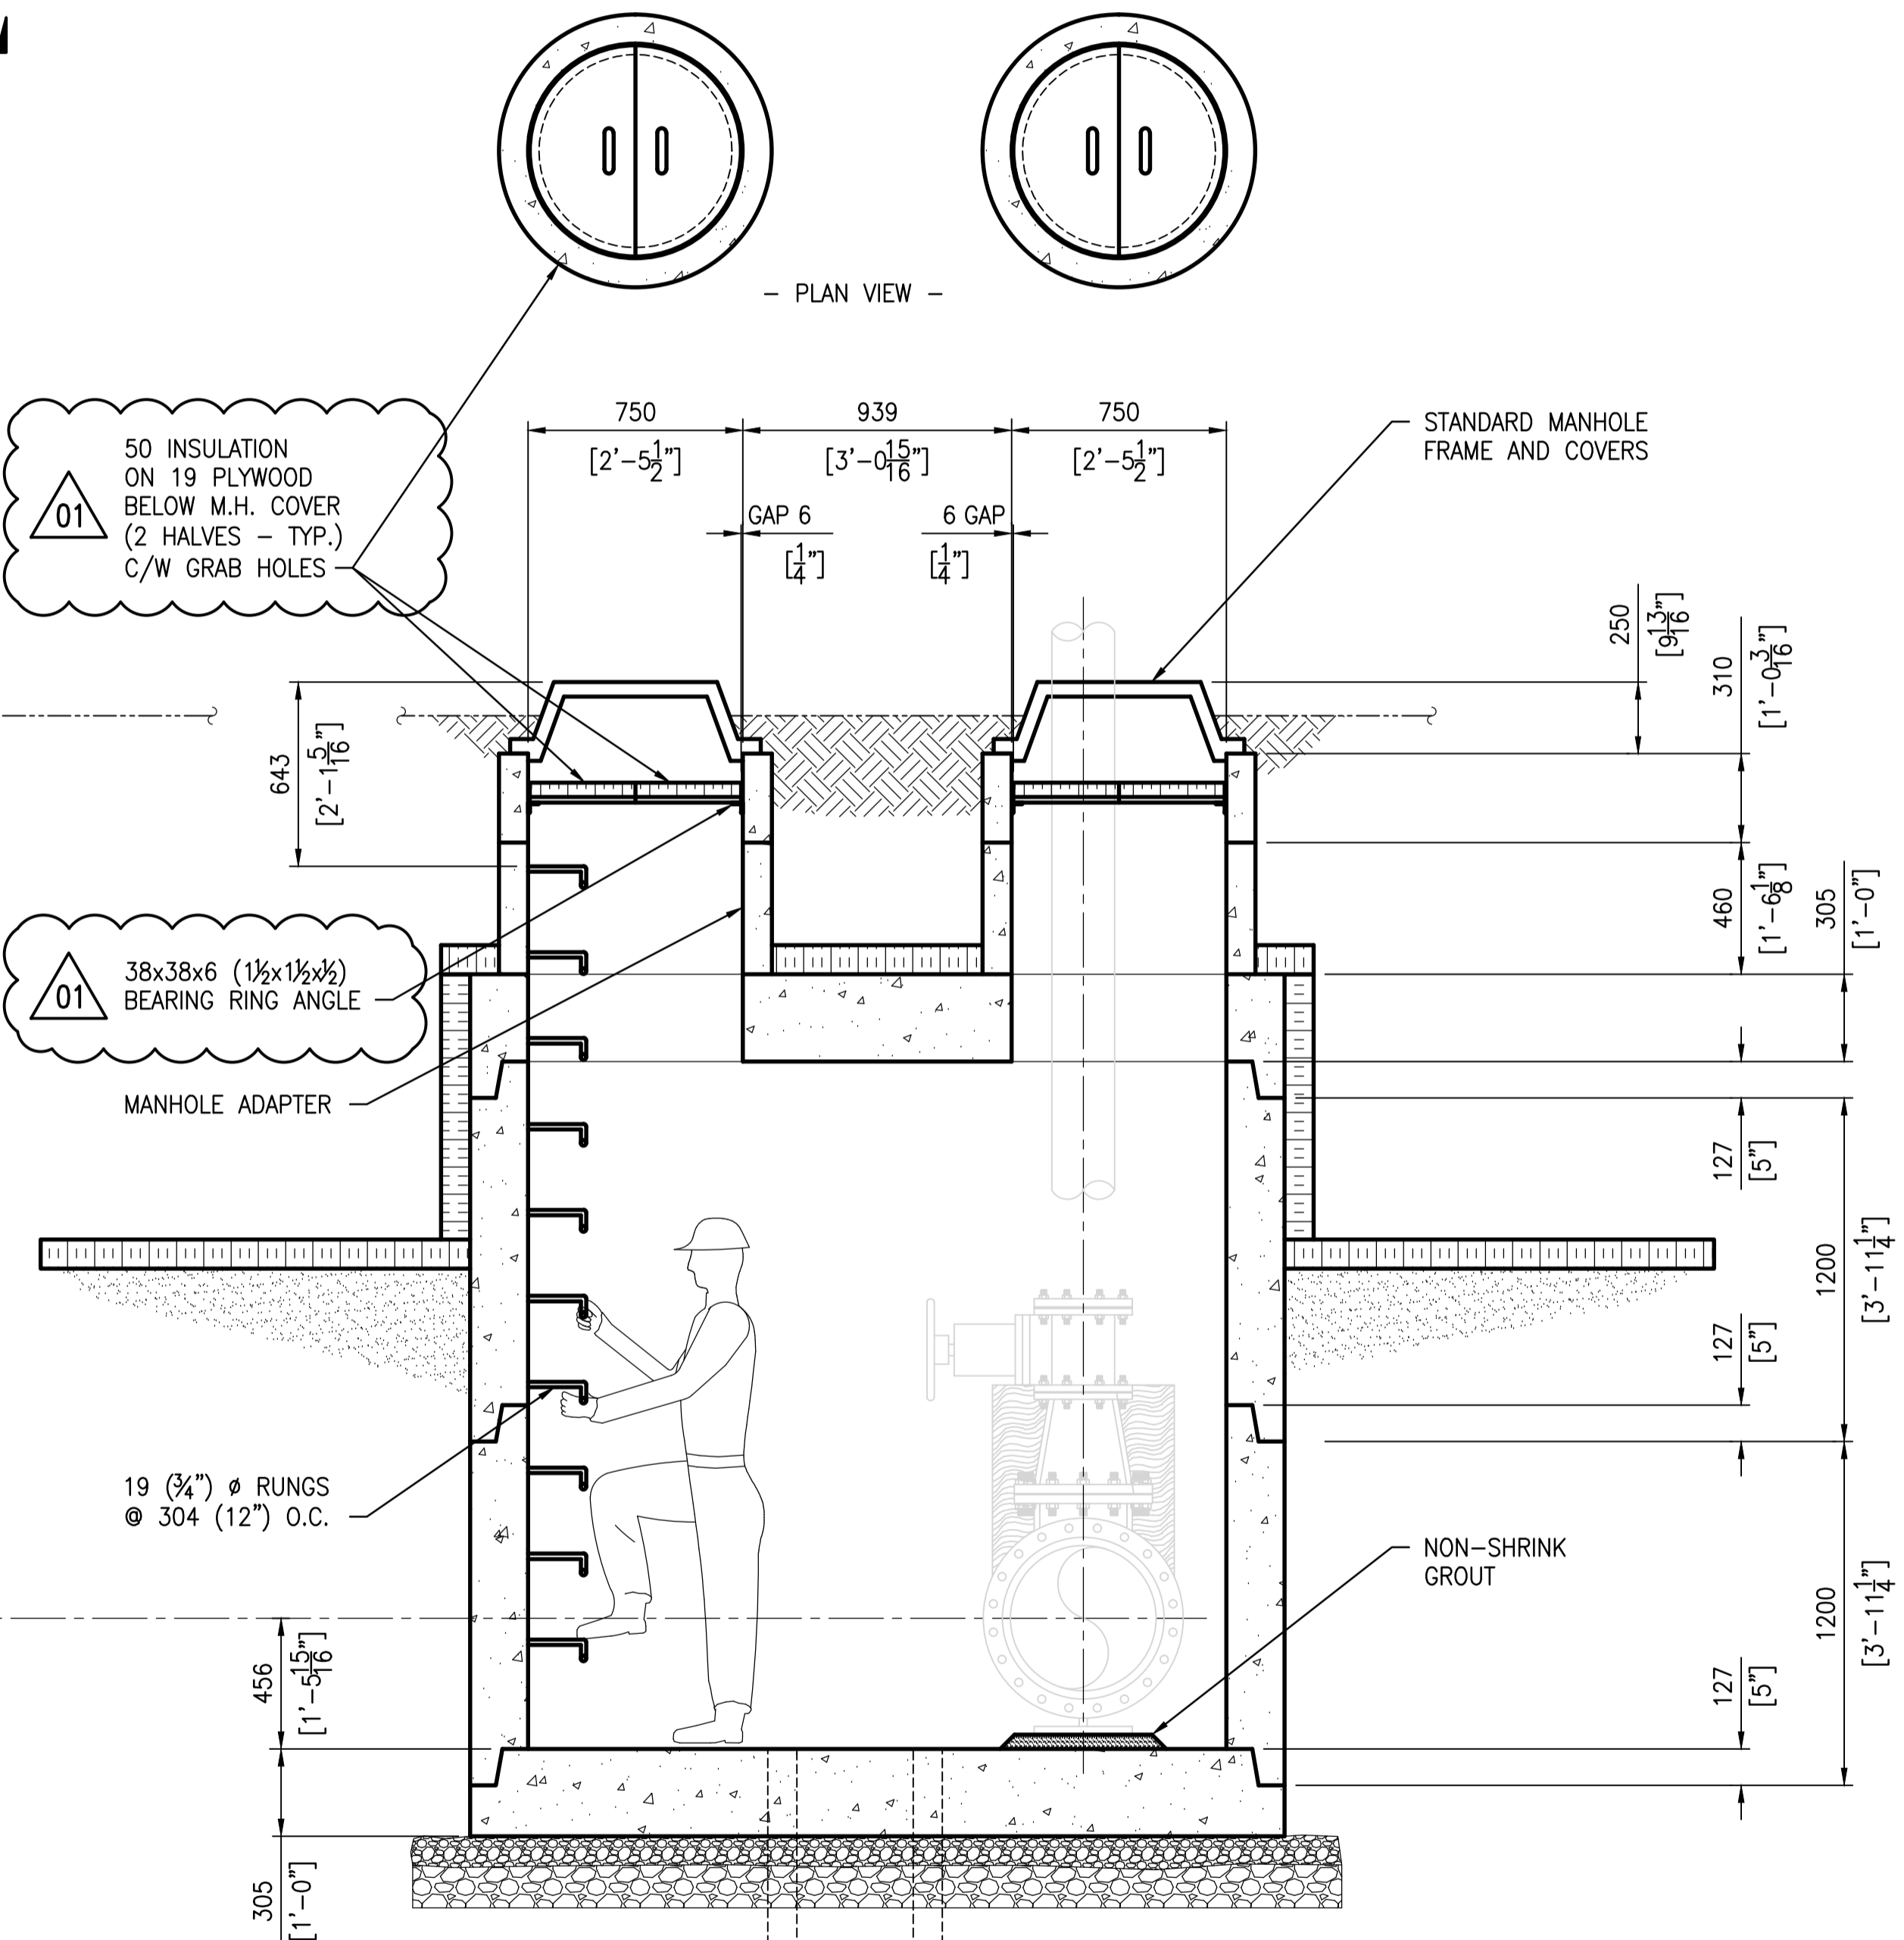

B ELEVATION
SCALE: 1 : 20

- NOTES:**
- SEE DRAWING 1-0169L-S0004 FOR GENERAL NOTES.
 - SEE DRAWING 1-0169L-S0005 FOR STRUCTURAL NOTES.

DRAWING NUMBER	REFERENCE DRAWINGS
S-265	AINSLIE COMM. & PUMPING STATION - SITE PLAN
403-B	AINSLIE COMM. & PUMPING STATION - SUPERSTRUCTURE & DETAILS
403-A	AINSLIE COMM. & PUMPING STATION - REINFORCING DETAILS
403	AINSLIE COMM. & PUMPING STATION

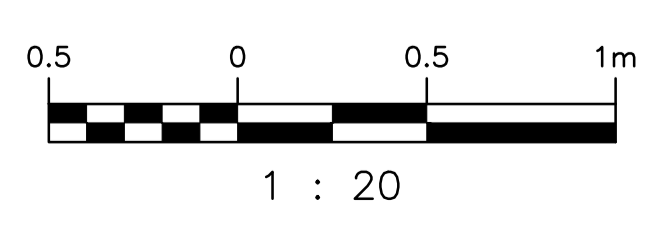

NO.	REVISIONS	DATE	DESIGN/CHECK
01	REVISED INSULATION NOTE/MANHOLE COVER	2015/10/08	
00	ISSUED FOR ADDENDUM - MANHOLE DETAILS	2015/09/28	

 SNC-LAVALIN INC. 148 Nature Park Way Winnipeg, MB, Canada R3P 0X7 204-786-8080	
DESIGNED BY: I. PARKINSON	CHECKED BY:
DRAWN BY: B. DICKSON	APPROVED BY:
SCALE: 1:20	ISSUED FOR CONSTRUCTION
DATE: 2015/09/23	BY:
CONSULTANT NO.:	DATE:

ENGINEER'S SEAL
PRELIMINARY
 NOT TO BE
 USED FOR
 CONSTRUCTION

THE CITY OF WINNIPEG
 WATER AND WASTE DEPARTMENT

OLIVE WASTEWATER LIFT STATION
 2015 UPGRADES
 PLAN AND ELEVATION
 MANHOLE STRUCTURE

CITY DRAWING NUMBER: 1-0169L-S0010
 SHEET: 001
 REV: 01
 SIZE: A1