



THE CITY OF WINNIPEG


WATER AND WASTE DEPARTMENT

BID OPPORTUNITY NO. 600-2016


CIVIL MAINTENANCE/AQUEDUCT STORAGE BUILDING
SUPPLY AND INSTALLATION OF MECHANICAL HEATING AND VENTILATION SYSTEM

MECHANICAL

CITY FILE No.	DRAWING No.	DRAWING TITLE	REV. NO.
1-06001M-D0006-001	CP	COVER PAGE	0
1-06001M-M0003-001	M2.0	HVAC - FLOOR PLANS	1
1-06001M-M0004-001	M2.1	HVAC - PART PLANS	1
1-06001M-M0005-001	M2.2	HVAC - SECTIONS	1
1-060101M-M006-001	M2.3	HVAC - ISOMETRIC	1
1-060101M-M007-001	M2.4	HVAC - DETAILS & SCHEDULES	1

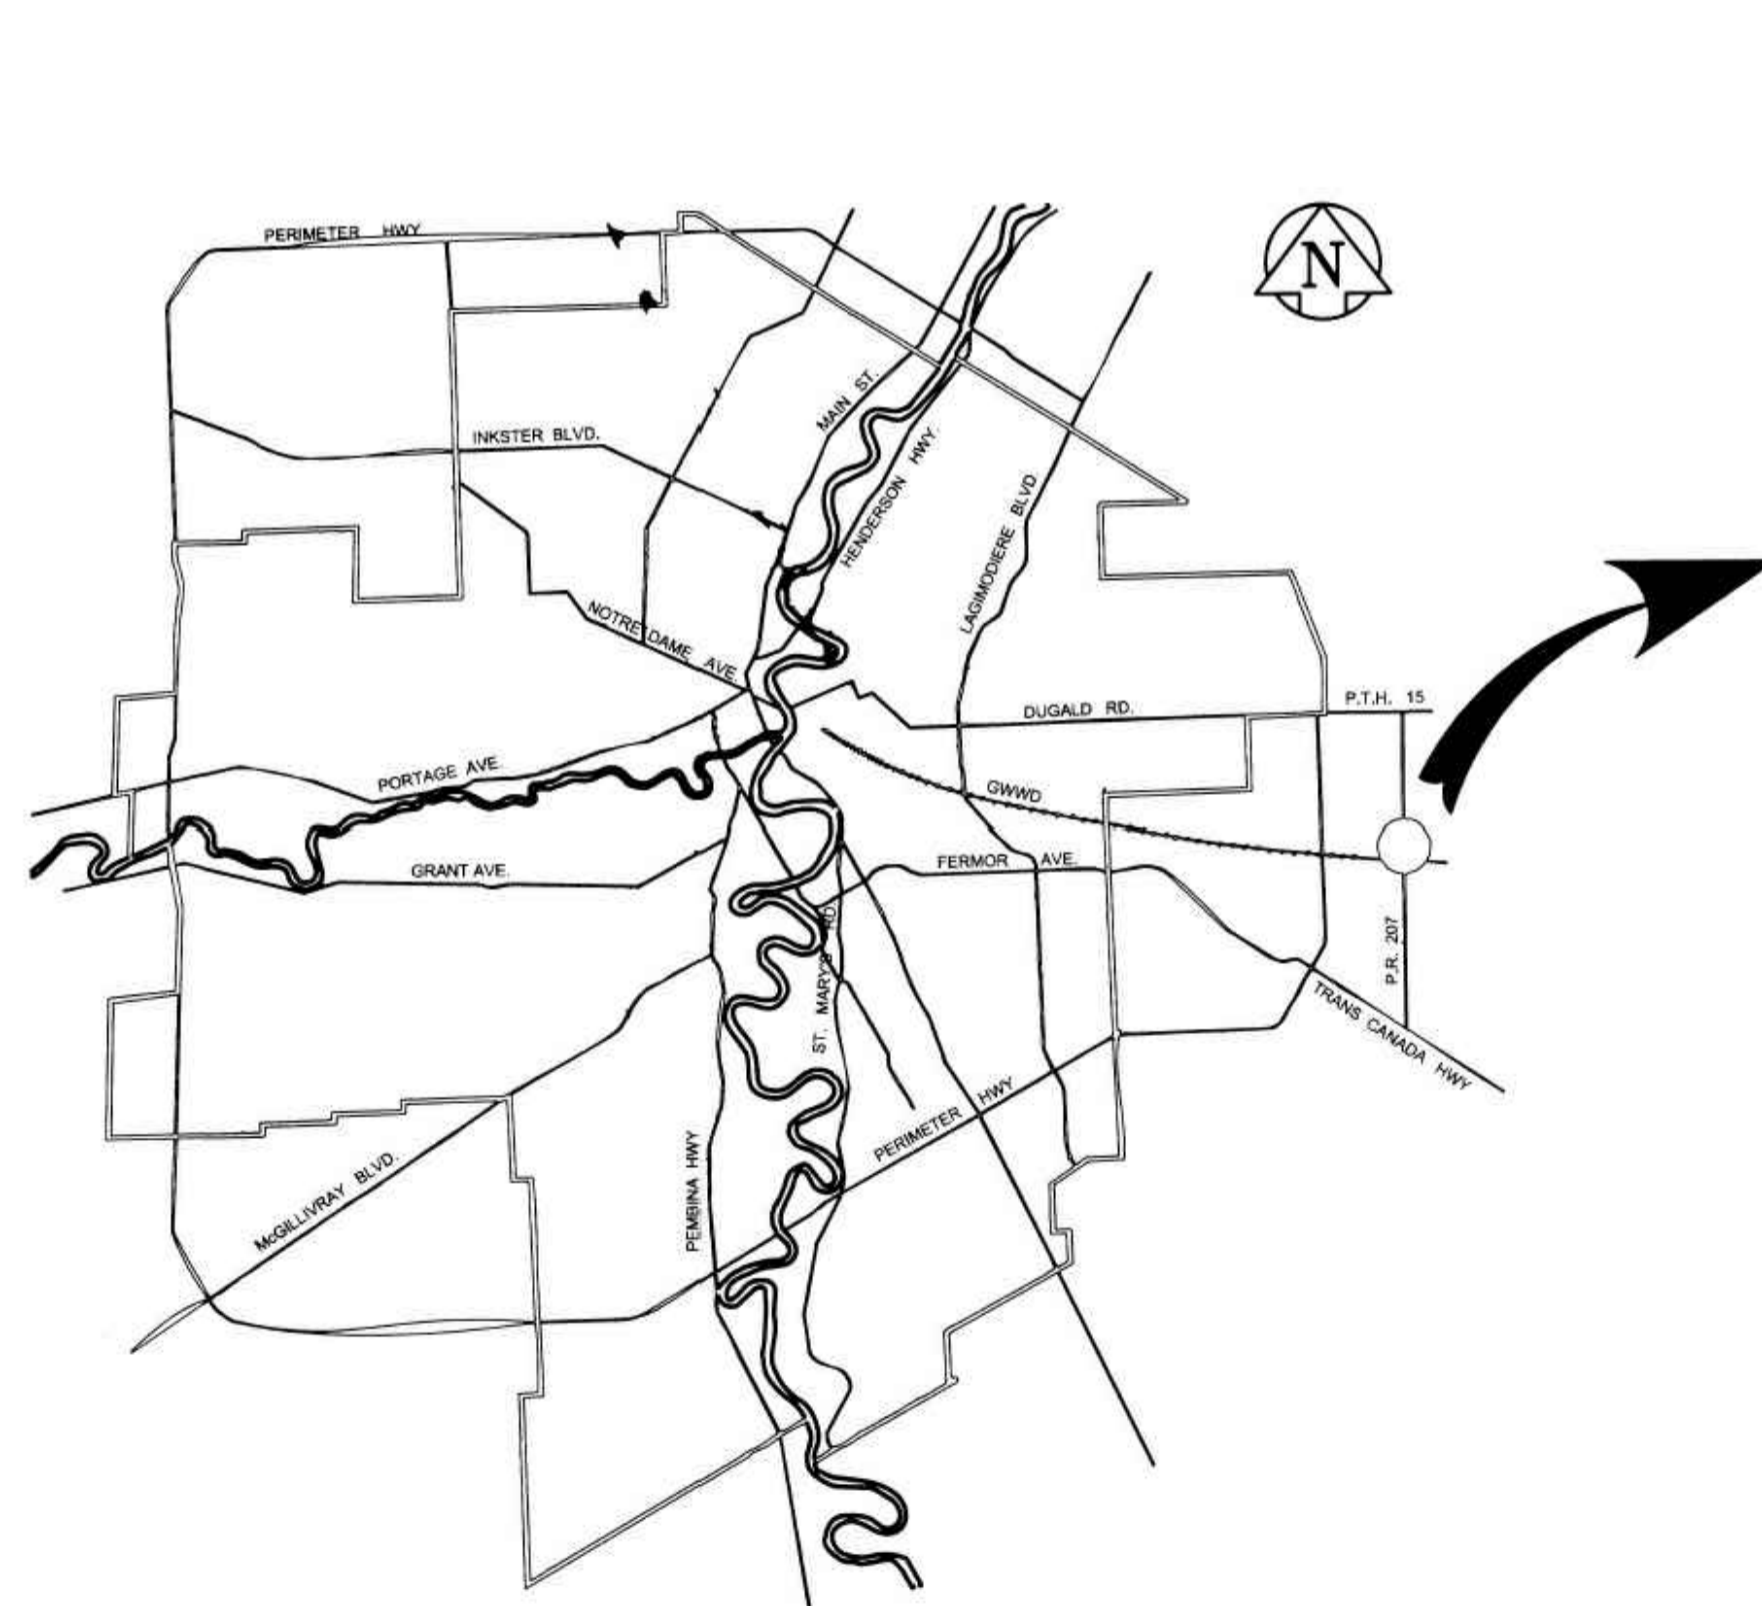

WTP - SITE PLAN

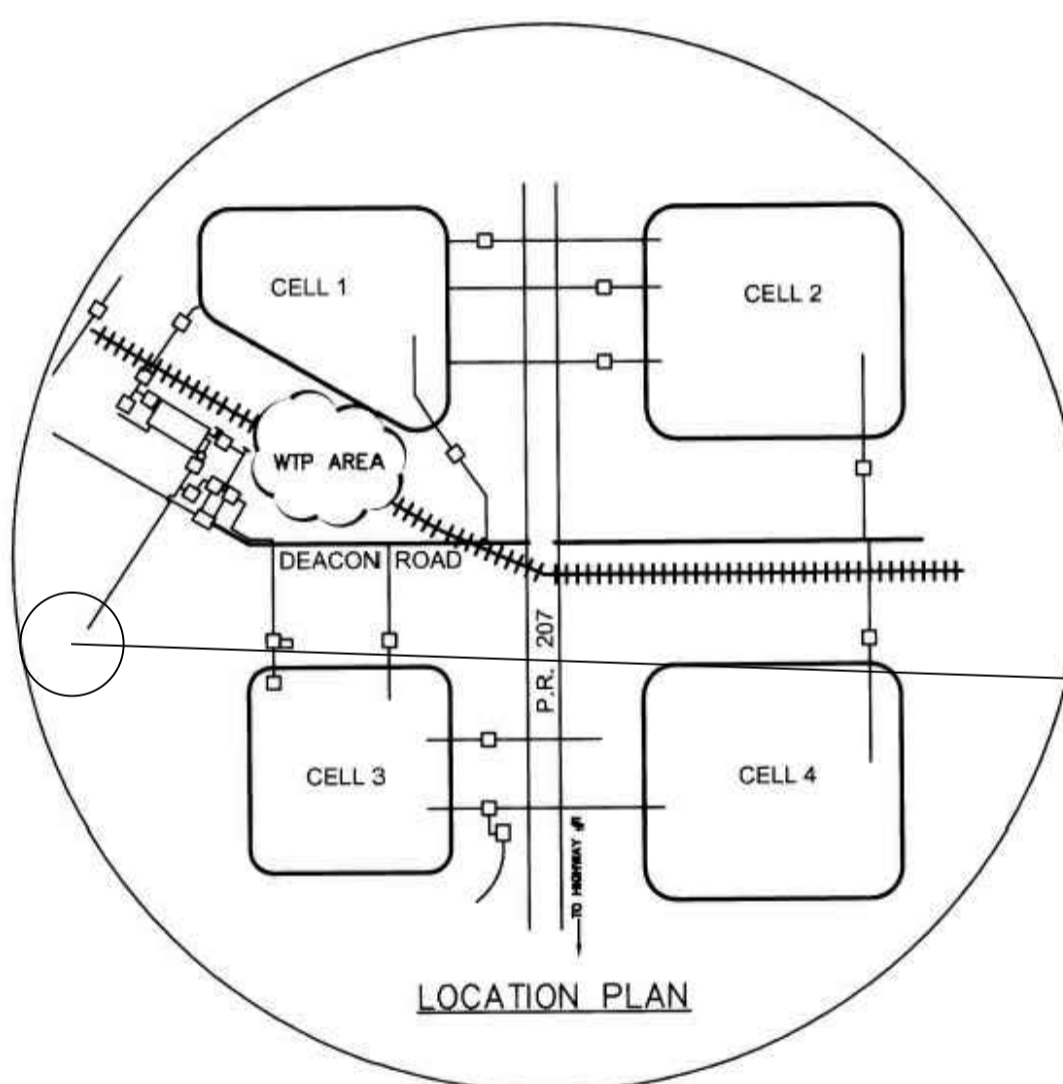

CIVIL MAINTENANCE/AQUEDUCT BUILDING

B.M. ELEV.		FIELD BOOK #:				THE CITY OF WINNIPEG WATER AND WASTE DEPARTMENT	
POSTED TO LBIS							
DESIGNED BY	CHECKED BY	AFG		MAINTENANCE/AQUEDUCT STORAGE BUILDING SITE PLAN & COVER PAGE		SHEET 1 OF 1	
DRAWN BY	APPROVED BY					CITY DRAWING NUMBER	
HOR. SCALE N.T.S.		RELEASED FOR CONSTRUCTION		CONSULTANT DRAWING NO. CP		1-0601M-D0006-001	
VERTICAL		DATE					
0	ISSUED FOR TENDER & CONSTRUCTION	2016-07-14	AFG	DATE		DATE	
NO.	REVISIONS	DATE	BY	DATE		DATE	
				2016-07-14			