


OUTLINE OF BUILDING FOOTPRINT ABOVE


LADDER WITH CAGE GALVANIZED

2400


PLAN AT PUMP FLOOR
1:50

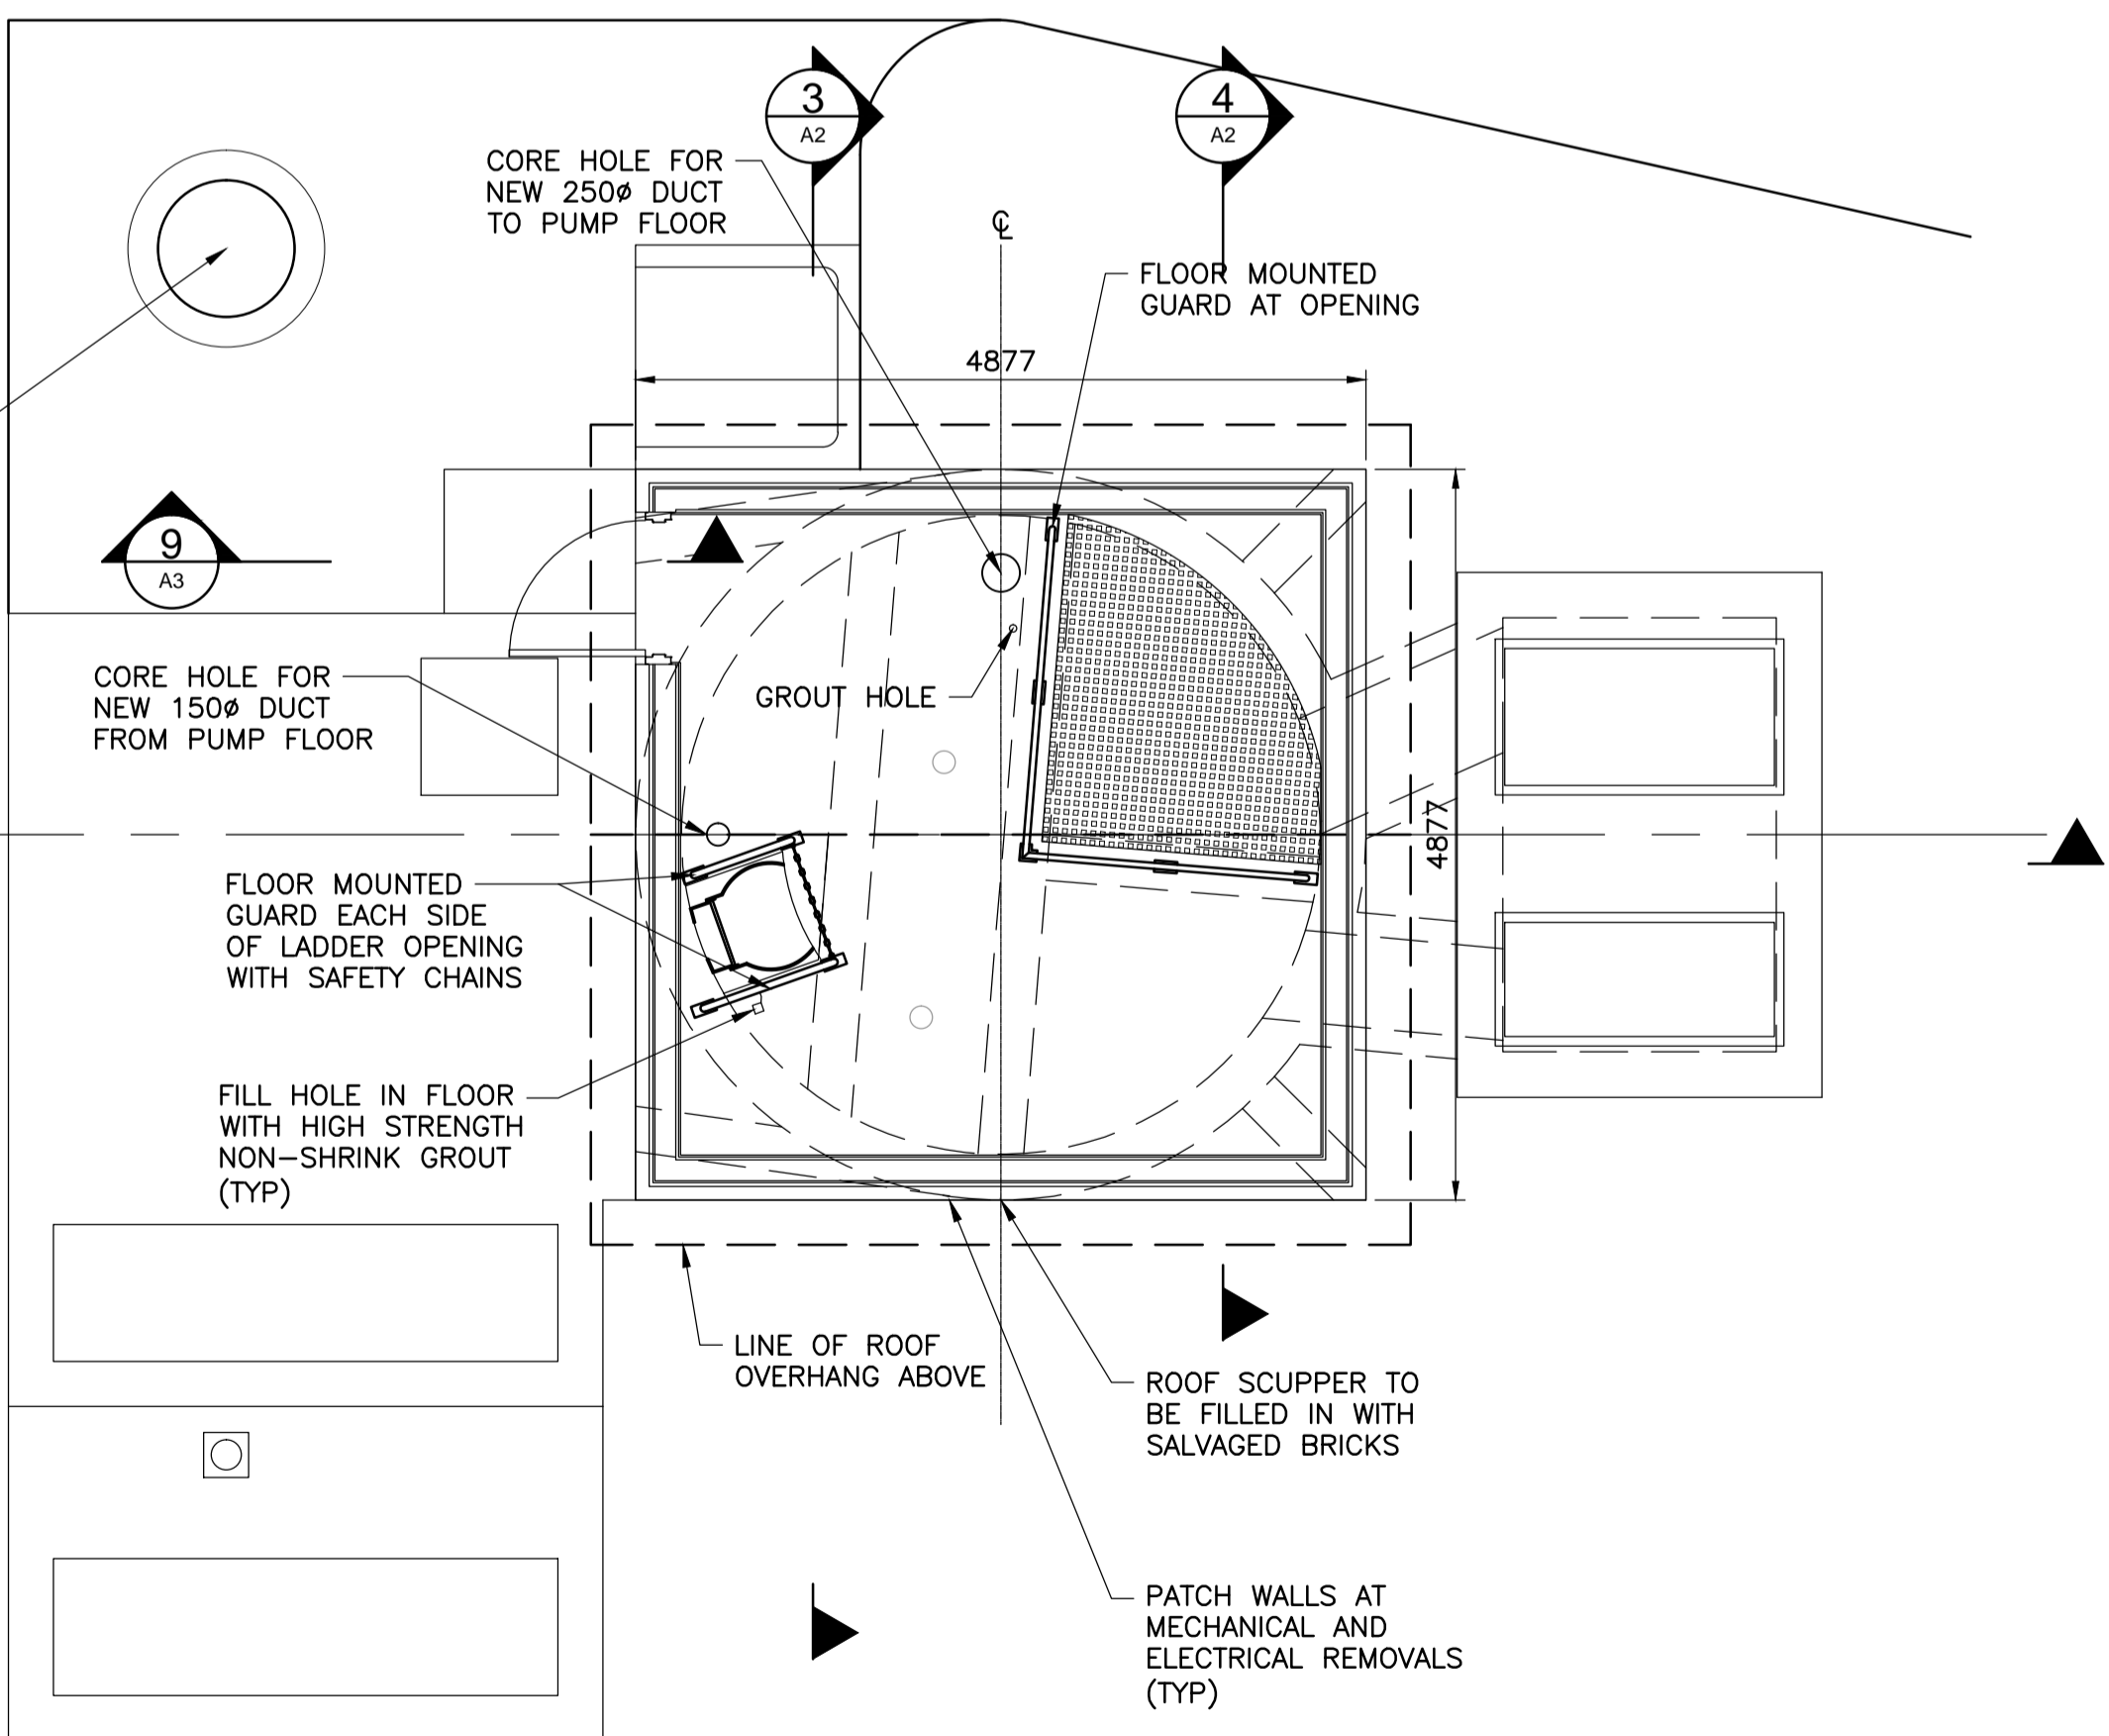

PLAN AT MOTOR FLOOR
1:50

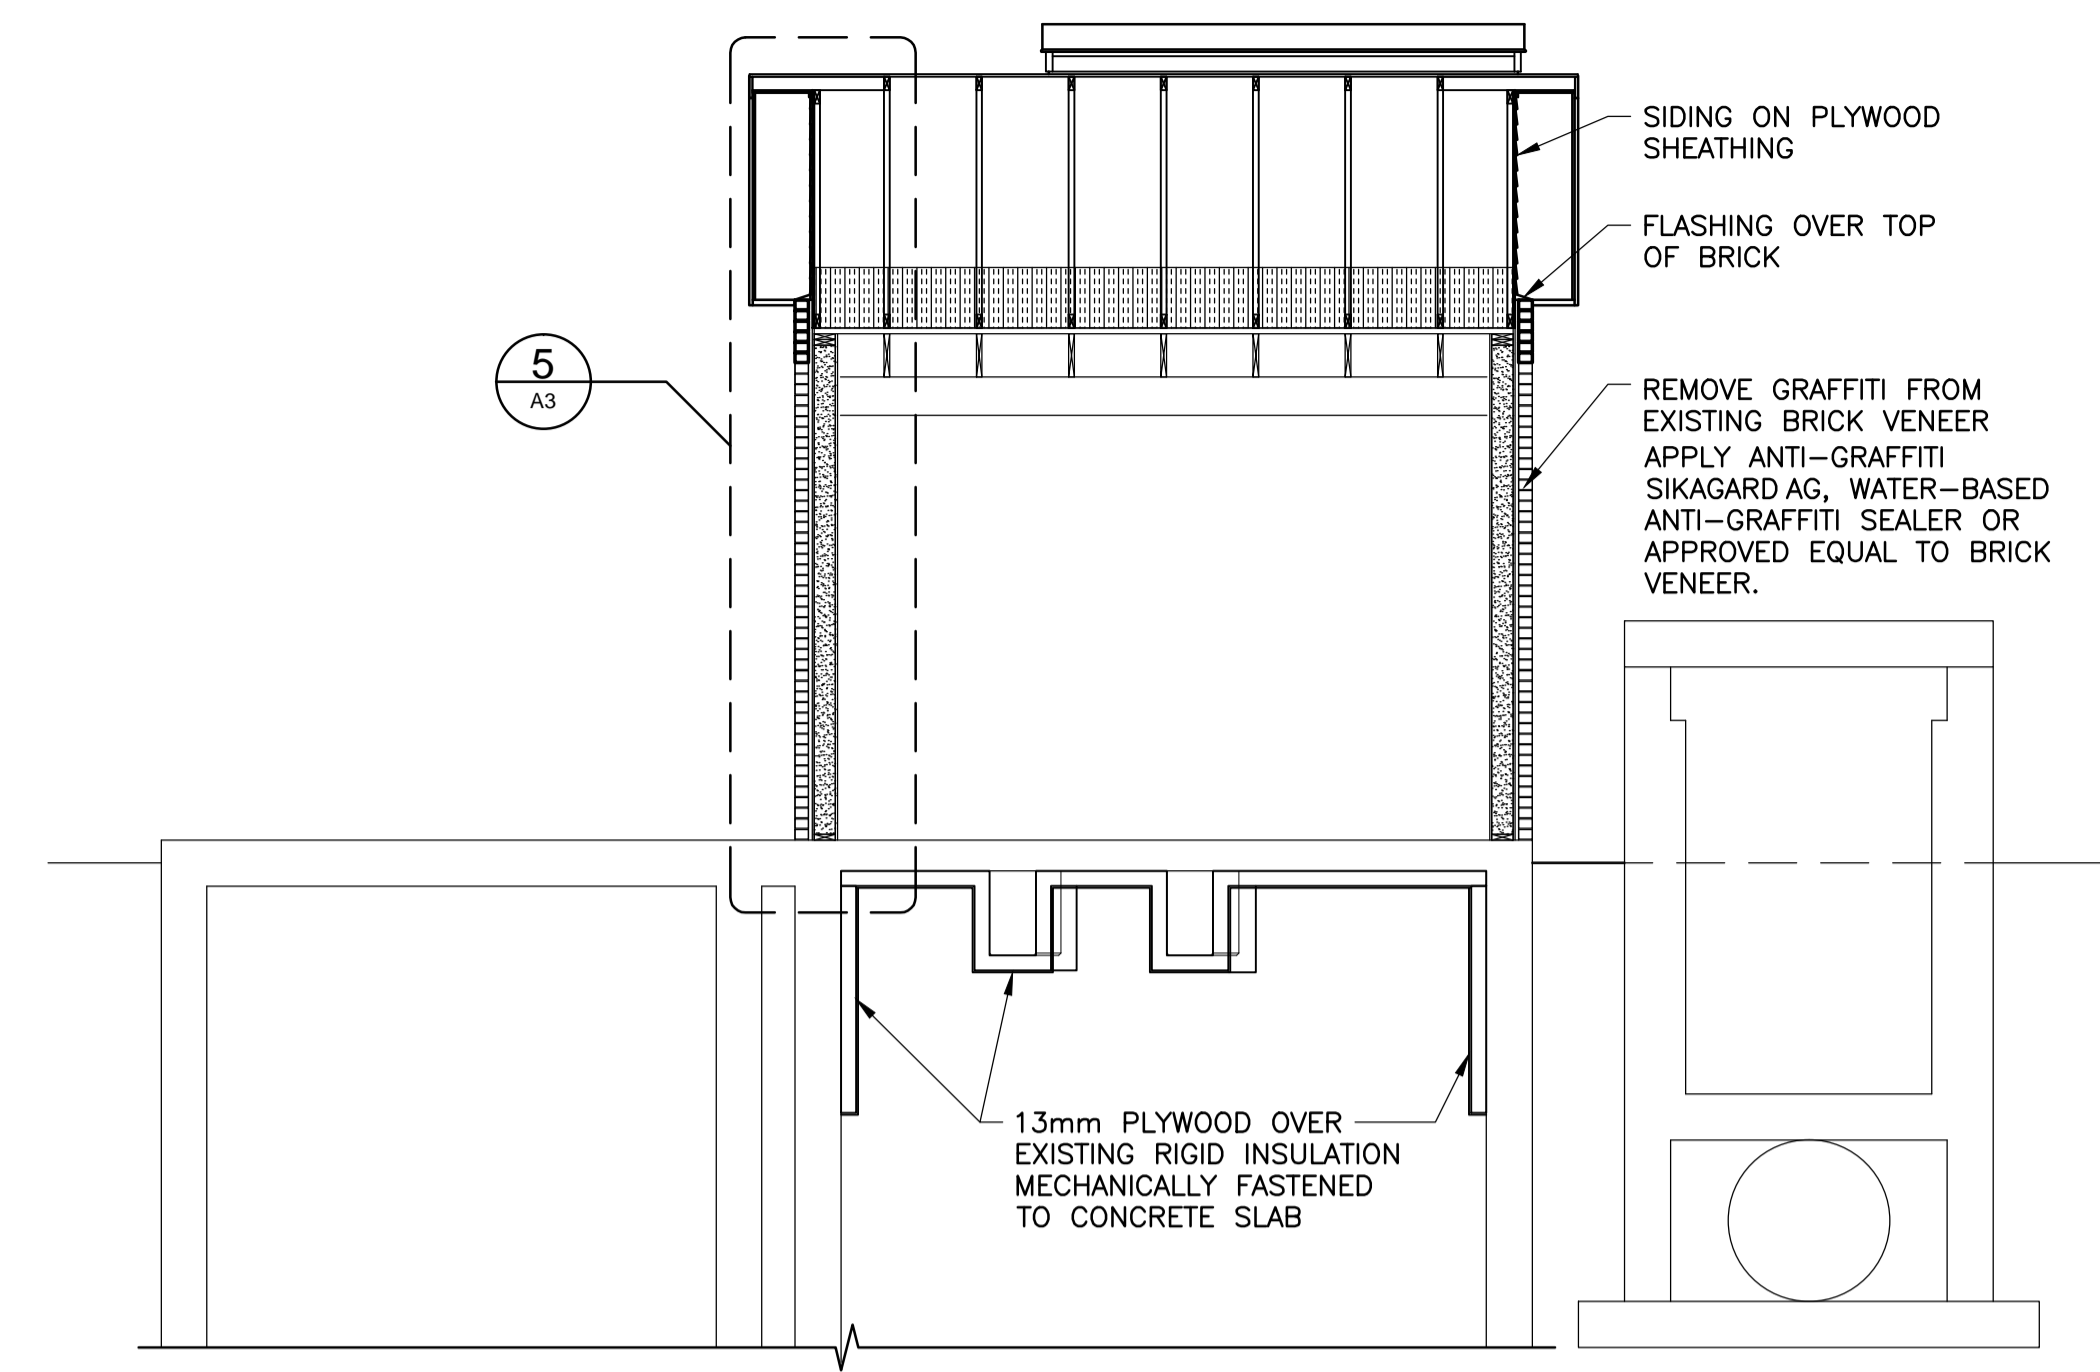

2 CROSS SECTION
1:50

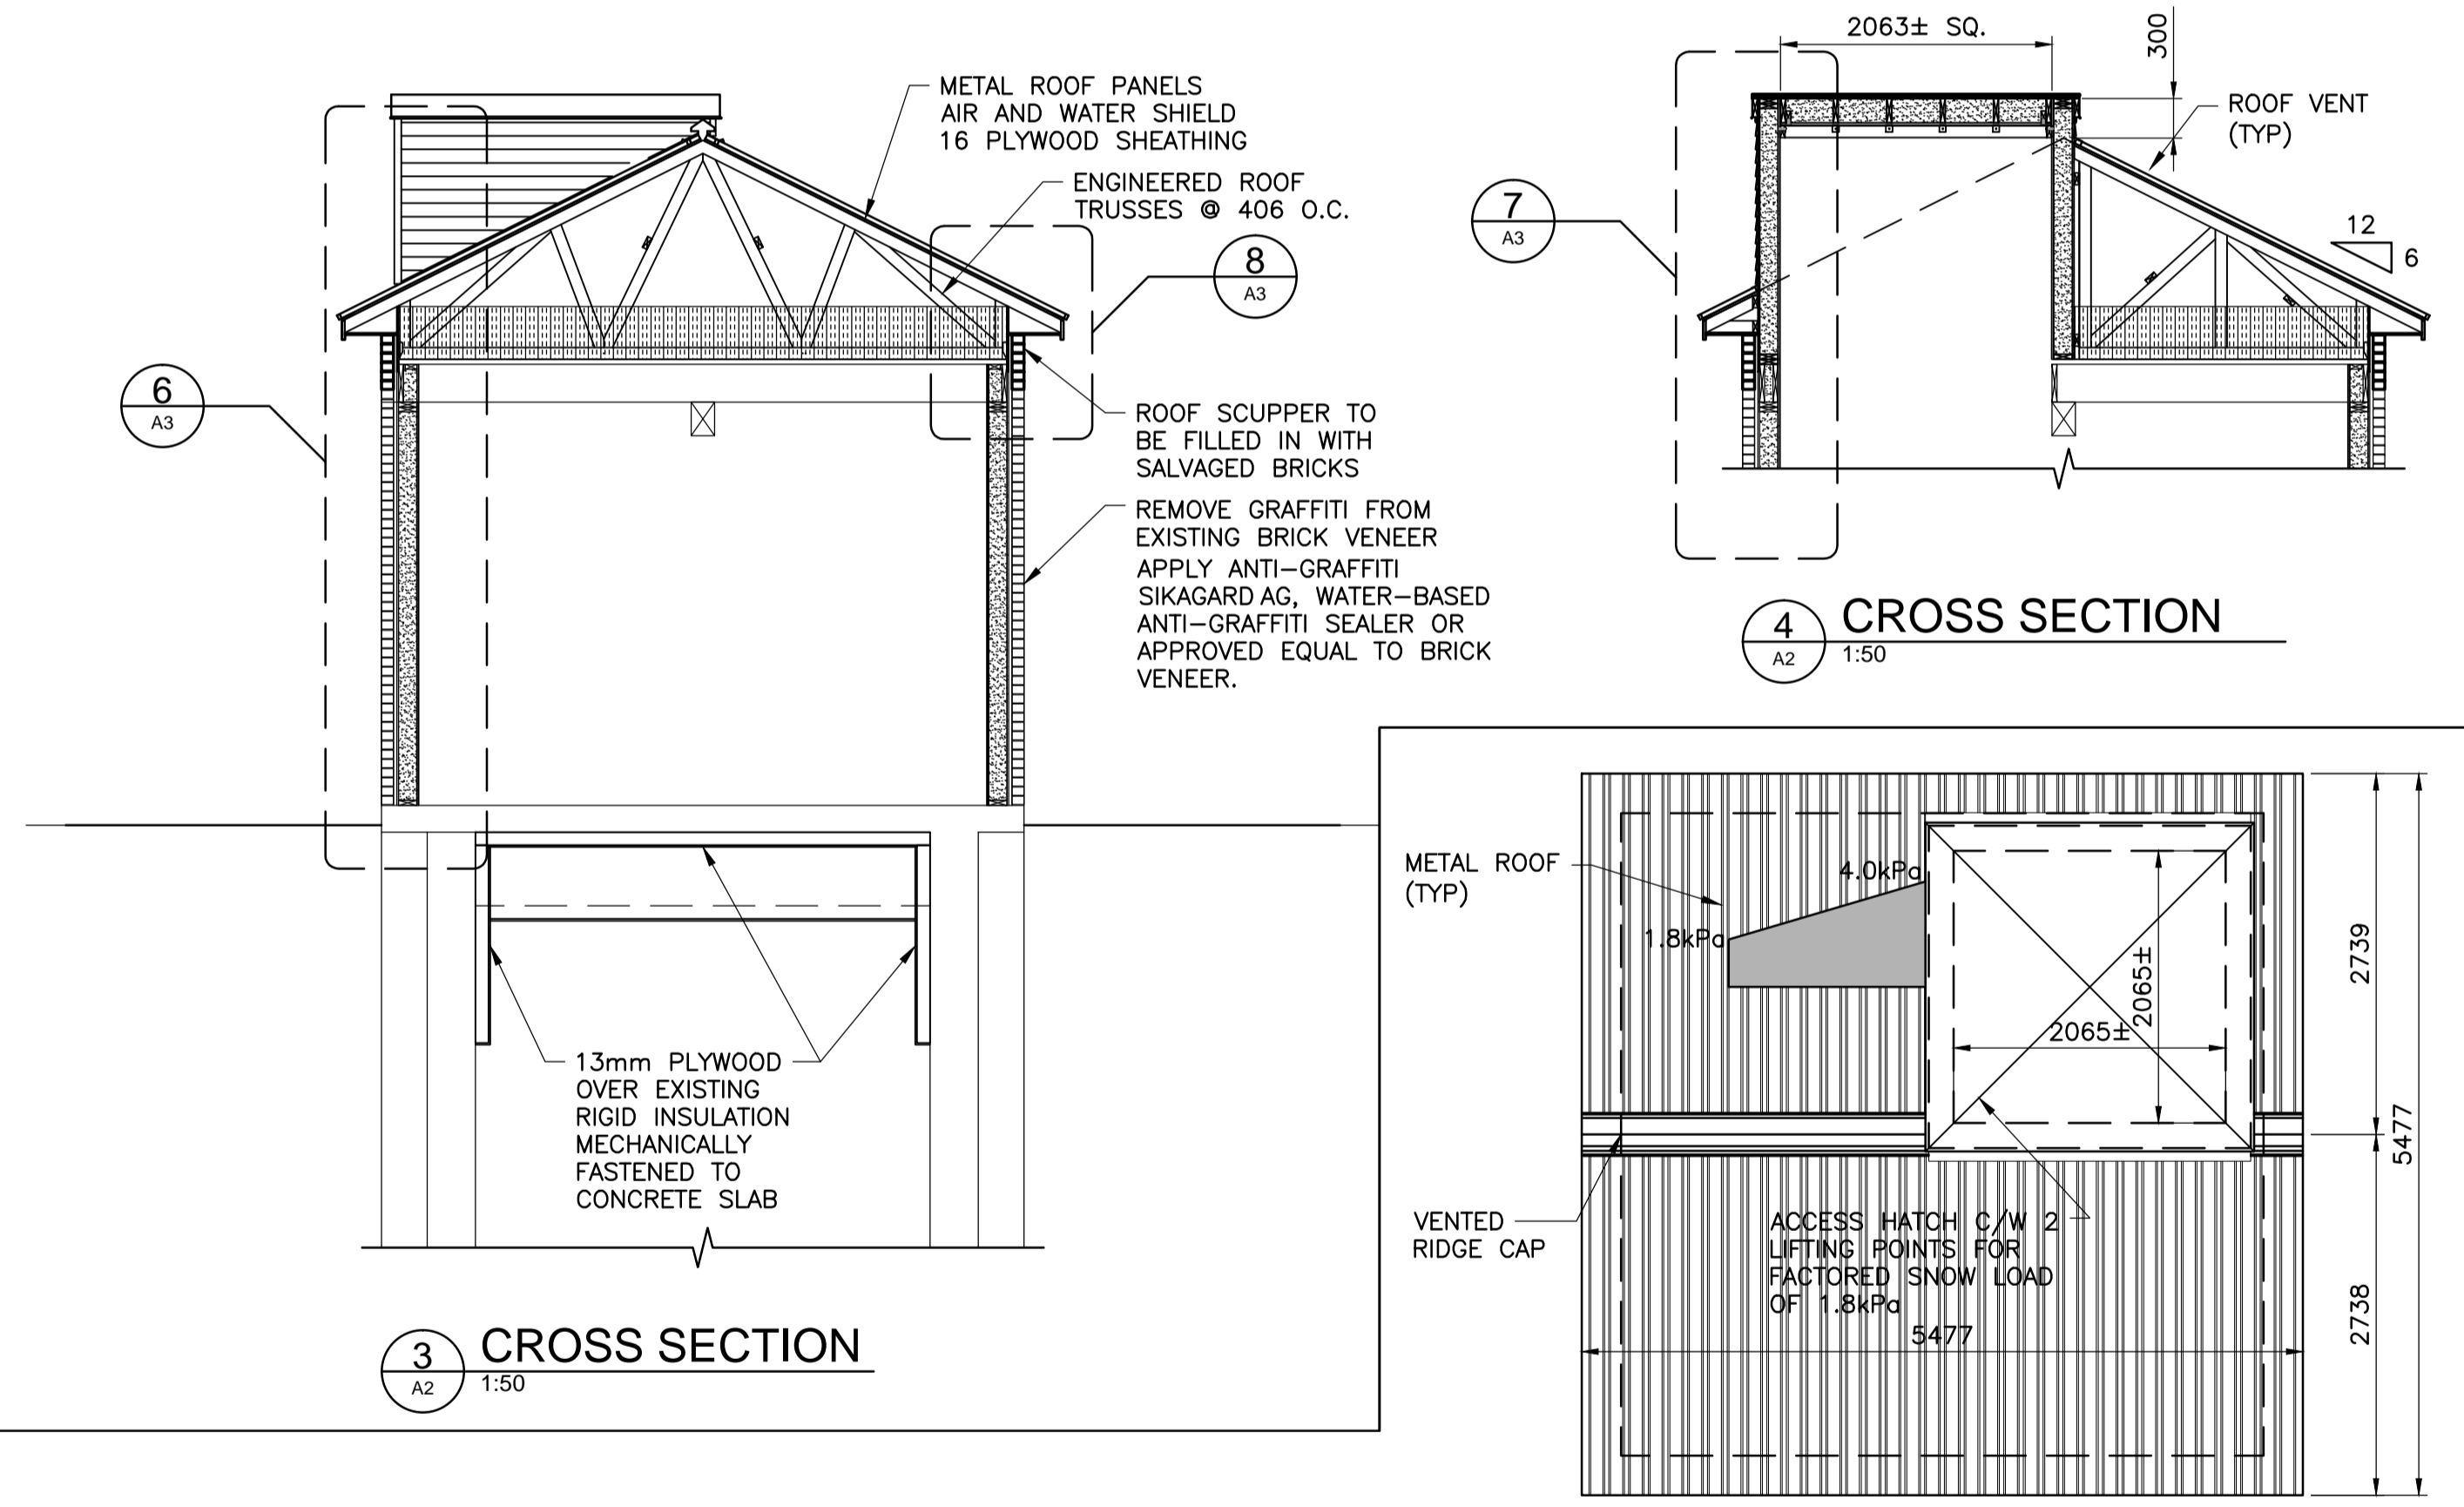

3 CROSS SECTION
1:50

4 CROSS SECTION
1:50

ROOF PLAN WITH SNOW LOADINGS
1:50

NOTE:
IMPORTANT FACTOR: $I_s = 1.25$
(FACTOR TO BE APPLIED TO THE SHOWN VALUES)

METRIC

WHOLE NUMBERS INDICATE MILLIMETRES
DECIMALIZED NUMBERS INDICATE METRES

FILENAME: C:\PROJECTS\WORKING DIRECTORY\PROJECTS\2018\40SK\UNOS3\651\18872_01_ARCH\DESIGN PLOTTED BY: KOWALSKI, STANLEY

B.M. ELEV.		DESIGNED BY	JAA		ENGINEER'S SEAL		THE CITY OF WINNIPEG WATER AND WASTE DEPARTMENT			
		DRAWN BY	PDR				CONSULTANT PROJECT NUMBER 18-6872	SYNDICATE FLOOD PUMPING STATION UPGRADES		
		CHECKED BY	NR					RELEASED FOR CONSTRUCTION NOT FOR CONSTRUCTION	CITY DRAWING NUMBER 1-0189F-B0002-001	
		APPROVED BY	MH						SHEET 2 OF 7	
2	ISSUED FOR ADDENDUM 1	05/07/18	NR	HOR. SCALE	AS SHOWN	NEW CONSTRUCTION FLOOR PLANS, CROSS SECTIONS				
1	ISSUED FOR TENDER	15/06/18	BLM	VERTICAL		CONSULTANT DRAWING NUMBER A2				
NO.	REVISIONS	DATE	BY	DATE						